


MATCH LINE SEE DRAWING GP-8
WEST FRONTAGE CONNECTOR
STA. 6035+50.00
RAMP C STA. 1990+89.59

MATCH LINE SEE DRAWING GP-8
ARSENAL RD STA. 918+00.00

MATCH LINE SEE DRAWING GP-10
WEST FRONTAGE CONNECTOR
STA. 6050+00.00

MATCH LINE SEE DRAWING GP-10
ARSENAL RD STA. 932+50.00

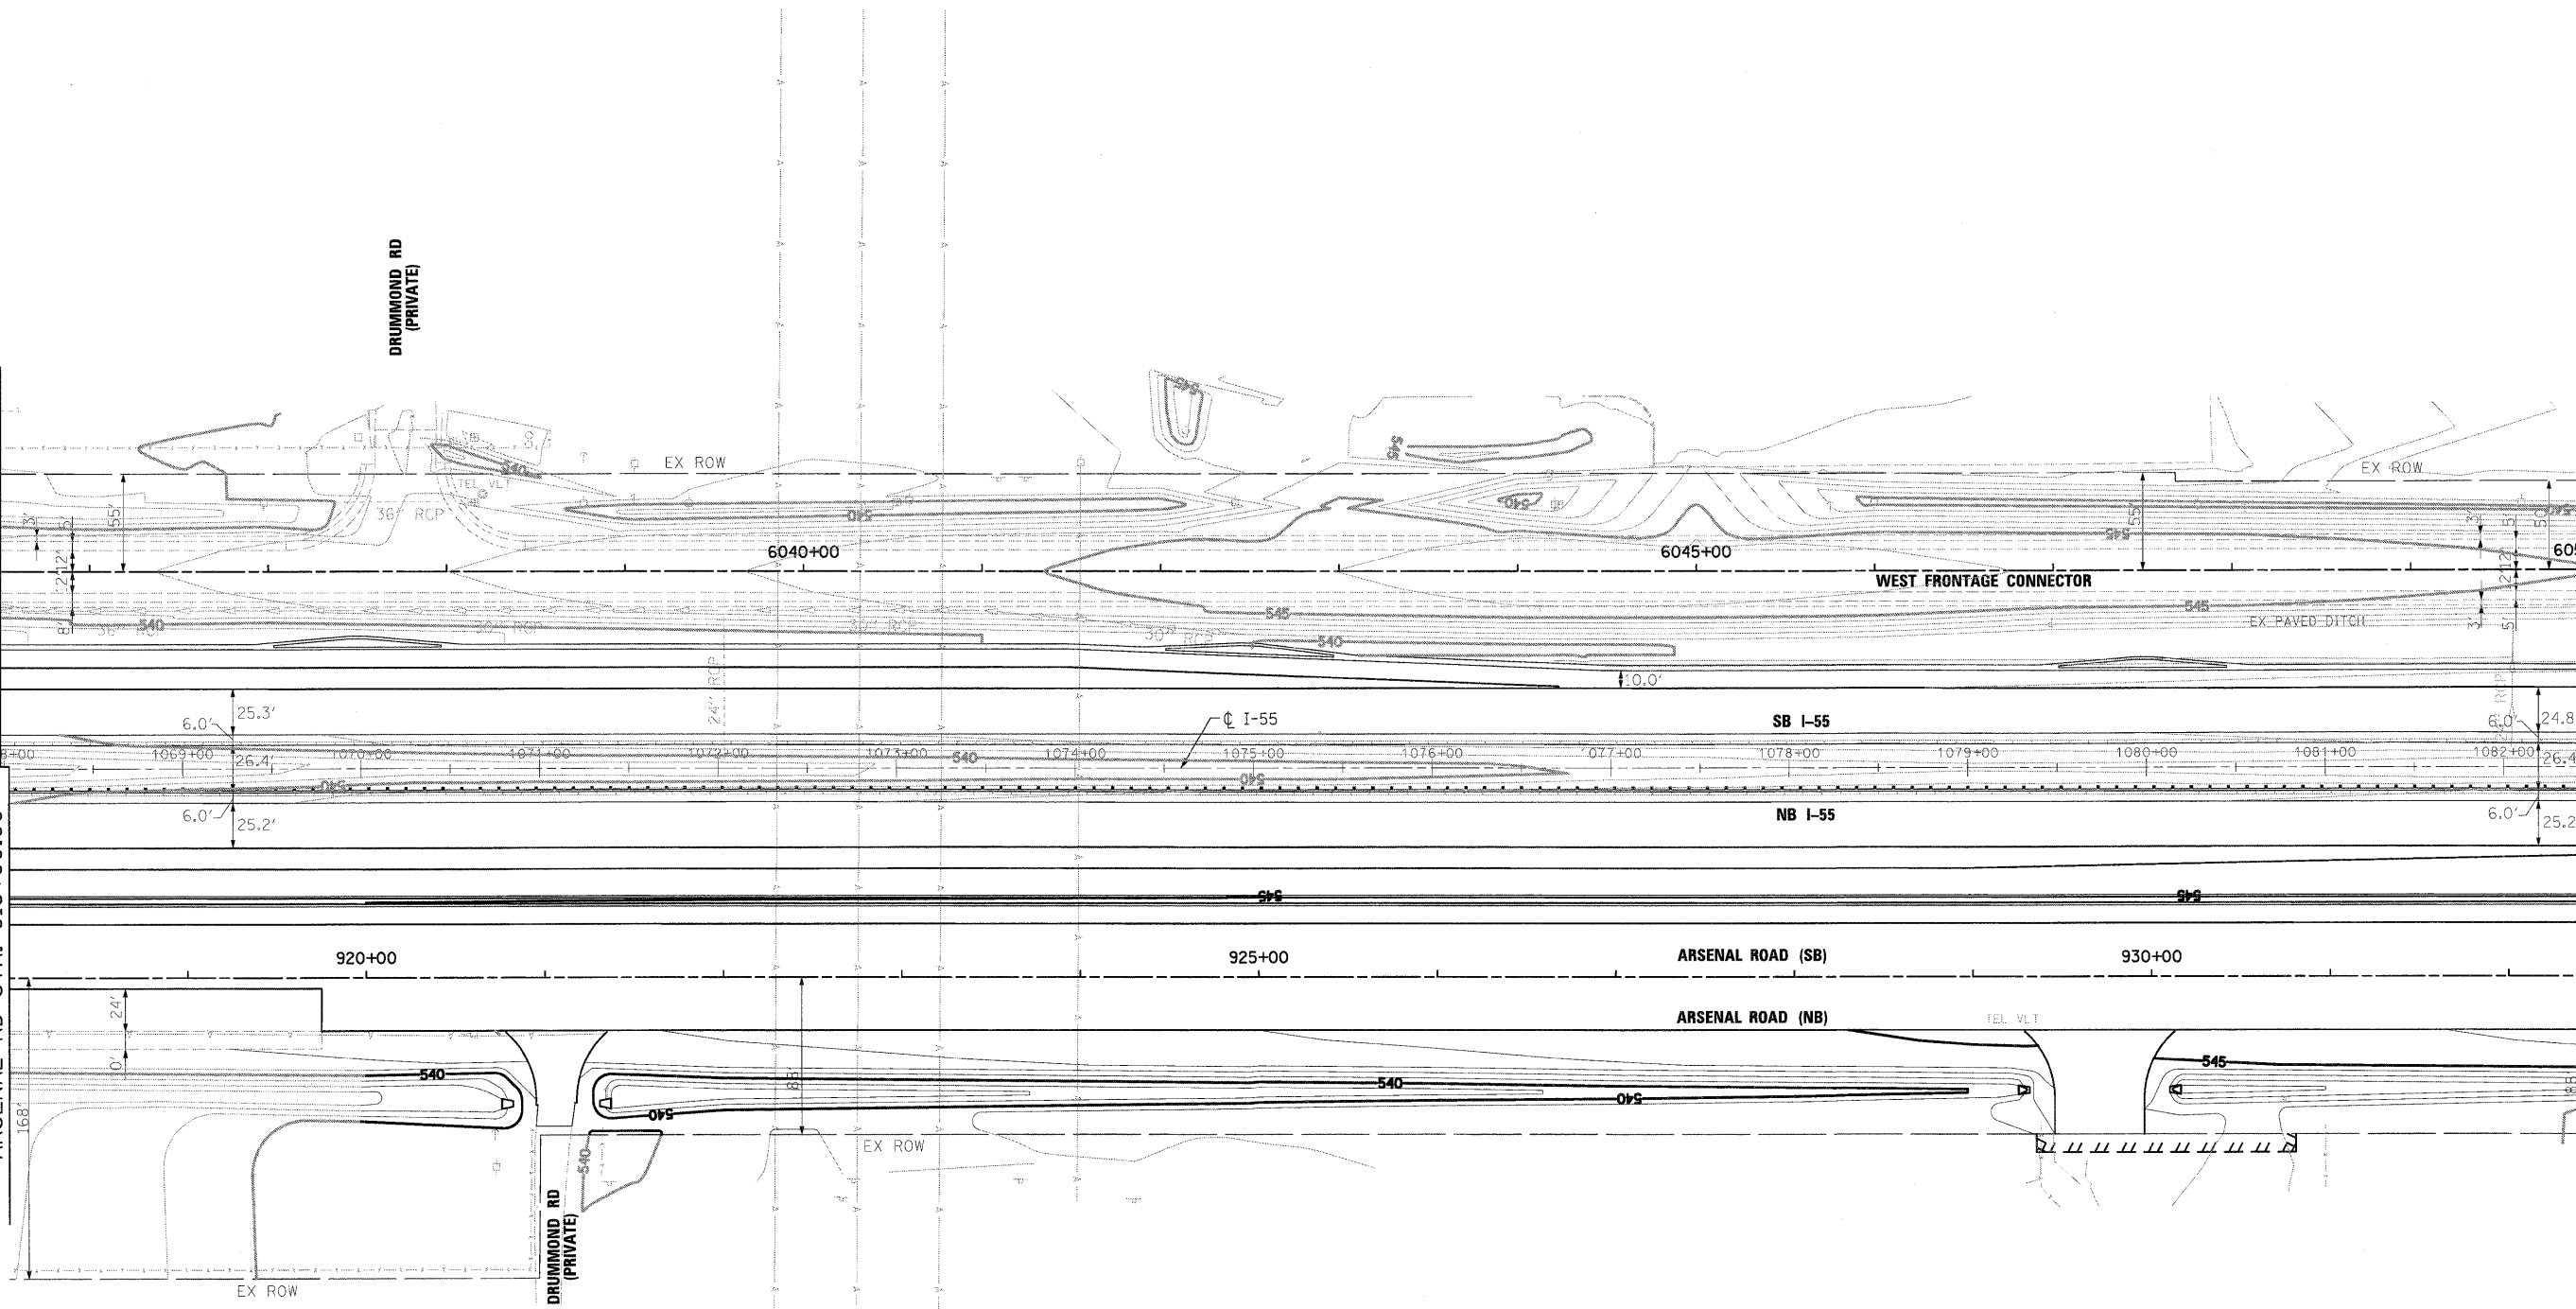

McDonough Associates Inc.
Engineers / Architects
130 East Randolph Street, Chicago, Illinois 60601


FILE NAME =
D160F12-SHT-GRADING09.dgn

USER NAME = TK1uege1	DESIGNED - MJT	REVISED -
PLDT SCALE = 1:50	DRAWN - MJT	REVISED -
PLDT DATE = 2/3/2011	CHECKED - DLT	REVISED -
	DATE - 2/4/11	REVISED -

**STATE OF ILLINOIS
DEPARTMENT OF TRANSPORTATION**

GRADING PLAN

SCALE: 1"=50' SHEET NO. 9 OF 15 SHEETS STA. TO STA.

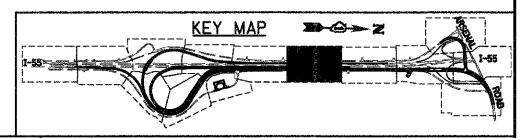

F.A.I. RTE.	SECTION	COUNTY	TOTAL SHEETS	SHEET NO.
55	99-2HB-2B-1	WILL	756	213
CONTRACT NO. 60F12				
FED. ROAD DIST. NO. 1 ILLINOIS FED. AID PROJECT				