
 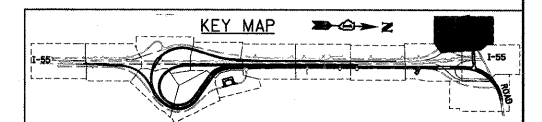



NOTES:

1. SEE DRAWING GE-1 FOR ELECTRICAL SYMBOLS AND ABBREVIATIONS. SEE DRAWING GE-2 FOR ELECTRICAL GENERAL NOTES AND SUGGESTED LIGHTING PHASING NOTES.
2. THE CONTRACTOR SHALL REMOVE HIGH MAST LIGHT TOWER. THIS WORK SHALL BE INCLUDED IN THE "REMOVAL OF EXISTING HIGH MAST LIGHT TOWER, SALVAGE" PAY ITEM. SEPARATE PAYMENT WILL NOT BE MADE.
3. THE CONTRACTOR SHALL REMOVE HIGH MAST LIGHT TOWER FOUNDATION. ABANDON UNDERGROUND WIRING AS SHOWN. THIS WORK SHALL BE INCLUDED IN THE "FOUNDATION REMOVAL" PAY ITEM. SEPARATE PAYMENT WILL NOT BE MADE.
4. EXISTING LIGHTING CONTROLLER "T" SHALL REMAIN IN SERVICE.

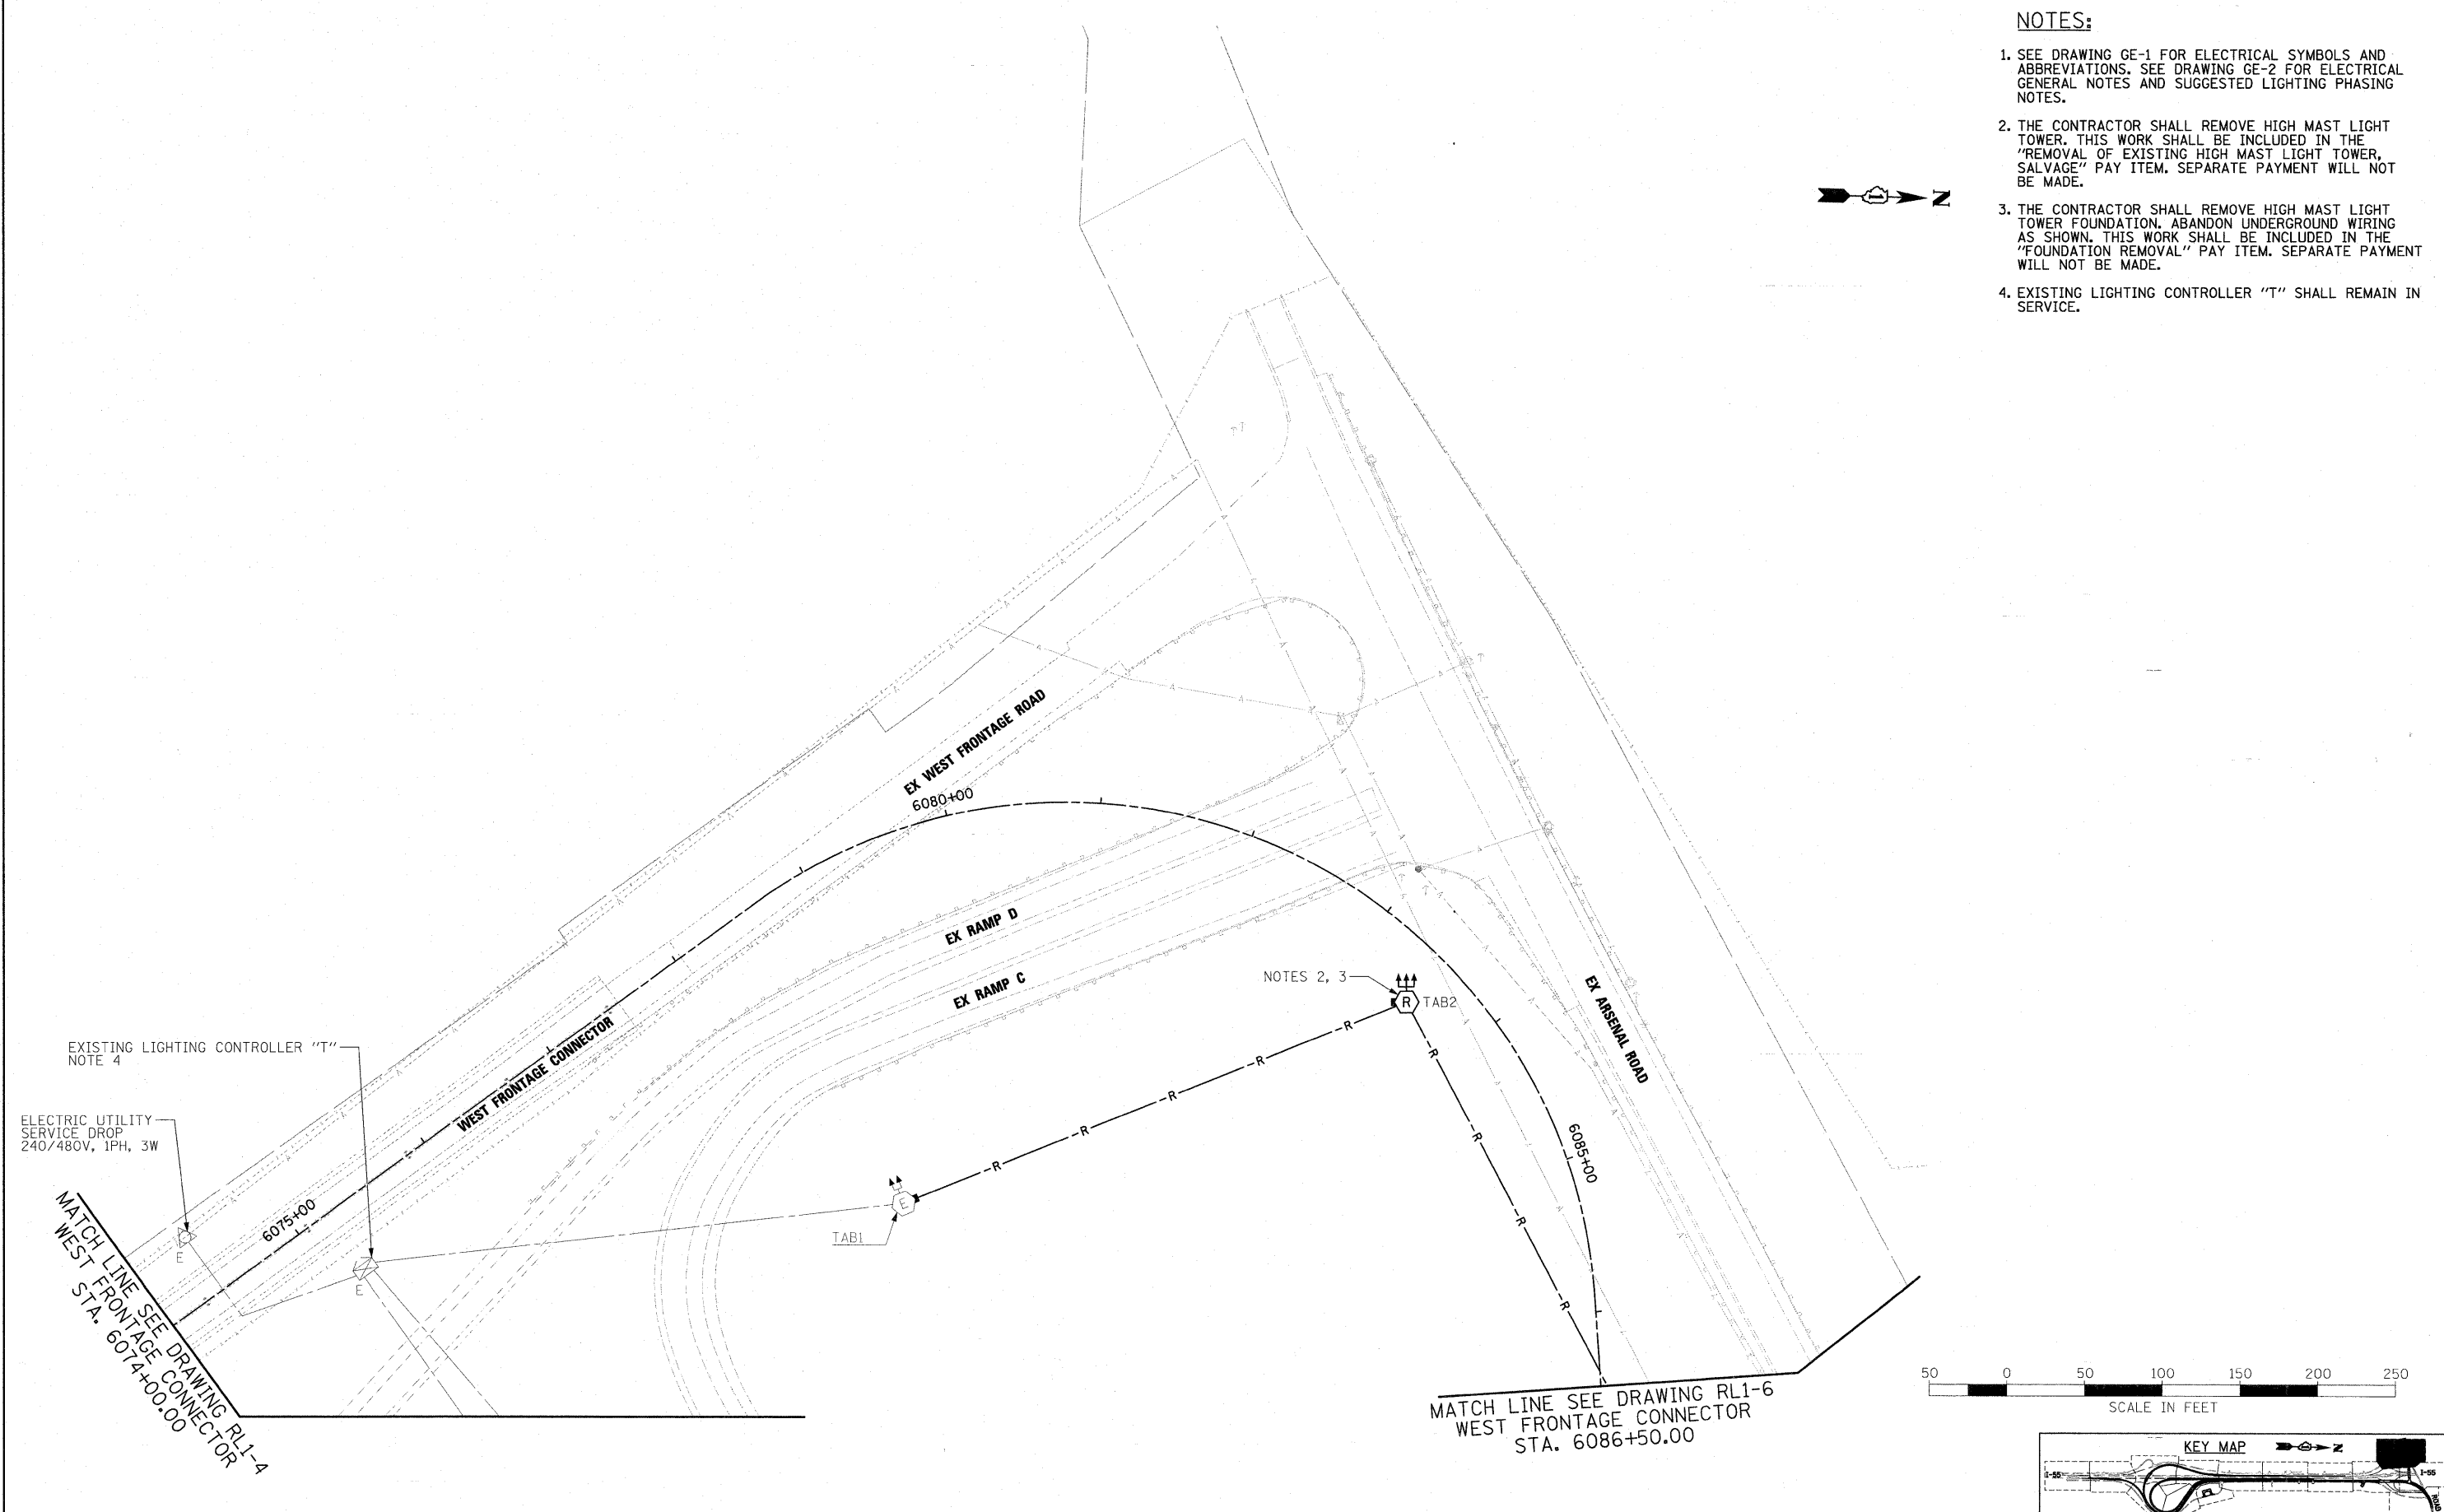

EXISTING LIGHTING CONTROLLER "T"
NOTE 4

ELECTRIC UTILITY
SERVICE DROP
240/480V, 1PH, 3W

MATCH LINE SEE DRAWING RL1-4
WEST FRONTAGE CONNECTOR
STA. 6074+00.00

NOTES 2, 3

MATCH LINE SEE DRAWING RL1-6
WEST FRONTAGE CONNECTOR
STA. 6086+50.00

McDonough Associates Inc.
 Engineers / Architects
 130 East Randolph Street Chicago, Illinois 60601

FILE NAME = D:\60\F12-SHT-RL1-5.dgn	USER NAME = TKluegel	DESIGNED - JLW	REVISED -
		DRAWN - CJM	REVISED -
	PLT SCALE = 1:50	CHECKED - KMY	REVISED -
	PLT DATE = 3/3/2011	DATE = 2/4/11	REVISED -

**STATE OF ILLINOIS
DEPARTMENT OF TRANSPORTATION**

**I-55 AT ARSENAL ROAD
PROPOSED ROADWAY LIGHTING PLAN-STAGE 1 DEMOLITION**

SCALE: 1" = 50' SHEET NO. 5 OF 10 SHEETS STA. TO STA.

F.A.I. RTE.	SECTION	COUNTY	TOTAL SHEETS	SHEET NO.
55	99-2HB-2B-1	WILL	756	353
CONTRACT NO. 60F12				
FED. ROAD DIST. NO. 1 ILLINOIS FED. AID PROJECT				