




MATCH LINE SEE DRAWING RL2-5  
W. FRONTAGE CONN. 6021+00.00  
SB EXIT RAMP 2005+51.17

MATCH LINE SEE DRAWING RL2-9  
WEST FRONTAGE  
CONNECTOR 6035+50.00

MATCH LINE SEE DRAWING RL2-9  
ARSENAL RD 918+00.00


 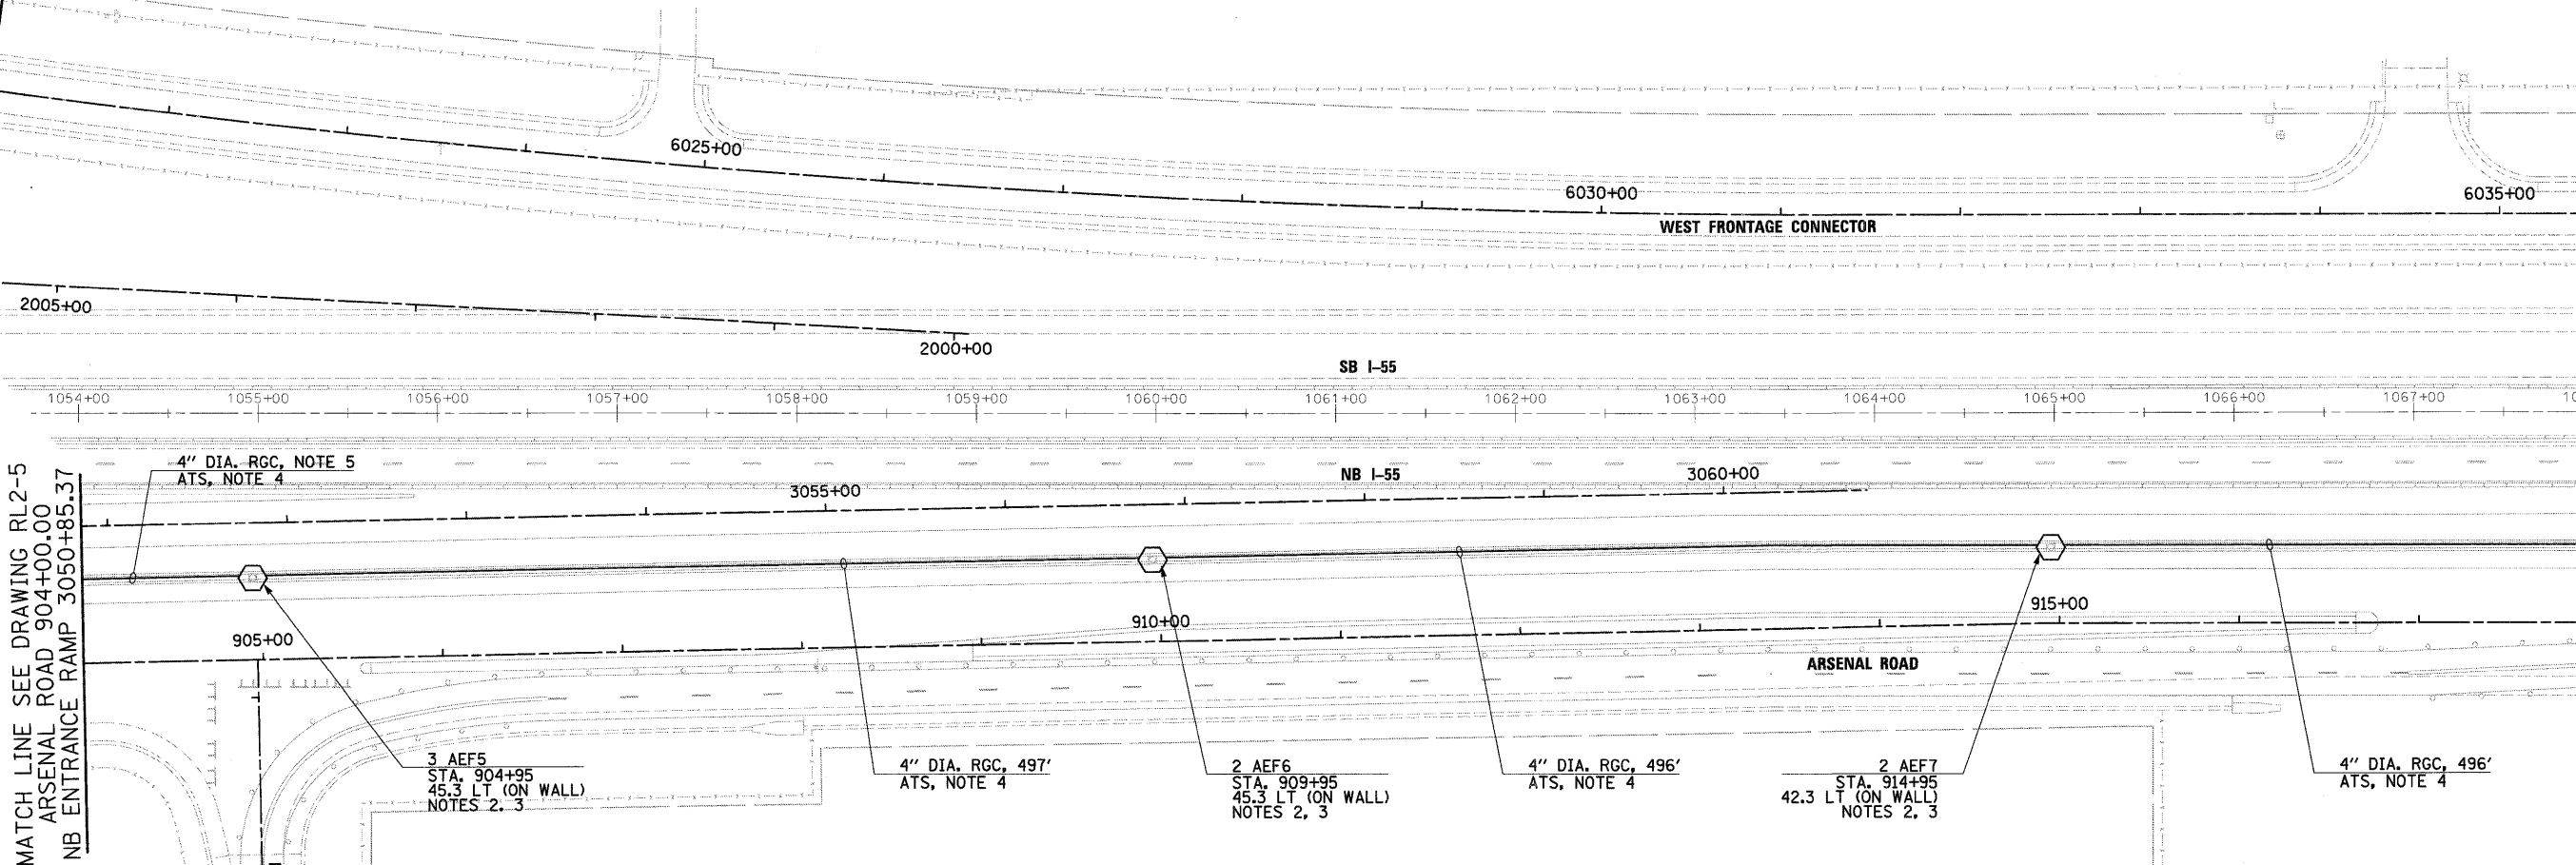


MATCH LINE SEE DRAWING RL2-5  
ARSENAL ROAD 904+00.00  
NB ENTRANCE RAMP 3050+85.37

MATCH LINE SEE DRAWING RL2-7  
EAST FRONTAGE RD 8056+00.00

**NOTES:**

1. SEE DRAWING GE-1 FOR ELECTRICAL SYMBOL LIST AND ABBREVIATIONS. SEE DRAWING GE-2 FOR ELECTRICAL GENERAL NOTES AND SUGGESTED LIGHTING PHASING NOTES.
2. WORK SHOWN ON THIS DRAWING WILL BE DONE IN STAGES 2, 3, AND 4. INSTALL CONDUITS AND GROUND ROD FOR EACH HIGH MAST TOWER LOCATED ALONG THE RETAINING WALL AS THE TOWER FOUNDATION IS BEING CONSTRUCTED. THIS WORK SHALL BE INCLUDED IN THE "LIGHT TOWER FOUNDATION, 54\" DIA." PAY ITEM. SEPARATE PAYMENT WILL NOT BE MADE.
3. SEE DRAWINGS S-1 AND ED-1 FOR HIGH MAST LIGHT TOWER FOUNDATIONS INTEGRAL WITH RETAINING WALL DETAILS.
4. PROVIDE 4\" RGS CONDUIT BETWEEN HIGH MAST TOWERS LOCATED ALONG THE RETAINING WALL AFTER RETAINING WALL IS CONSTRUCTED AND PRIOR TO CONSTRUCTION OF THE BARRIER WALL. CONDUIT SHALL BE ATTACHED TO THE EAST SIDE OF THE RETAINING WALL. PROVIDE WATERTIGHT SEAL AT CONDUIT OPENINGS. THIS WORK SHALL BE INCLUDED IN THE "CONDUIT ATTACHED TO STRUCTURE, 4\" DIA., GALVANIZED STEEL" PAY ITEM. SEPARATE PAYMENT WILL NOT BE MADE.
5. LENGTH NOT SHOWN. SEE DRAWING RL2-5 FOR RUN LENGTH.

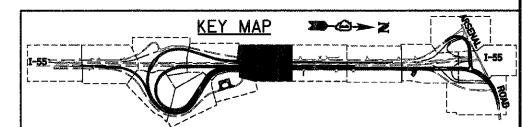

**McDonough Associates Inc.**  
Engineers / Architects  
130 East Randolph Street Chicago, Illinois 60601

FILE NAME = D:\62\F12-SHT-RL2-8.dgn	USER NAME = TKI\uegal	DESIGNED - JLW	REVISED -
		DRAWN - CJM	REVISED -
		CHECKED - KMY	REVISED -
		DATE - 2/4/11	REVISED -

**STATE OF ILLINOIS  
DEPARTMENT OF TRANSPORTATION**

**I-55 AT ARSENAL ROAD  
PROPOSED ROADWAY LIGHTING PLAN-STAGE 2**

SCALE: 1" = 50'    SHEET NO. 8 OF 12 SHEETS    STA.    TO STA.

F.A.I. RTE. 55	SECTION 99-2HB-2B-1	COUNTY WILL	TOTAL SHEETS 756	SHEET NO. 366
CONTRACT NO. 60F12				
FED. ROAD DIST. NO. 1   ILLINOIS   FED. AID PROJECT				