
 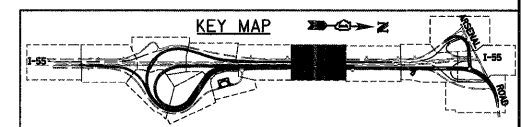


NOTES:

1. SEE DRAWING GE-1 FOR ELECTRICAL SYMBOL LIST AND ABBREVIATIONS. SEE DRAWING GE-2 FOR ELECTRICAL GENERAL NOTES AND SUGGESTED LIGHTING PHASING NOTES.
2. FURNISH AND INSTALL HIGH MAST LIGHT TOWER FOUNDATIONS SHOWN. INCLUDE GROUND WELLS, GROUND RODS, GROUND WIRE, ANCHOR BOLTS, AND LIGHT TOWER SERVICE PAD. SEE DRAWINGS S-2 THROUGH S-5, AND ED-9 FOR HIGH MAST LIGHT TOWER FOUNDATION DETAILS. EXCEPT FOR THE LIGHT TOWER SERVICE PAD, THIS WORK SHALL BE INCLUDED IN THE "LIGHT TOWER FOUNDATION, 54" DIAMETER" PAY ITEM.
3. SEE IDOT STANDARD DRAWINGS BE-505a, BE-505b, AND BE-505c FOR HIGH MAST LIGHT TOWER INSTALLATION DETAILS. THIS WORK SHALL BE INCLUDED IN "LIGHT TOWER, 120 FOOT MOUNTING HEIGHT, LUMINAIRE MT. - 12" PAY ITEM. SEPARATE PAYMENT WILL NOT BE MADE.
4. SEE STAGE 2 DRAWING RL2-9 FOR ADDITIONAL WORK ASSOCIATED WITH HIGH MAST TOWERS LOCATED ON RETAINING WALL.
5. INDICATES TEMPORARY PAVEMENT INSTALLATION LIMITS. SEE MAINTENANCE OF TRAFFIC DRAWINGS FOR CONSTRUCTION STAGING INFORMATION.
6. SEE DRAWING ED-2 FOR CONDUIT INSTALLATION DETAILS FOR GROUND MOUNTED HIGH MAST LIGHT TOWERS.



McDonough Associates Inc.
 Engineers / Architects
 130 East Randolph Street, Chicago, Illinois 60601

| | | | |
|--------------------------------------|---------------------|----------------|-----------|
| FILE NAME = 0162F12-SHT-RL3-6.dgn | USER NAME = TKIuse1 | DESIGNED - JLW | REVISED - |
| PLOT SCALE = 1:50 | CHECKED - KMY | DRAWN - CJM | REVISED - |
| PLOT DATE = 2/3/2011 | DATE - 2/4/11 | | REVISED - |

STATE OF ILLINOIS
DEPARTMENT OF TRANSPORTATION

| | |
|--|--------------------------|
| I-55 AT ARSENAL ROAD PROPOSED ROADWAY LIGHTING PLAN-STAGE 3 | |
| SCALE: 1" = 50' | SHEET NO. 6 OF 11 SHEETS |
| STA. | TO STA. |

| | | | | |
|--------------------|-------------|--------|---------------------------|-----------|
| F.A.I. RTE. | SECTION | COUNTY | TOTAL SHEETS | SHEET NO. |
| 55 | 99-2HB-2B-1 | WILL | 756 | 376 |
| CONTRACT NO. 60F12 | | | ILLINOIS FED. AID PROJECT | |