




MATCH LINE
SEE DRAWING RL3-10
ARSENAL RD STA. 970+50.00

MATCH LINE SEE DRAWING RL3-8

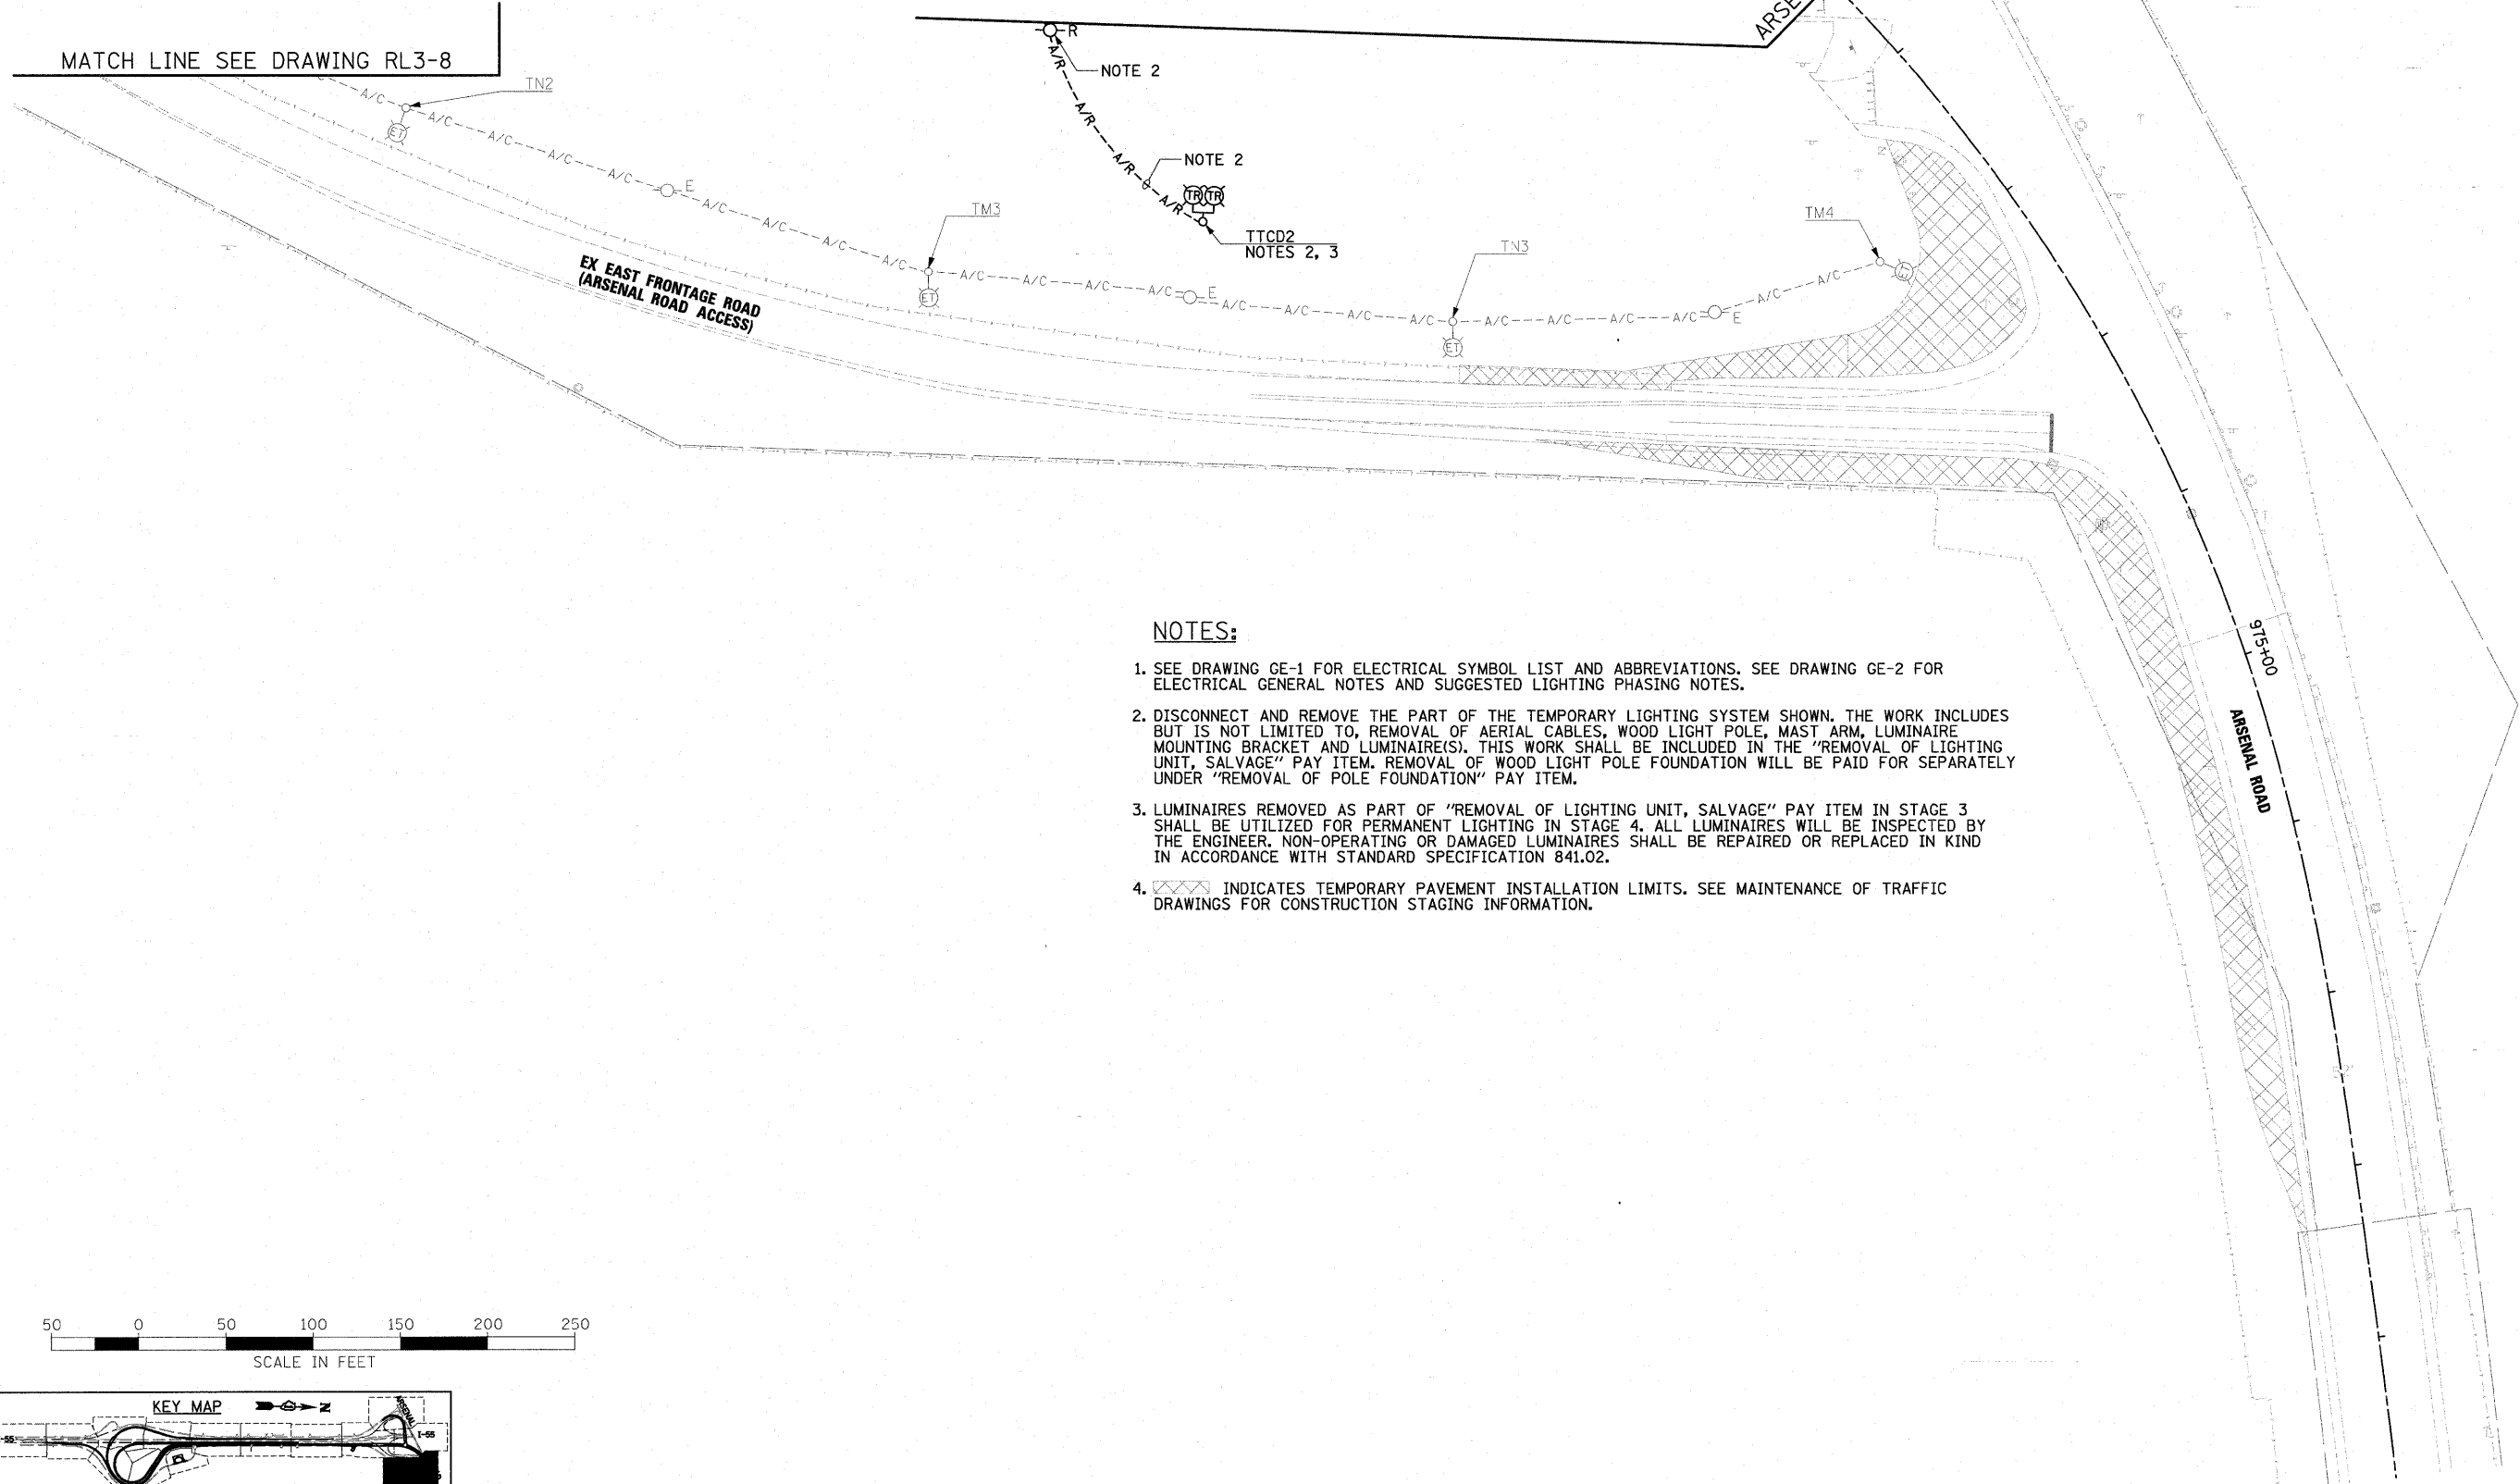

NOTES:

 1. SEE DRAWING GE-1 FOR ELECTRICAL SYMBOL LIST AND ABBREVIATIONS. SEE DRAWING GE-2 FOR ELECTRICAL GENERAL NOTES AND SUGGESTED LIGHTING PHASING NOTES.
2. DISCONNECT AND REMOVE THE PART OF THE TEMPORARY LIGHTING SYSTEM SHOWN. THE WORK INCLUDES BUT IS NOT LIMITED TO, REMOVAL OF AERIAL CABLES, WOOD LIGHT POLE, MAST ARM, LUMINAIRE MOUNTING BRACKET AND LUMINAIRE(S). THIS WORK SHALL BE INCLUDED IN THE "REMOVAL OF LIGHTING UNIT, SALVAGE" PAY ITEM. REMOVAL OF WOOD LIGHT POLE FOUNDATION WILL BE PAID FOR SEPARATELY UNDER "REMOVAL OF POLE FOUNDATION" PAY ITEM.
3. LUMINAIRES REMOVED AS PART OF "REMOVAL OF LIGHTING UNIT, SALVAGE" PAY ITEM IN STAGE 3 SHALL BE UTILIZED FOR PERMANENT LIGHTING IN STAGE 4. ALL LUMINAIRES WILL BE INSPECTED BY THE ENGINEER. NON-OPERATING OR DAMAGED LUMINAIRES SHALL BE REPAIRED OR REPLACED IN KIND IN ACCORDANCE WITH STANDARD SPECIFICATION 841.02.
4. INDICATES TEMPORARY PAVEMENT INSTALLATION LIMITS. SEE MAINTENANCE OF TRAFFIC DRAWINGS FOR CONSTRUCTION STAGING INFORMATION.

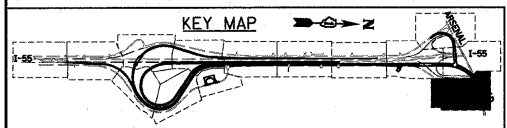

McDonough Associates Inc.
 Engineers / Architects
 130 East Randolph Street, Chicago, Illinois 60601

FILE NAME = D:\60F12-SHT-RL3-11.dgn	USER NAME = TKluugel	DESIGNED - JLW	REVISED -
		DRAWN - CJM	REVISED -
		CHECKED - KMY	REVISED -
		DATE - 2/4/11	REVISED -

STATE OF ILLINOIS
DEPARTMENT OF TRANSPORTATION

I-55 AT ARSENAL ROAD
PROPOSED ROADWAY LIGHTING PLAN-STAGE 3

SCALE: 1" = 50' SHEET NO. 11 OF 11 SHEETS STA. TO STA.

F.A.I. RTE.	SECTION	COUNTY	TOTAL SHEETS	SHEET NO.
55	99-2HB-2B-1	WILL	756	381
FED. ROAD DIST. NO. 1 ILLINOIS FED. AID PROJECT			CONTRACT NO. 60F12	