

MATCH LINE SEE DRAWING RL4-2 WEST FRONTAGE CONNECTOR 6035+50.00

MATCH LINE SEE DRAWING RL4-2 ARSENAL RD 918+00.00

MATCH LINE SEE DRAWING RL4-4 WEST FRONTAGE CONNECTOR 6050+00.00

MATCH LINE SEE DRAWING RL4-4 ARSENAL RD 932+50.00

2 TEF8
STA. 919+95
42.3 LT. (ON WALL)
NOTES 2, 3, 4
4" DIA. RGC, NOTE 7
ATS, NOTES 2, 3, 5, 6

E&F: 3*2 & 1*4 GND. ECA
4" DIA. RGC, 496'
ATS, NOTES 2, 3, 5

2 TEF7
STA. 924+95
42.3 LT. (ON WALL)
NOTES 2, 3, 4


 
E&F: 3*2 & 1*4 GND. ECA
4" DIA. RGC, 496'
ATS, NOTES 2, 3, 5

2 TEF6
STA. 929+95
42.3 LT. (ON WALL)
NOTES 2, 3, 4

E&F: 3*2 & 1*4 GND. ECA
4" DIA. RGC, 496'
ATS, NOTES 2, 3, 5

NOTES:

1. SEE DRAWING GE-1 FOR ELECTRICAL SYMBOL LIST AND ABBREVIATIONS. SEE DRAWING GE-2 FOR ELECTRICAL GENERAL NOTES AND SUGGESTED LIGHTING PHASING NOTES.
2. SEE DRAWINGS RL2-9 AND RL3-6 FOR ADDITIONAL WORK ASSOCIATED WITH WALL MOUNTED LIGHT TOWER FOUNDATIONS AND CONDUIT INSTALLATION.
3. SEE DRAWINGS S-1 AND ED-1 FOR HIGH MAST LIGHT TOWER FOUNDATIONS INTEGRAL WITH RETAINING WALL DETAILS.
4. SEE IDOT STANDARD DRAWINGS BE-505a, BE-505b, AND BE-505c FOR HIGH MAST LIGHT TOWER INSTALLATION DETAILS. THIS WORK SHALL BE INCLUDED IN "LIGHT TOWER, 120 FOOT MOUNTING HEIGHT, LUMINAIRE MT. - 12" PAY ITEM. SEPARATE PAYMENT WILL NOT BE MADE.
5. CONDUIT PREVIOUSLY INSTALLED IN STAGE 2 AS SHOWN ON DRAWING RL2-9. NO ADDITIONAL PAYMENT WILL BE MADE.
6. SPARE CONDUIT ATTACHED TO RETAINING WALL BETWEEN TOWERS 2 AEF7, SHOWN ON DRAWING RL4-2, AND 2 TEF8. CONDUIT OPENINGS TO RETAIN WATERTIGHT SEAL AFTER INSTALLATION OF HIGH MAST TOWERS ON RETAINING WALL.
7. LENGTH NOT SHOWN. SEE DRAWING RL4-2 FOR RUN LENGTH.

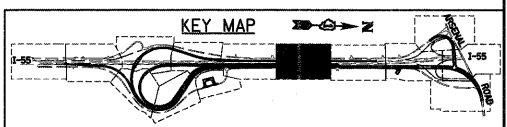

McDonough Associates Inc.
Engineers / Architects
130 East Randolph Street Chicago, Illinois 60601

FILE NAME = 0160F12-SHT-RL4-3.dgn	USER NAME = TKluegel	DESIGNED - JLW	REVISED -
PLOT SCALE = 1:50	CHECKED - KMY	DRAWN - CJM	REVISED -
PLOT DATE = 2/3/2011	DATE - 2/4/11	CHECKED -	REVISED -

**STATE OF ILLINOIS
DEPARTMENT OF TRANSPORTATION**

**I-55 AT ARSENAL ROAD
PROPOSED ROADWAY LIGHTING PLAN-STAGE 4**

SCALE: 1" = 50' SHEET NO. 3 OF 8 SHEETS STA. TO STA.

F.A.I. RTE. 55	SECTION 99-2HB-2B-1	COUNTY WILL	TOTAL SHEETS 756	SHEET NO. 384
CONTRACT NO. 60F12			FED. ROAD DIST. NO. 1 (ILLINOIS) FED. AID PROJECT	