
 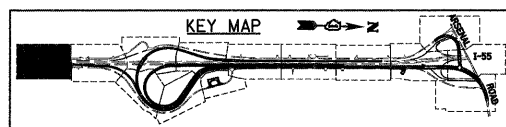


MATCH LINE SEE DRAWING RL-2
WEST FRONTAGE RD 5002+10.00
SB ENTRANCE RAMP 4021+8.63

MATCH LINE SEE DRAWING RL-2
EAST FRONTAGE RD 8005+50.00
NB I-55 EXIT 7000+16.15

NOTES:

1. SEE DRAWING GE-1 FOR ELECTRICAL SYMBOL LIST AND ABBREVIATIONS.
2. SEE DRAWING S-3 FOR HIGH MAST LIGHT TOWER FOUNDATION TABLE.



McDonough Associates Inc.
 Engineers / Architects
 130 East Randolph Street Chicago, Illinois 60601

FILE NAME = D168F12-SHT-RL-1.dgn	USER NAME = TKluegel	DESIGNED - JLW	REVISED -
		DRAWN - CJM	REVISED -
		CHECKED - KMY	REVISED -
		DATE - 2/4/11	REVISED -

STATE OF ILLINOIS
DEPARTMENT OF TRANSPORTATION

I-55 AT ARSENAL ROAD
PROPOSED ROADWAY LIGHTING PLAN FINAL CONDITIONS

SCALE: 1" = 50' SHEET NO. 1 OF 14 SHEETS STA. TO STA.

F.A.I. RTE. 55	SECTION 99-2HB-2B-1	COUNTY WILL	TOTAL SHEETS 756	SHEET NO. 390
CONTRACT NO. 60F12			ILLINOIS FED. AID PROJECT	