
 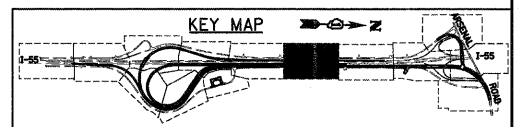


**NOTES:**

1. SEE DRAWING GE-1 FOR ELECTRICAL SYMBOL LIST AND ABBREVIATIONS.
2. SEE DRAWINGS S-1 AND S-3 FOR HIGH MAST LIGHT TOWER FOUNDATION TABLES.
3. LENGTH NOT SHOWN, SEE DRAWING RL-8 FOR RUN LENGTH.



**McDonough Associates Inc.**  
 Engineers / Architects  
 130 East Randolph Street, Chicago, Illinois 60601

FILE NAME = D:\60F12-SHT-RL-9.dgn	USER NAME = TKLuegel	DESIGNED - JLW	REVISED -
		DRAWN - CJM	REVISED -
		CHECKED - KMY	REVISED -
		DATE - 2/4/11	REVISED -

**STATE OF ILLINOIS**  
**DEPARTMENT OF TRANSPORTATION**

**I-55 AT ARSENAL ROAD**  
**PROPOSED ROADWAY LIGHTING PLAN FINAL CONDITIONS**

SCALE: 1" = 50'    SHEET NO. 9 OF 14 SHEETS    STA.    TO STA.

F.A.I. RTE. 55	SECTION 99-2HB-2B-1	COUNTY WILL	TOTAL SHEETS 756	SHEET NO. 398
CONTRACT NO. 60F12			ILLINOIS FED. AID PROJECT	