


EXISTING CONDITIONS AND REMOVAL

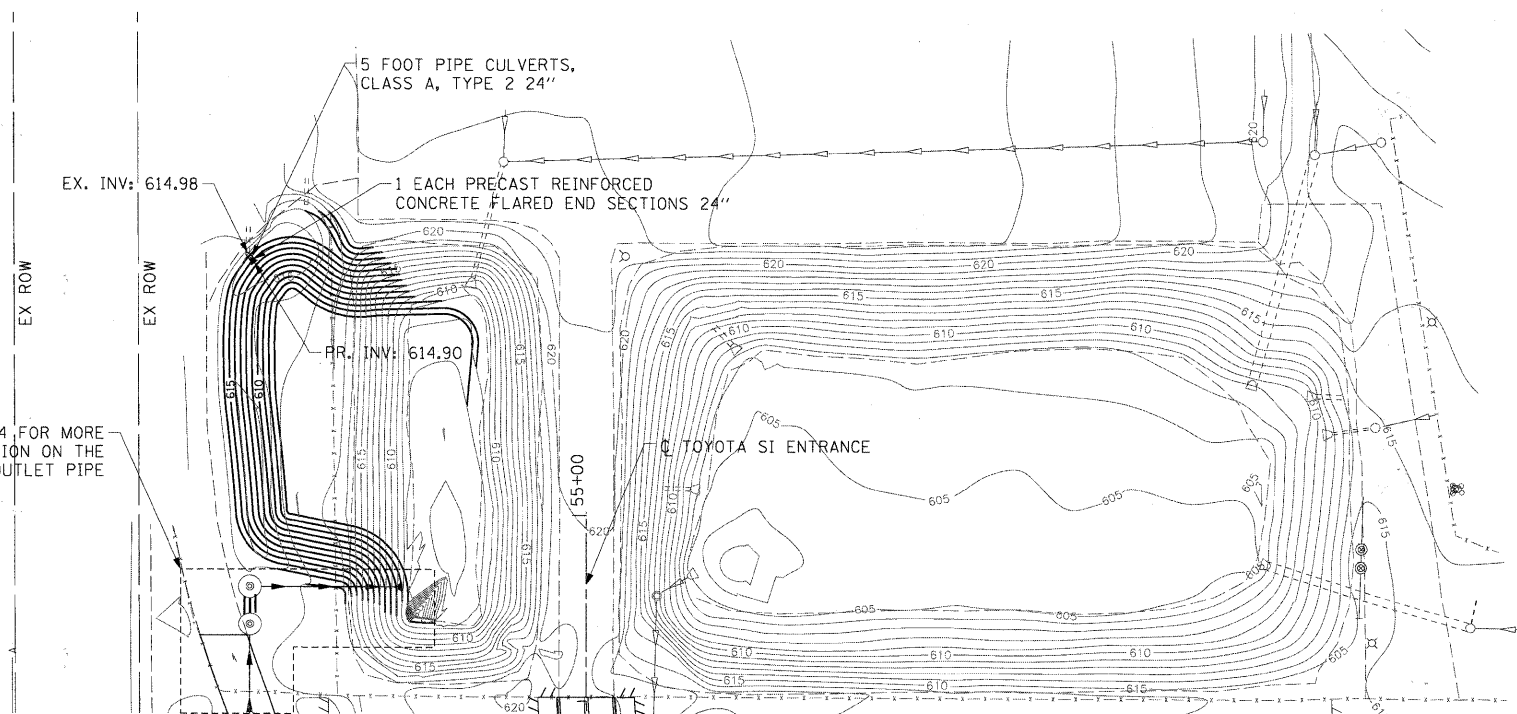

DRAINAGE AND UTILITY PLAN

SEE SHEETS 88-94 FOR MORE DETAILED INFORMATION ON THE PUMPING STATION AND OUTLET PIPE

FILE NAME = P:\60155877\002_CAD\001_Drawing\Sheets\Civil\60155877-ah-Drain-01.dgn



USER NAME = merrj	DESIGNED - KLK	REVISED -
PLOT SCALE = 50.000' / 1"	DRAWN - KLK	REVISED -
PLOT DATE = 2/17/2011	CHECKED - EY	REVISED -
DATE - FEBRUARY 17, 2011	REVISED -	REVISED -

STATE OF ILLINOIS
DEPARTMENT OF TRANSPORTATION

DRAINAGE AND UTILITY PLAN

SCALE: 1"=50' SHEET NO. 3 OF 3 SHEETS STA 25+00.00 TO STA 30+75.00

F.A.U. RTE.	SECTION	COUNTY	TOTAL SHEETS	SHEET NO.
1537	06-00050-00-GS	COOK	209	49
CONTRACT NO. 63556				
FED. ROAD DIST. NO. 1 ILLINOIS FED. AID PROJECT CRE-90031709				