


SECTION 24, TOWNSHIP 38, RANGE 12
SECTION 25, TOWNSHIP 38, RANGE 12

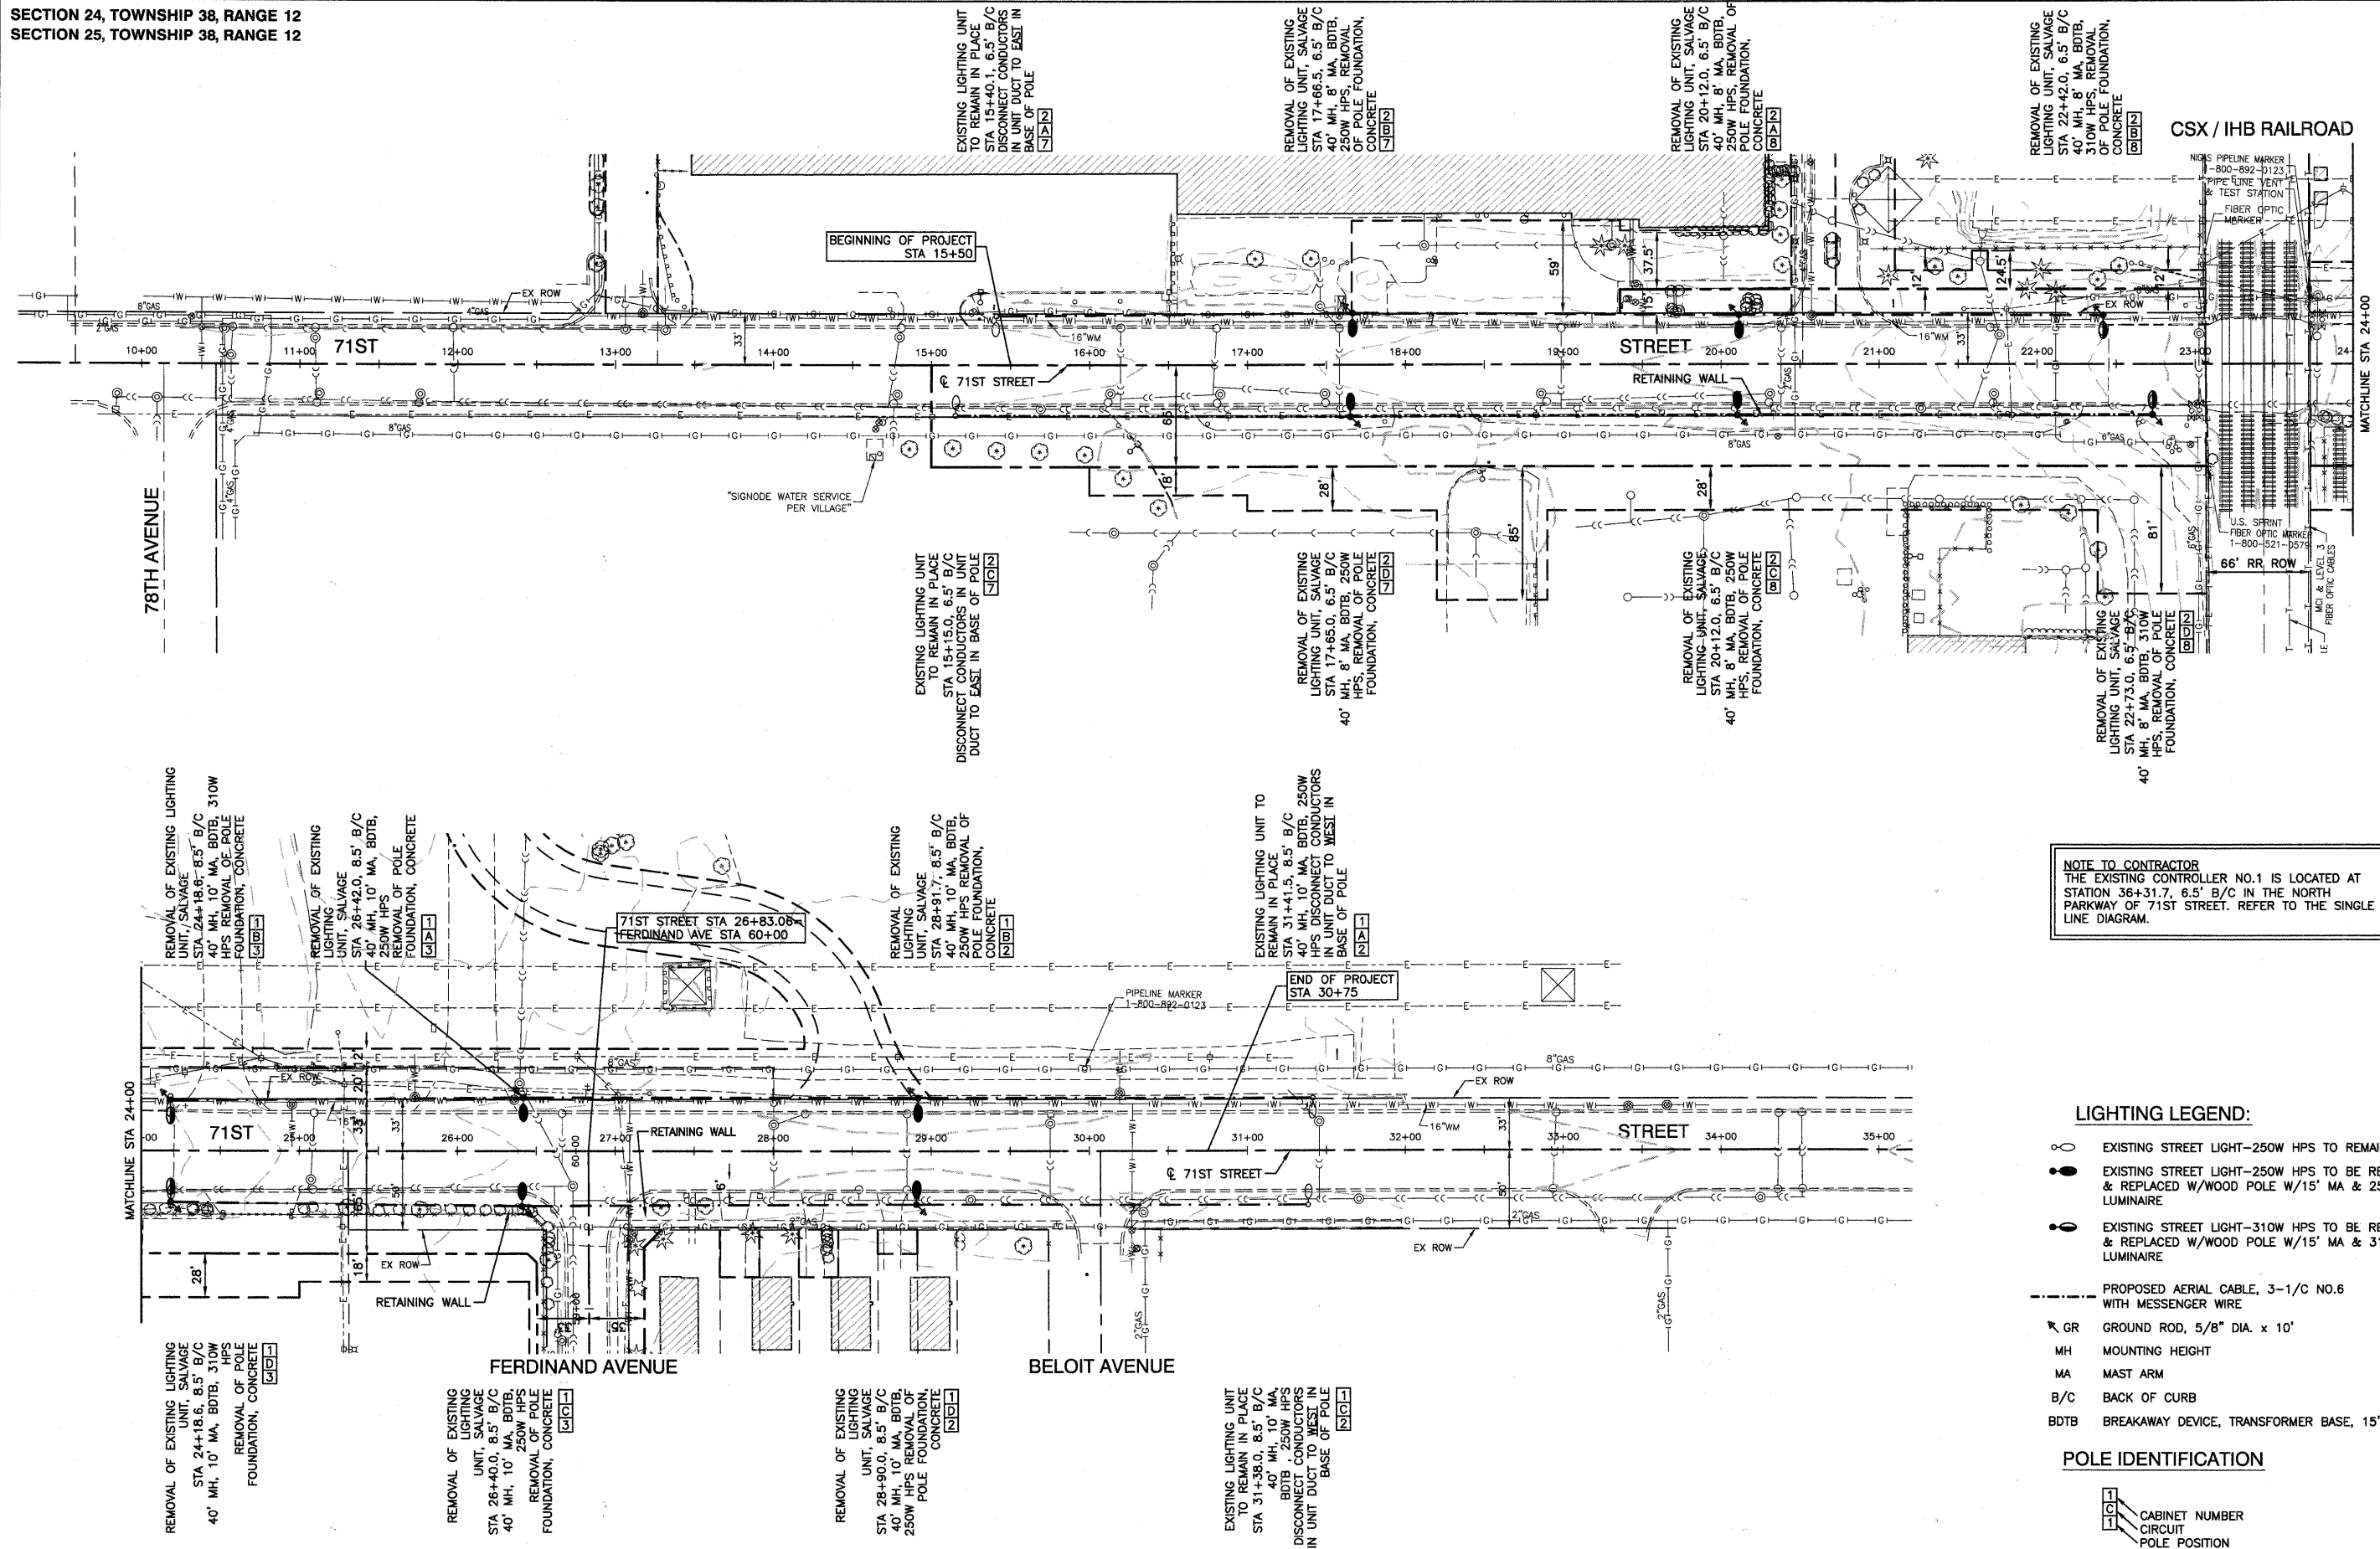

PLAN	SURVEYED	DATE
NOTE BOOK NO.	ALIGNED	
	RT. OF WAY CHECKED	
	ROAD FILE NAME	

PROFILE	SURVEYED	DATE
NOTE BOOK NO.	PLOTTED	
	B.M. NOTED	



NOTE TO CONTRACTOR
THE EXISTING CONTROLLER NO.1 IS LOCATED AT STATION 36+31.7, 6.5' B/C IN THE NORTH PARKWAY OF 71ST STREET. REFER TO THE SINGLE LINE DIAGRAM.

- LIGHTING LEGEND:**
- EXISTING STREET LIGHT—250W HPS TO REMAIN IN PLACE
 - EXISTING STREET LIGHT—250W HPS TO BE REMOVED & REPLACED W/WOOD POLE W/15' MA & 250 WATT HPS LUMINAIRE
 - EXISTING STREET LIGHT—310W HPS TO BE REMOVED & REPLACED W/WOOD POLE W/15' MA & 310 WATT HPS LUMINAIRE
 - PROPOSED AERIAL CABLE, 3-1/C NO.6 WITH MESSENGER WIRE
 - ✕ GR GROUND ROD, 5/8" DIA. x 10'
 - MH MOUNTING HEIGHT
 - MA MAST ARM
 - B/C BACK OF CURB
 - BDBT BREAKAWAY DEVICE, TRANSFORMER BASE, 15" BOLT CIRCLE

- POLE IDENTIFICATION**
- 1 CABINET NUMBER
 - 2 CIRCUIT
 - 3 POLE POSITION

FILE NAME = 09353-LGHT-01 - P01	USER NAME =	DESIGNED — PAP	REVISD —	STATE OF ILLINOIS DEPARTMENT OF TRANSPORTATION	71ST STREET EXISTING POLE REMOVAL/ TEMPORARY WOOD POLE LOCATION STREET LIGHTING	F.A.U. RTE. 1537	SECTION 06-00050-00-GS	COUNTY COOK	TOTAL SHEETS 209	SHEET NO. 79		
	PLOT SCALE =	CHECKED — DWS	REVISD —			SCALE: 1"=50'	SHEET NO. 79 OF 209 SHEETS	STA. 15+50	TO STA. 30+75	CONTRACT NO. 63556		
	PLOT DATE = 12/23/10	CHECKED — AG	REVISD —			FED. ROAD DIST. NO. 1 ILLINOIS FED. AID PROJECT CRE-9003(709)						