


EXISTING DRAINAGE LEGEND

- [A] MANHOLE TO BE ADJUSTED
- [R] REMOVING CATCH BASINS
- [F] FILLING CATCH BASINS

NOTE: **X X X** DRAINAGE PIPE OR PAVED DITCH REMOVAL
 REMOVAL OF EXISTING END SECTIONS AND CONCRETE HEADWALLS SHALL NOT BE MEASURE FOR PAYMENT, BUT SHALL BE CONSIDERED INCIDENTAL TO THE COST OF REMOVAL OF STORM SEWERS.

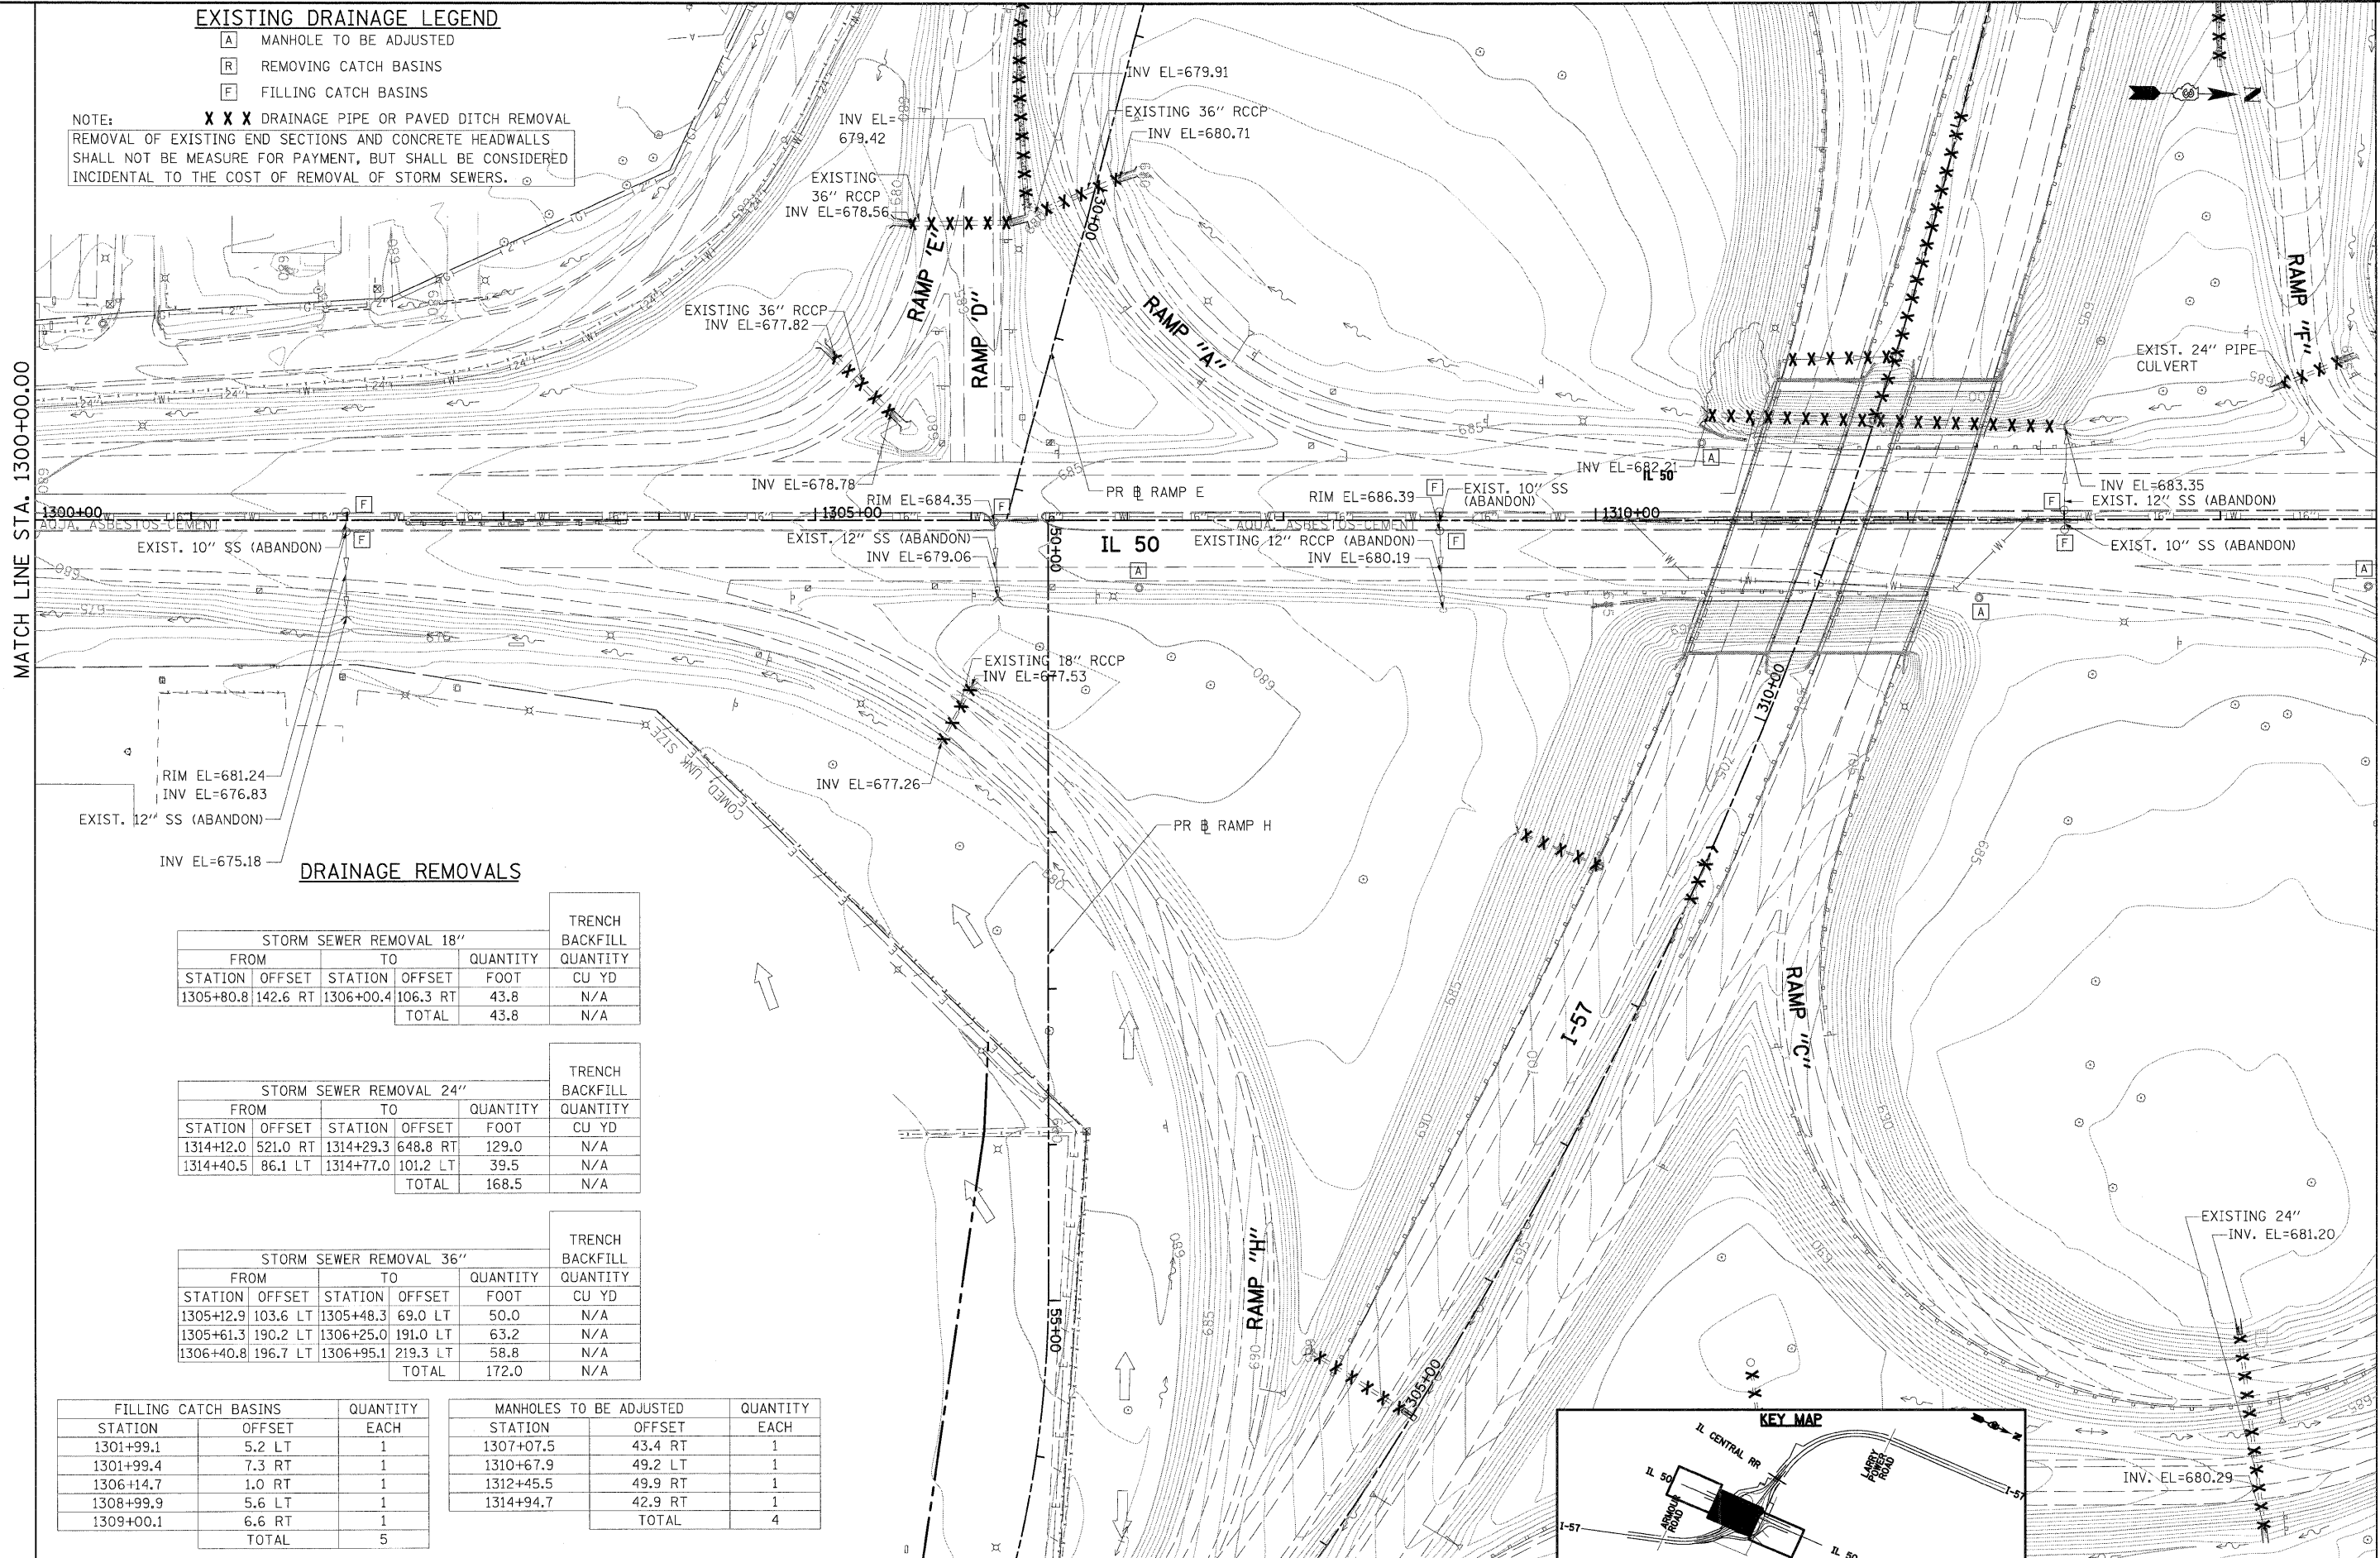

DRAINAGE REMOVALS


STORM SEWER REMOVAL 18"					TRENCH BACKFILL
FROM STATION	TO STATION	OFFSET	QUANTITY FOOT	QUANTITY CU YD	
1305+80.8	1306+00.4	142.6 RT	106.3 RT	43.8	N/A
TOTAL				43.8	N/A

STORM SEWER REMOVAL 24"					TRENCH BACKFILL
FROM STATION	TO STATION	OFFSET	QUANTITY FOOT	QUANTITY CU YD	
1314+12.0	1314+29.3	521.0 RT	648.8 RT	129.0	N/A
1314+40.5	1314+77.0	86.1 LT	101.2 LT	39.5	N/A
TOTAL				168.5	N/A

STORM SEWER REMOVAL 36"					TRENCH BACKFILL
FROM STATION	TO STATION	OFFSET	QUANTITY FOOT	QUANTITY CU YD	
1305+12.9	1305+48.3	103.6 LT	69.0 LT	50.0	N/A
1305+61.3	1306+25.0	190.2 LT	191.0 LT	63.2	N/A
1306+40.8	1306+95.1	196.7 LT	219.3 LT	58.8	N/A
TOTAL				172.0	N/A

FILLING CATCH BASINS			QUANTITY EACH
STATION	OFFSET	QUANTITY	QUANTITY
1301+99.1	5.2 LT	1	
1301+99.4	7.3 RT	1	
1306+14.7	1.0 RT	1	
1308+99.9	5.6 LT	1	
1309+00.1	6.6 RT	1	
TOTAL			5

MANHOLES TO BE ADJUSTED			QUANTITY EACH
STATION	OFFSET	QUANTITY	QUANTITY
1307+07.5	43.4 RT	1	
1310+67.9	49.2 LT	1	
1312+45.5	49.9 RT	1	
1314+94.7	42.9 RT	1	
TOTAL			4

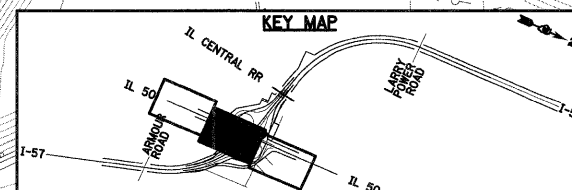

FILE NAME = I:\09\1\sheet\du08.dgn
 PLOT SCALE = 1:150
 PLOT DATE = 12/22/2010

USER NAME = EricG
 DESIGNED - JWM
 DRAWN - JWM
 CHECKED - EJG
 DATE - 12/17/10

REVISED -
 REVISED -
 REVISED -
 REVISED -

**STATE OF ILLINOIS
 DEPARTMENT OF TRANSPORTATION**

EXISTING DRAINAGE AND UTILITY PLAN
 SCALE: SHEET NO. OF SHEETS STA. TO STA.

F.A.I. RTE.	SECTION	COUNTY	TOTAL SHEETS	SHEET NO.
57	(46-2) I, HBR, VBR	KANKAKEE	558	140
CONTRACT NO. 66409			FED. ROAD DIST. NO. 3 ILLINOIS FED. AID PROJECT	