



PLAN	DESIGNED	BY	DATE
	PLOTTED		
	GRADES CHECKED		
	STRUCTURE NOTATIONS CHECKED		
	NOTE BOOK NO.		
	CADD FILE NAME		

PROFILE	DESIGNED	BY	DATE
	PLOTTED		
	GRADES CHECKED		
	STRUCTURE NOTATIONS CHECKED		
	NOTE BOOK NO.		
	CADD FILE NAME		

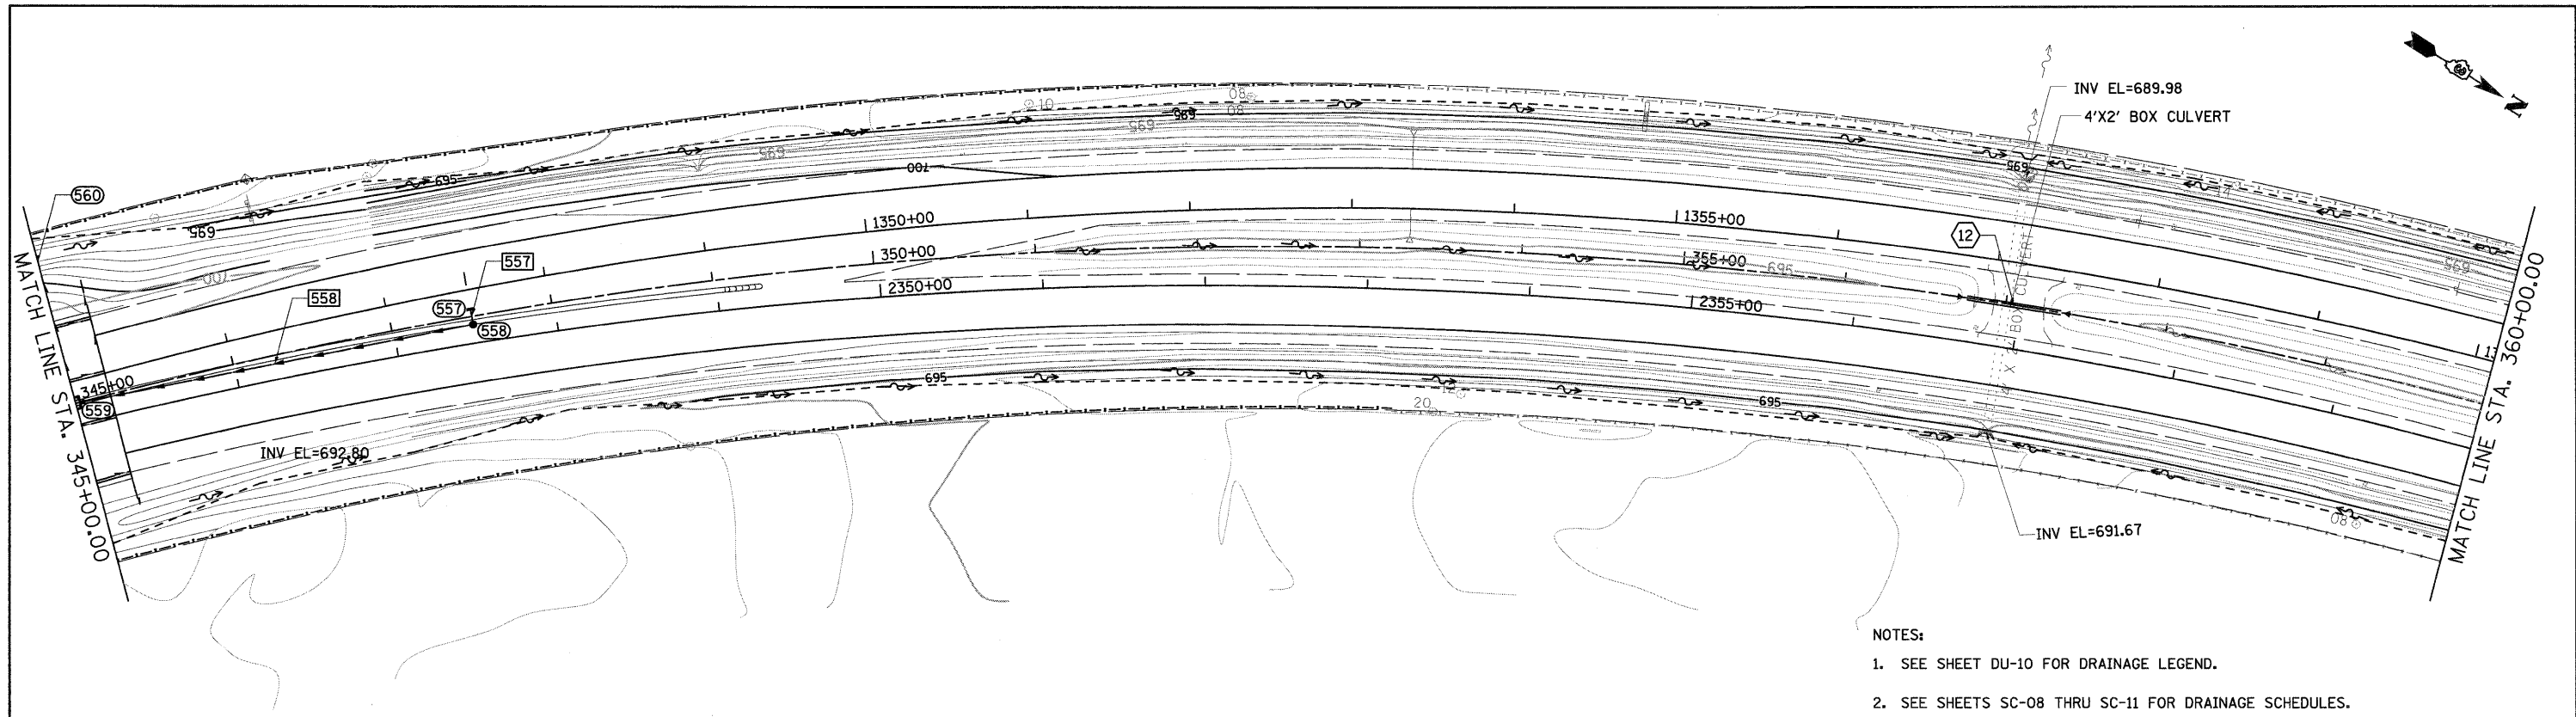

- NOTES:
- SEE SHEET DU-10 FOR DRAINAGE LEGEND.
 - SEE SHEETS SC-08 THRU SC-11 FOR DRAINAGE SCHEDULES.

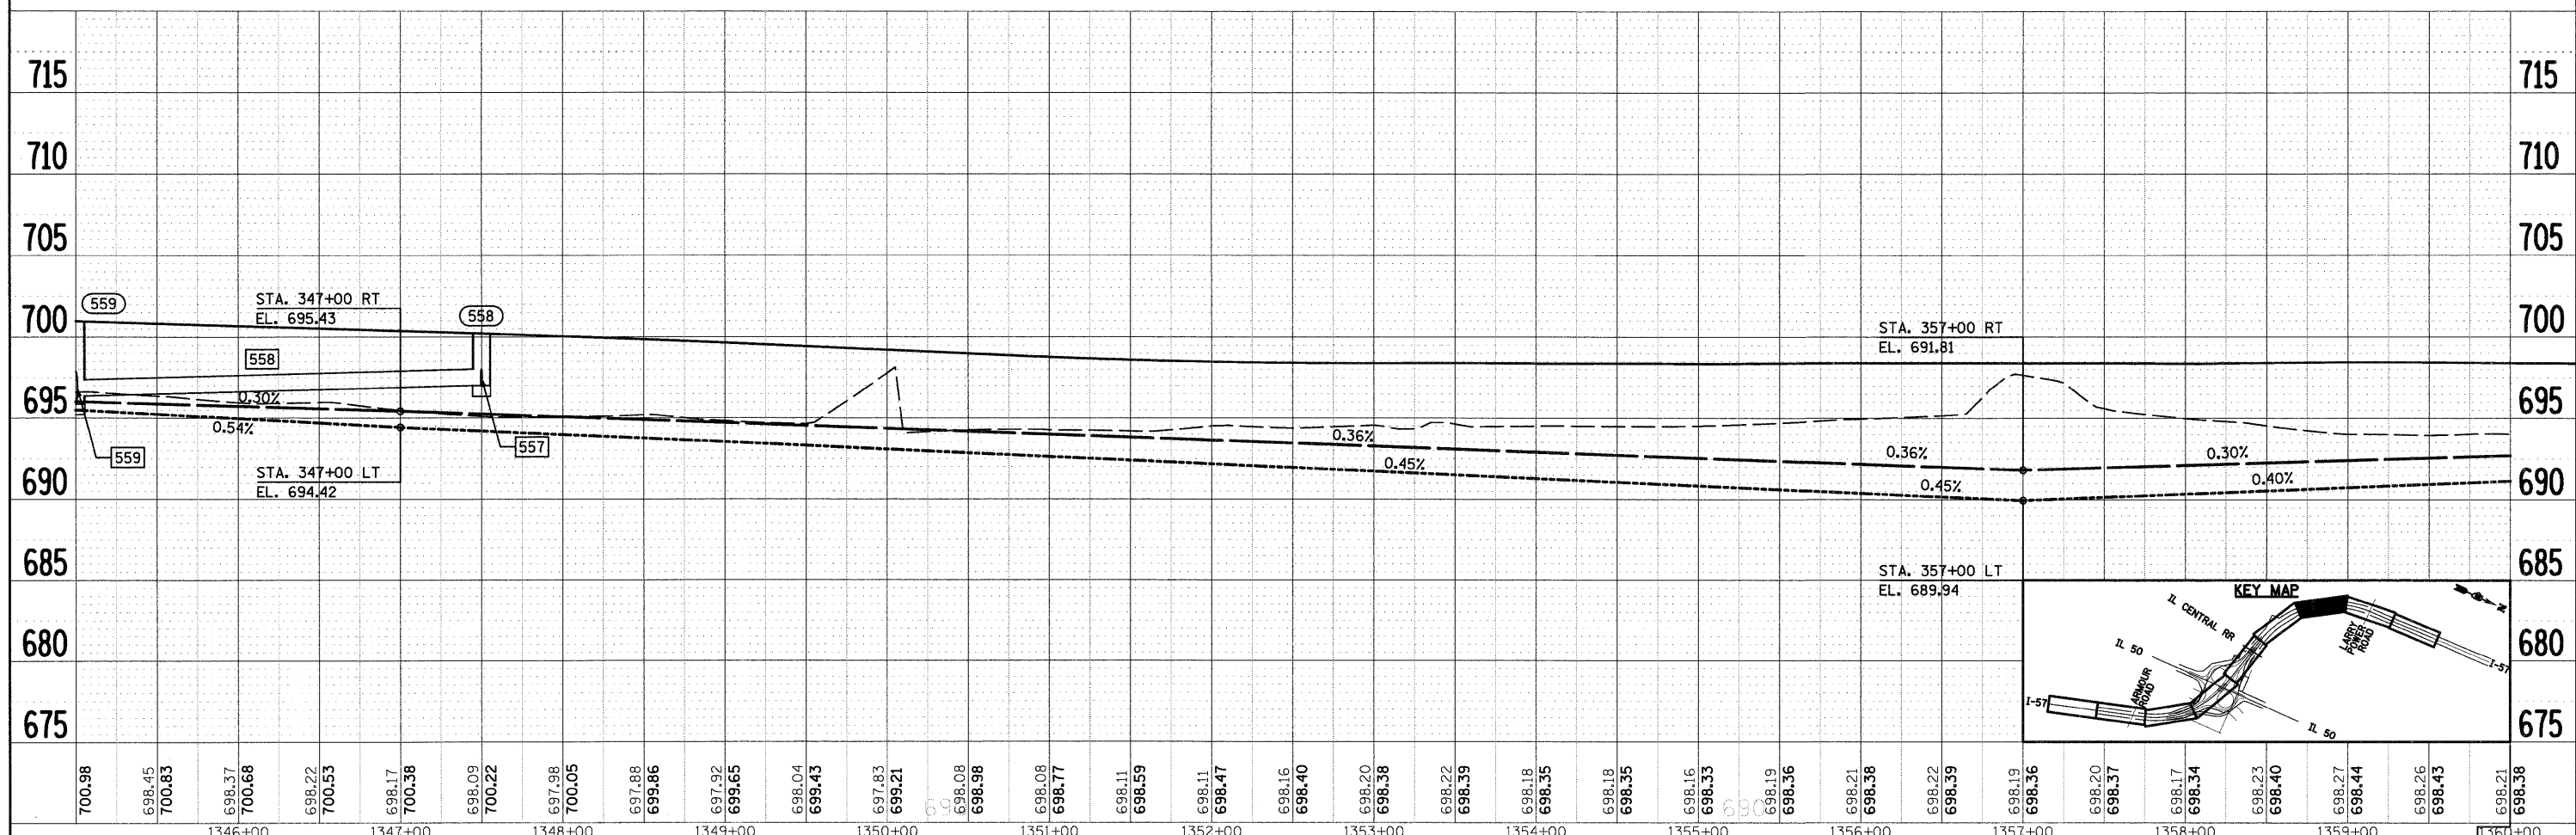

FILE NAME = I:\Dgn\sheets\du16.dgn	USER NAME = E-jcg	DESIGNED - JWM	REVISED -	STATE OF ILLINOIS DEPARTMENT OF TRANSPORTATION	I-57 PROPOSED DRAINAGE PLAN AND PROFILE	F.A.I. RTE. = 57	SECTION = (46-2) I, HBR, VBR	COUNTY = KANKAKEE	TOTAL SHEETS = 558	SHEET NO. = 148	
	PLOT SCALE = 1:50	DRAWN - JWM	REVISED -			SCALE:	SHEET NO. OF SHEETS	STA. TO STA.	FED. ROAD DIST. NO. 3 ILLINOIS FED. AID PROJECT		
	PLOT DATE = 12/22/2010	CHECKED - EUG	REVISED -						CONTRACT NO. 66409		
		DATE - 12/17/10	REVISED -								