


MATCH LINE B-B
SEE SHEET LI-7

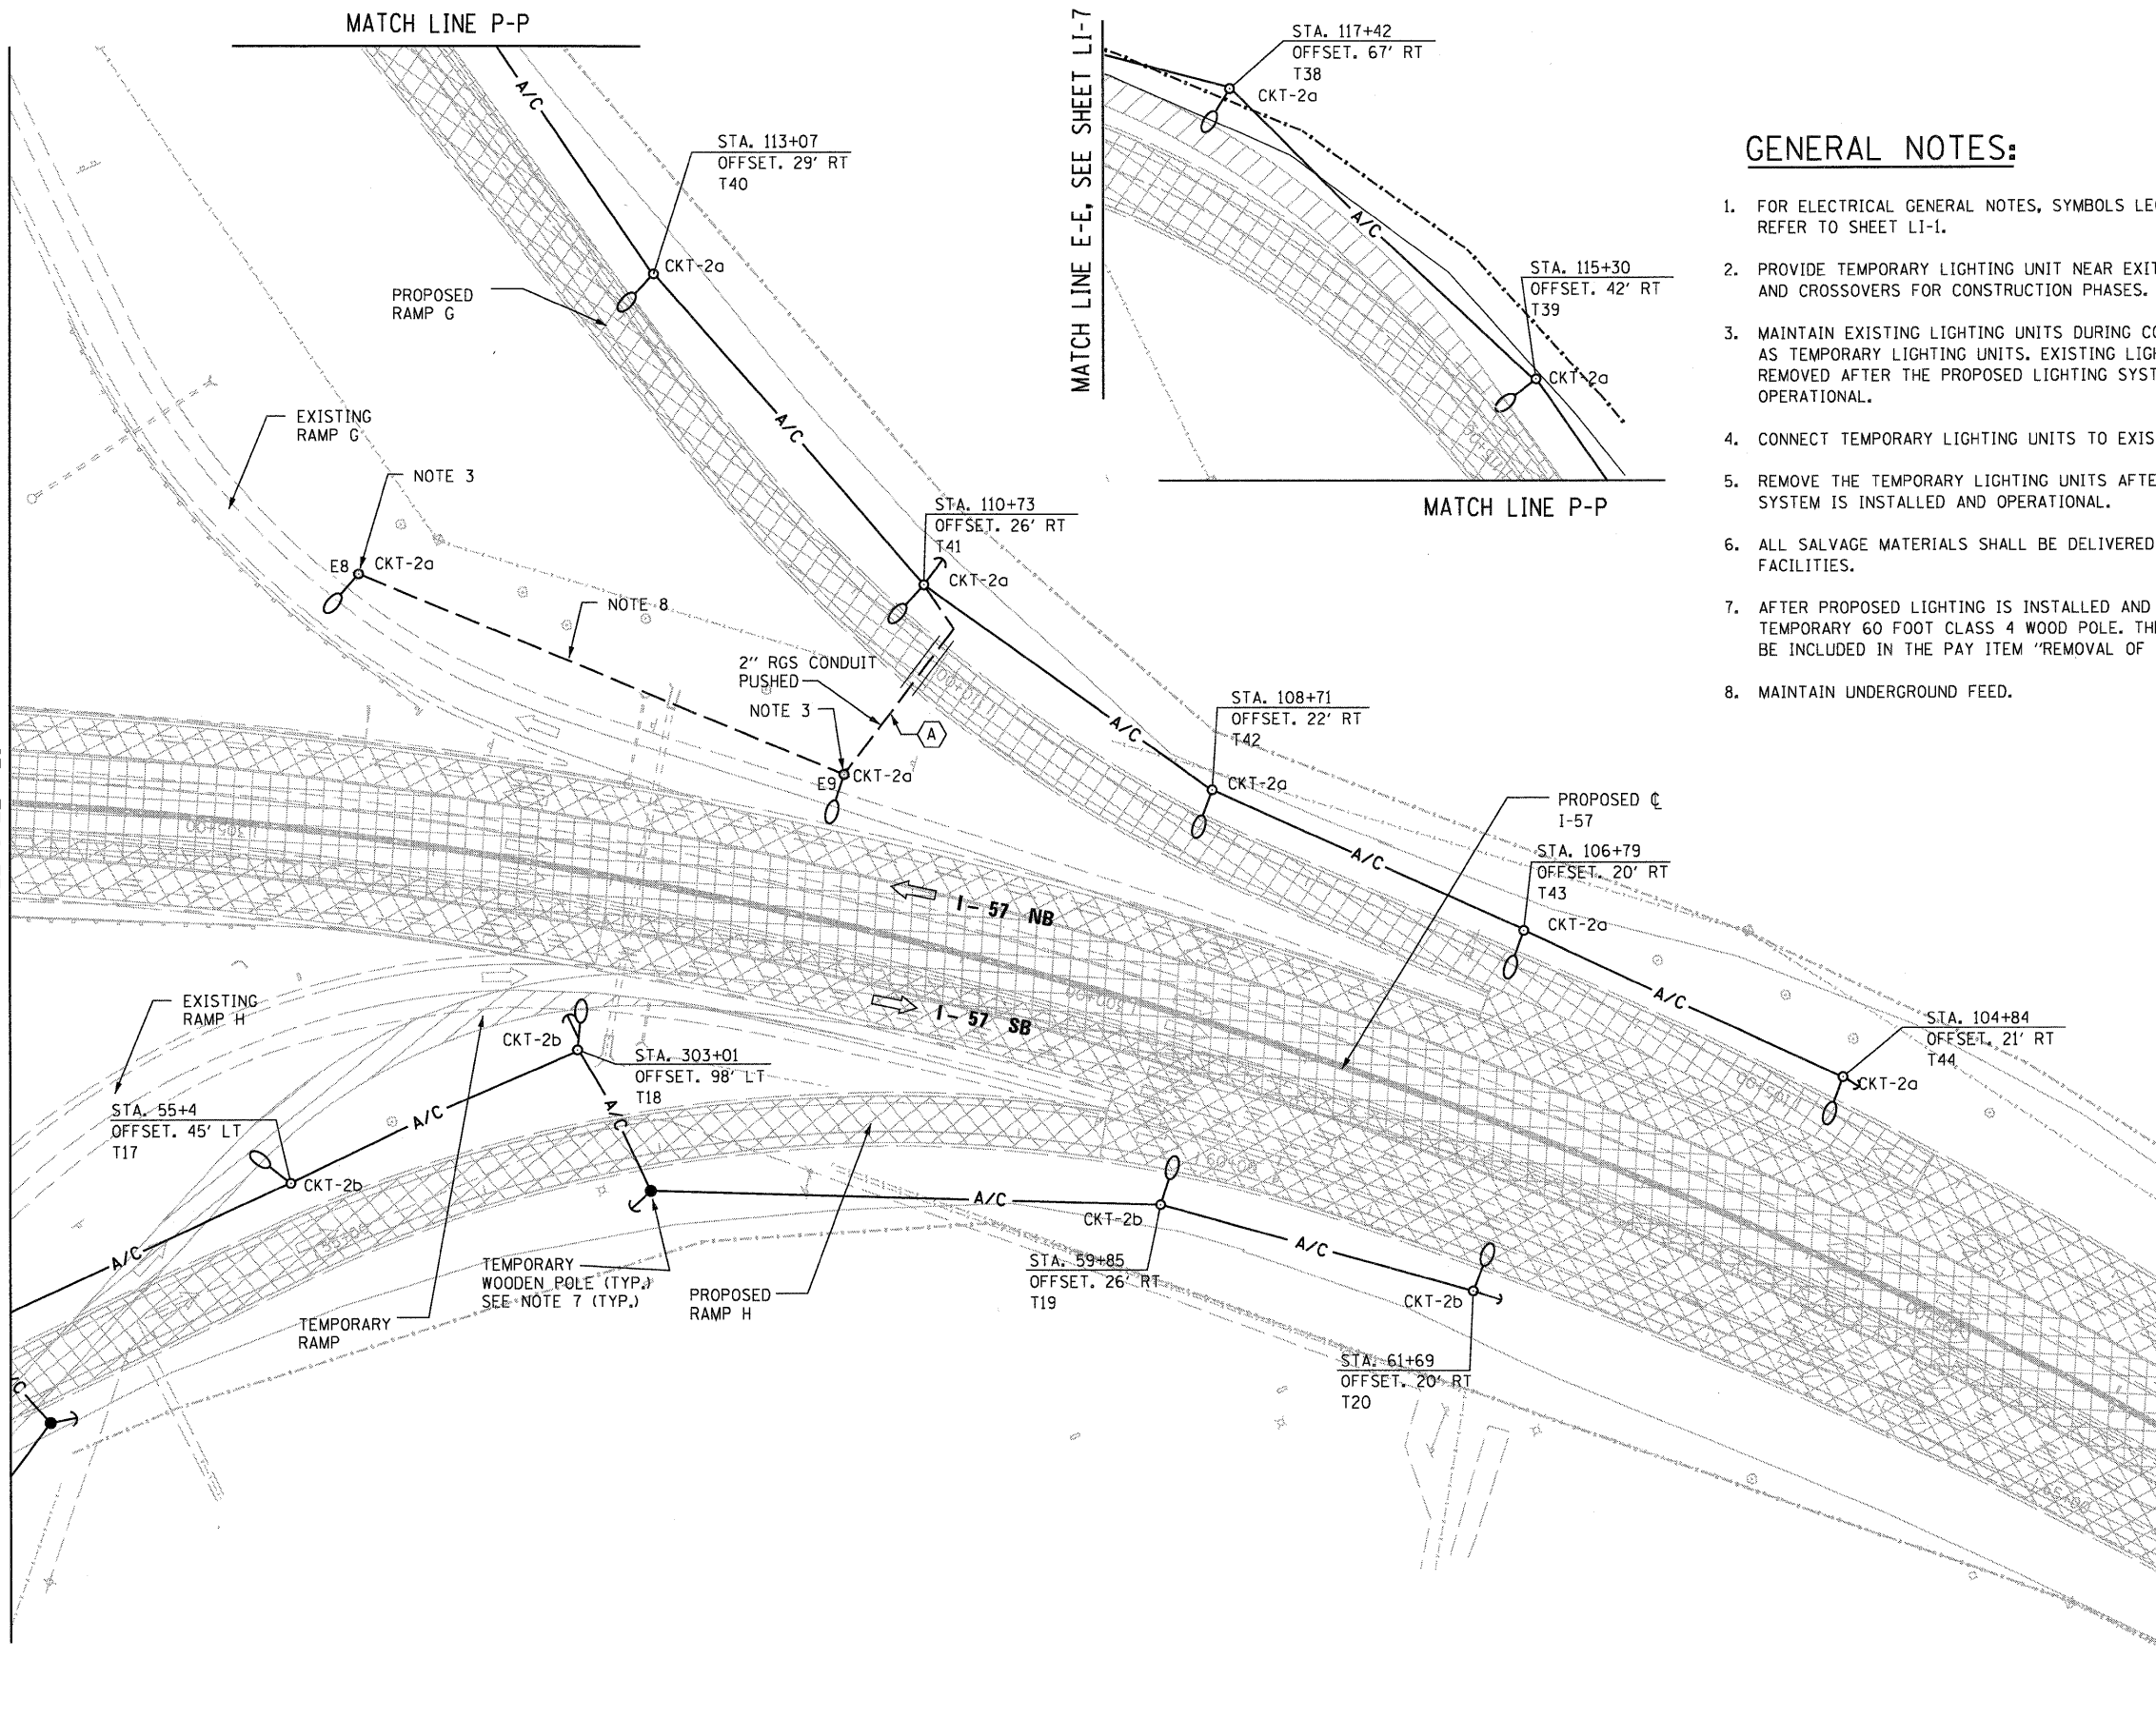

MATCH LINE E-E, SEE SHEET LI-7

GENERAL NOTES:

1. FOR ELECTRICAL GENERAL NOTES, SYMBOLS LEGEND AND ABBREVIATIONS REFER TO SHEET LI-1.
2. PROVIDE TEMPORARY LIGHTING UNIT NEAR EXIT/ENTRANCE OF RAMPS AND CROSSOVERS FOR CONSTRUCTION PHASES.
3. MAINTAIN EXISTING LIGHTING UNITS DURING CONSTRUCTION PHASES AS TEMPORARY LIGHTING UNITS. EXISTING LIGHTING UNITS TO BE REMOVED AFTER THE PROPOSED LIGHTING SYSTEM IS INSTALLED AND OPERATIONAL.
4. CONNECT TEMPORARY LIGHTING UNITS TO EXISTING LIGHTING SYSTEM.
5. REMOVE THE TEMPORARY LIGHTING UNITS AFTER THE PROPOSED LIGHTING SYSTEM IS INSTALLED AND OPERATIONAL.
6. ALL SALVAGE MATERIALS SHALL BE DELIVERED TO IDOT DISTRICT 3 STORAGE FACILITIES.
7. AFTER PROPOSED LIGHTING IS INSTALLED AND START FUNCTIONING, REMOVE TEMPORARY 60 FOOT CLASS 4 WOOD POLE. THE COST OF ITS REMOVAL SHALL BE INCLUDED IN THE PAY ITEM "REMOVAL OF TEMPORARY LIGHTING UNIT." (TYP.)
8. MAINTAIN UNDERGROUND FEED.



KEY PLAN

FILE NAME = g:\zd40403\LI-8.DGN	USER NAME = kghan	DESIGNED - HS	REVISED -	STATE OF ILLINOIS DEPARTMENT OF TRANSPORTATION	TEMPORARY LIGHTING PLAN I-57, RAMP "G" AND RAMP "H"			F.A.I. RTE. 57	SECTION (46-2) I, HBR, VBR	COUNTY KANKAKEE	TOTAL SHEETS 558	SHEET NO. 255
PLOT SCALE = 1:50	CHECKED - HS	DRAWN - KK	REVISED -		SCALE:	SHEET NO.	OF	SHEETS	STA.	TO	FED. ROAD DIST. NO. 3	ILLINOIS FED. AID PROJECT
PLOT DATE = 12/17/2010	DATE - 12-17-2010	CHECKED - HS	REVISED -		CONTRACT NO. 66409							
		DATE - 12-17-2010	REVISED -		CONTRACT NO. 66409							