
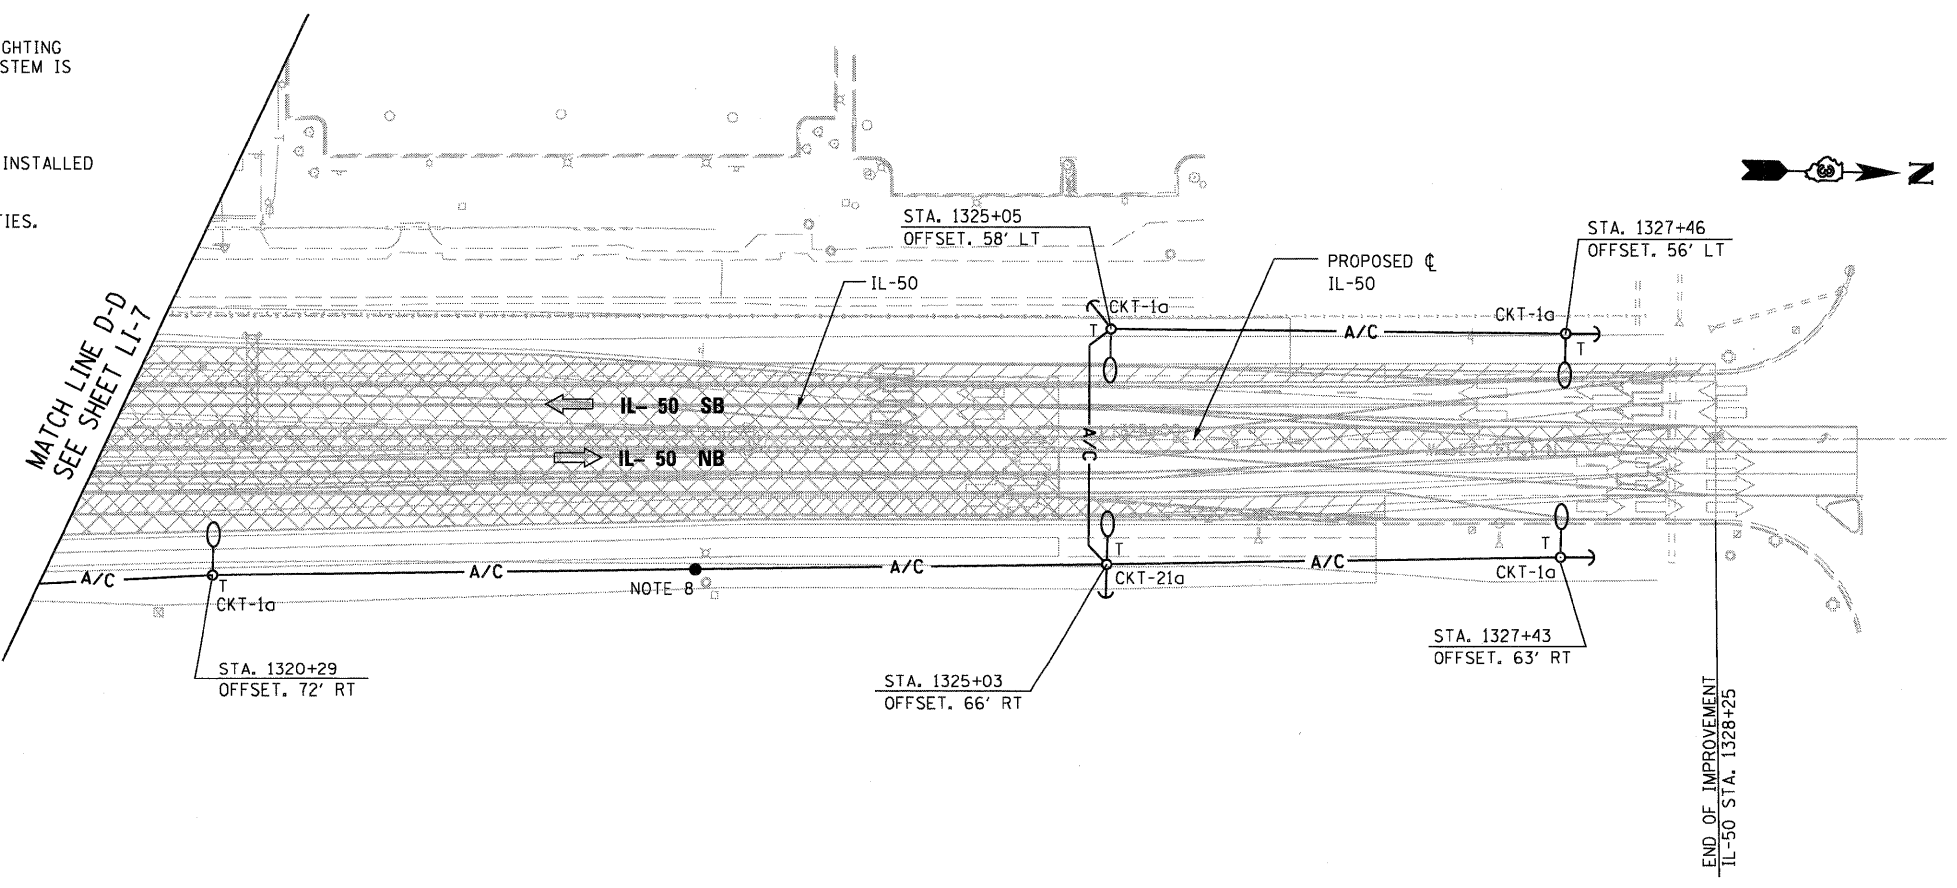


GENERAL NOTES:

1. FOR ELECTRICAL GENERAL NOTES, SYMBOLS LEGEND AND ABBREVIATIONS REFER TO SHEET LI-1.
2. PROVIDE TEMPORARY LIGHTING UNIT NEAR EXIT/ENTRANCE OF RAMP AND CROSSOVERS FOR CONSTRUCTION PHASES.
3. MAINTAIN EXISTING LIGHTING UNITS DURING CONSTRUCTION PHASES AS TEMPORARY LIGHTING UNITS. EXISTING LIGHTING UNITS TO BE REMOVED AFTER THE PROPOSED LIGHTING SYSTEM IS INSTALLED AND OPERATIONAL.
4. CONNECT TEMPORARY LIGHTING UNITS TO EXISTING LIGHTING SYSTEM.
5. REMOVE THE TEMPORARY LIGHTING UNITS AFTER THE PROPOSED LIGHTING SYSTEM IS INSTALLED AND OPERATIONAL.
6. ALL SALVAGE MATERIALS SHALL BE DELIVERED TO IDOT DISTRICT 3 STORAGE FACILITIES.
7. EXISTING LIGHTING NEAR THE INTERSECTION OF IL-50 AND ARMOUR ROAD SHALL BE MAINTAINED IN OPERATIONAL CONDITION. THESE LIGHTS ARE CONNECTED TO LIGHTING CONTROLLER AT ARMOUR ROAD AND IL-50 INTERSECTION.
8. AFTER PROPOSED LIGHTING IS INSTALLED AND START FUNCTIONING, REMOVE TEMPORARY 60 FOOT CLASS 4 WOOD POLE. THE COST OF ITS REMOVAL SHALL BE INCLUDED IN THE PAY ITEM "REMOVAL OF TEMPORARY LIGHTING UNIT."

LEGEND

E - EXISTING TO REMAIN

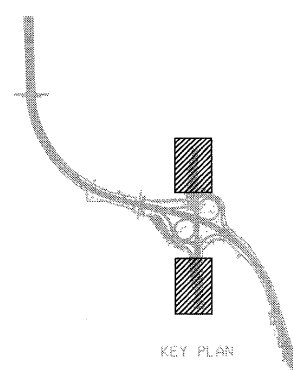

Delta Engineering, Inc.
 CONSULTING ENGINEERS, CONSTRUCTION MANAGERS, SURVEYORS
 111 West Jackson Blvd. Suite 910 Chicago, IL 60604-2001

| | | | | | | | | | | | | |
|------------------------------------|-------------------|---------------|-------------|---|--|---------------------|--------------|---|----------------------------|-----------------|------------------|---------------|
| FILE NAME = g:\zd40403\LI-9.DGN | USER NAME = kghan | DESIGNED - HS | REVISED - | STATE OF ILLINOIS DEPARTMENT OF TRANSPORTATION | TEMPORARY LIGHTING PLAN IL ROUTE 50 | | | F.A.I. RTE. 57 | SECTION (46-2) I, HBR, VBR | COUNTY KANKAKEE | TOTAL SHEETS 558 | SHEET NO. 256 |
| PLOT SCALE = 1:50 | CHECKED - HS | REVISOR - | REVISIONS - | | SCALE: | SHEET NO. OF SHEETS | STA. TO STA. | FED. ROAD DIST. NO. 3 ILLINOIS FED. AID PROJECT | | | | |
| PLOT DATE = 12/17/2010 | DATE - 12-17-2010 | REVISOR - | REVISIONS - | | | | | | | | | |
| CONTRACT NO. 66409 | | | | | | | | | | | | |