
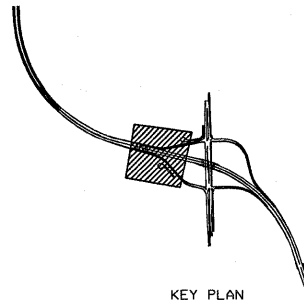


NOTES:

- FOR GENERAL NOTES, SYMBOLS LEGEND AND ABBREVIATIONS REFER TO SHEET LI-1.
- FOR TOWER LOCATION, TOWER LUMINAIRES SCHEDULE, LOAD TABLES, CABLE SCHEDULES AND VOLTAGE DROP TABLES, REFER TO SHEET LI-16.
- CONDUIT SHALL EXTEND NOT LESS THAN 2 FEET ON EITHER SIDE OF THE CROSSING.
- THE COST OF LUMINAIRE SHIELD SHALL BE INCLUDED IN THE COST OF HIGH MAST LUMINAIRES PAY ITEM, NO SEPARATE PAYMENT WILL BE MADE FOR LUMINAIRE SHIELD. SEE CONTRACT SPECIAL PROVISION FOR SPECIFIC LUMINAIRE SHIELD REQUIREMENTS.
-

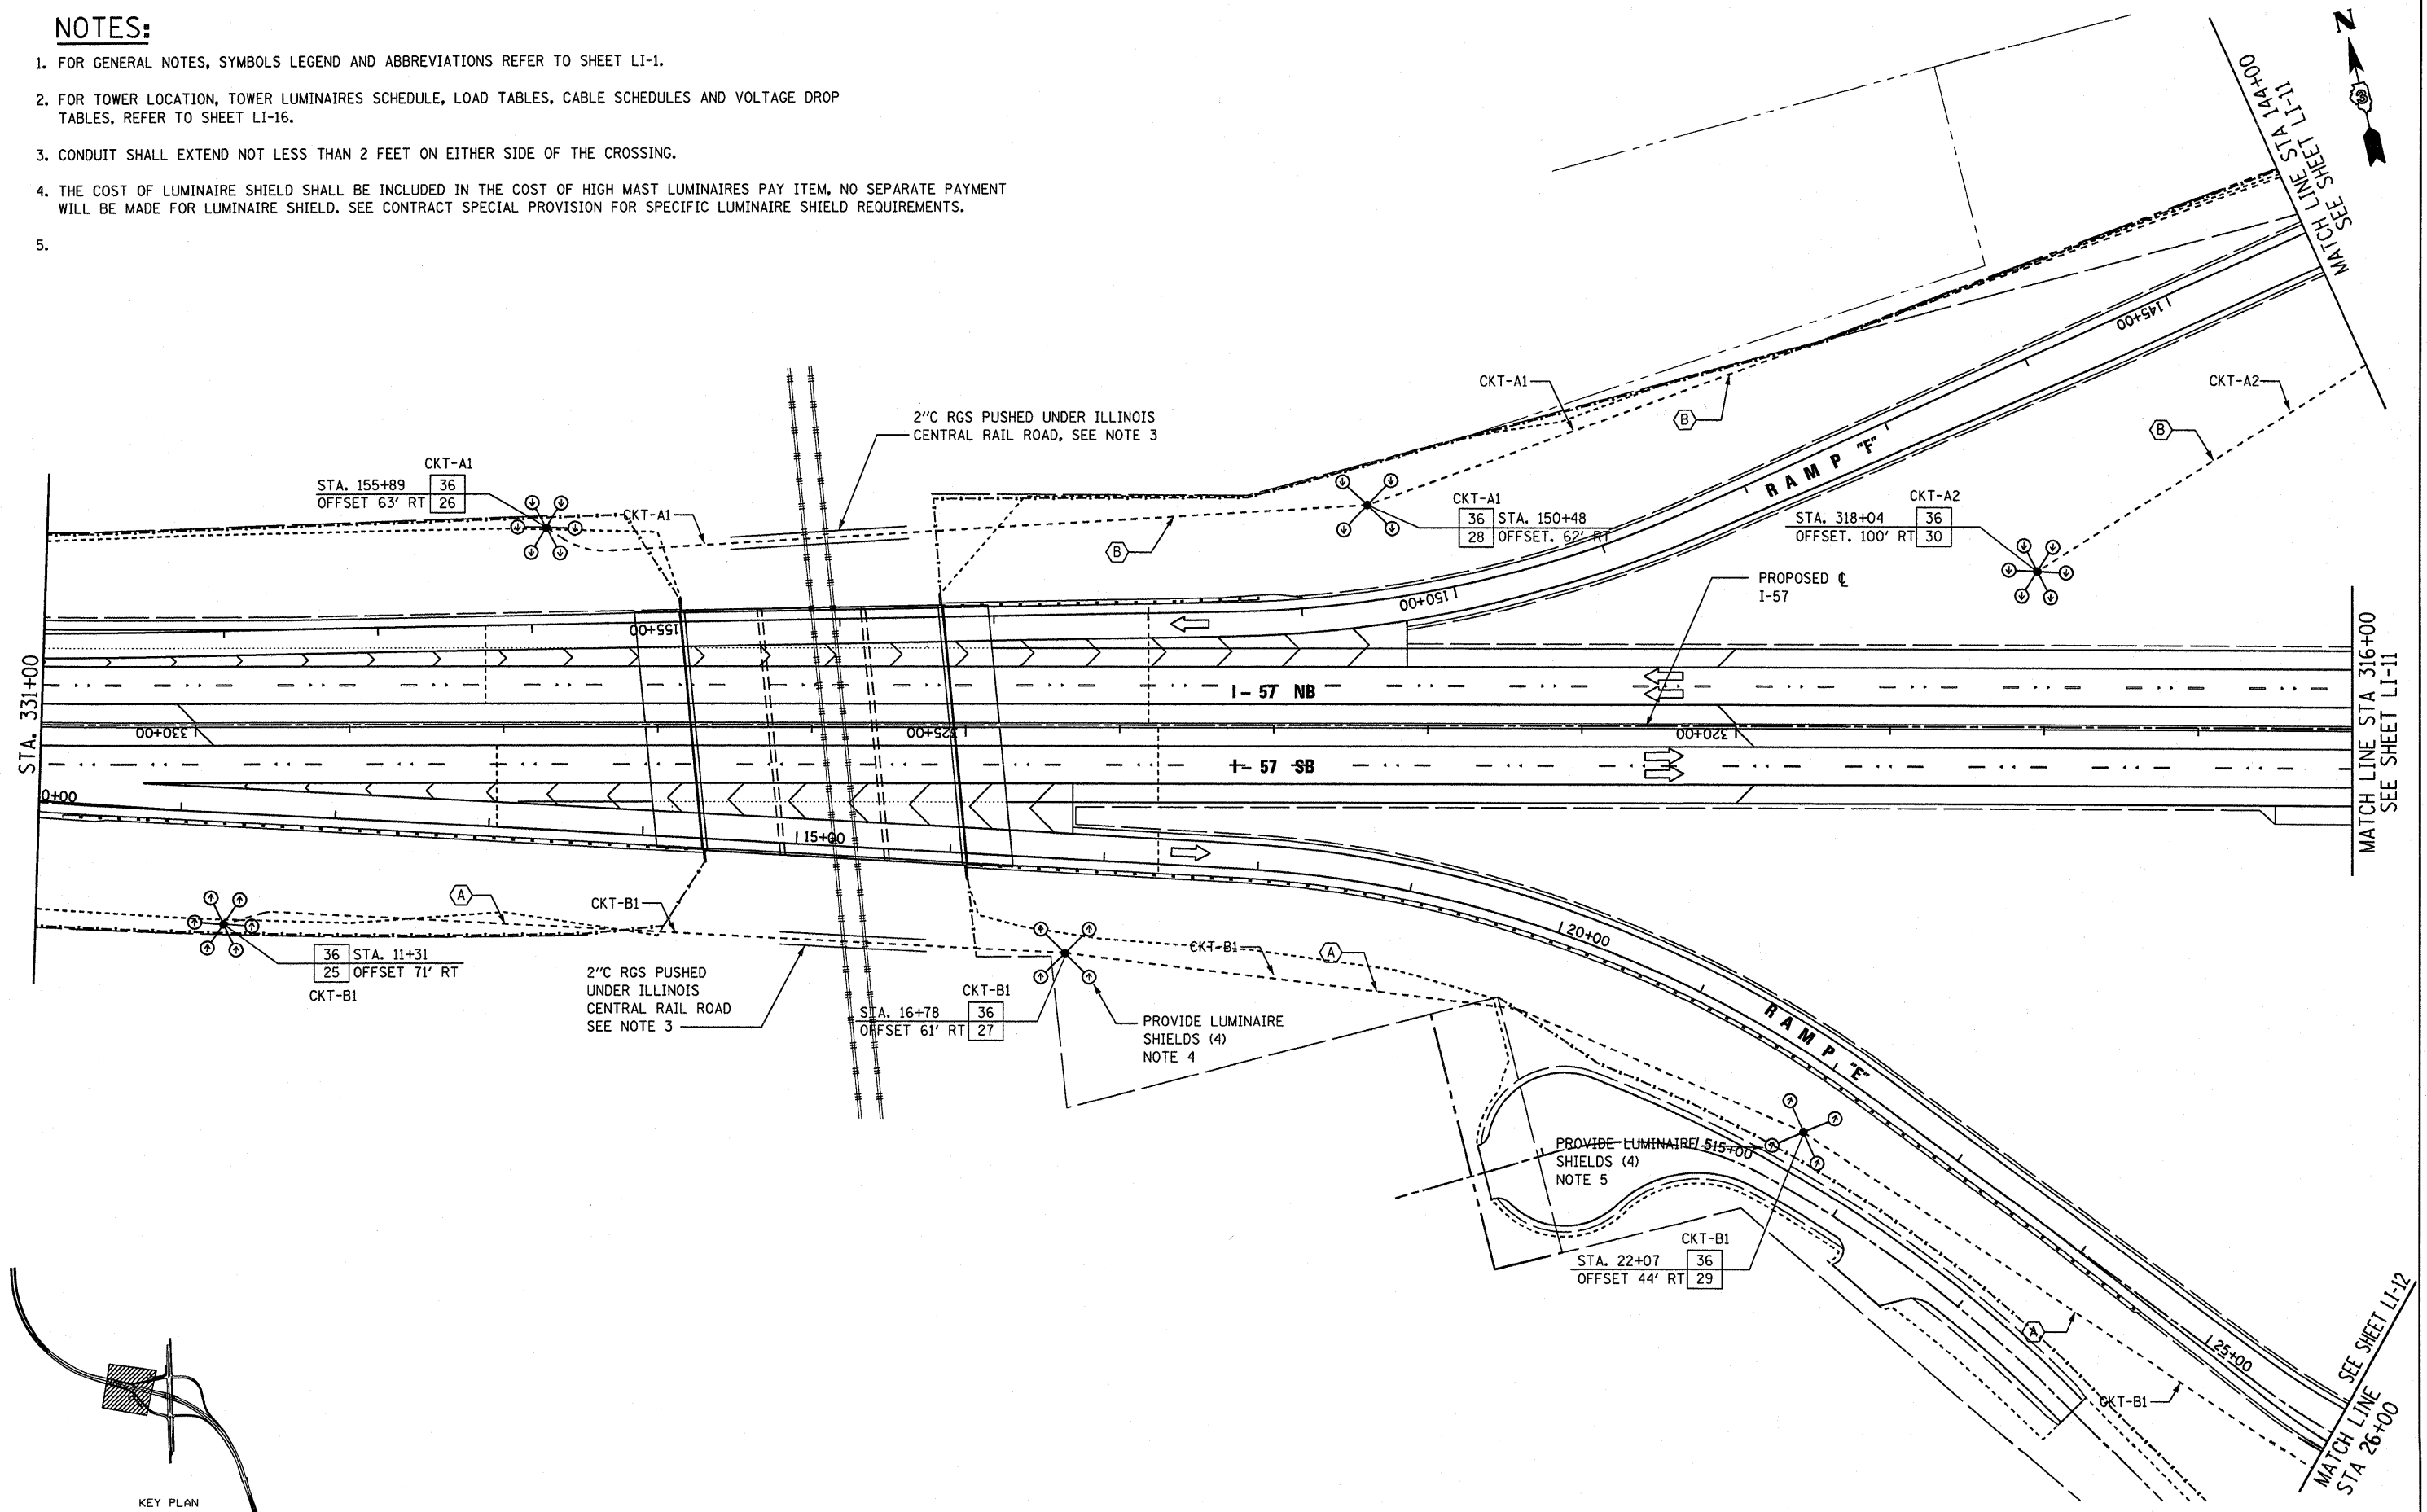

Delta Engineering, Inc.
 CONSULTING ENGINEERS, CONSTRUCTION MANAGERS, SURVEYORS
 111 West Jackson Blvd. Suite 910 Chicago, IL 60604-2001

FILE NAME =	USER NAME = carpenterdj	DESIGNED - HS	REVISED -	STATE OF ILLINOIS DEPARTMENT OF TRANSPORTATION	INTERCHANGE LIGHTING PLAN I-57, RAMP "E" AND RAMP "F"			F.A.I. RTE. 57	SECTION (46-2) I, HBR, VBR	COUNTY KANKAKEE	TOTAL SHEETS 558	SHEET NO. 257
ca:\pwork\pwork\carpenterdj\dms58954\I-10.DGN		DRAWN - KK	REVISED -		SCALE:	SHEET NO.	OF SHEETS	STA.	TO STA.	CONTRACT NO. 66409		
		CHECKED - HS	REVISED -							FED. ROAD DIST. NO. 3 ILLINOIS FED. AID PROJECT		
		DATE - 12-17-2010	REVISED -									