


TAG	UNDERPASS LIGHTING FIXTURE MOUNTING HEIGHT ABOVE PAVEMENT
36	17 FT
43	17 FT
44	14.5 FT
45	17 FT
46	14.5 FT
47	17 FT
48	14.5 FT
49	17 FT
50	14.5 FT
51	17.5 FT
52	17.5 FT
53	17.5 FT
54	17.5 FT

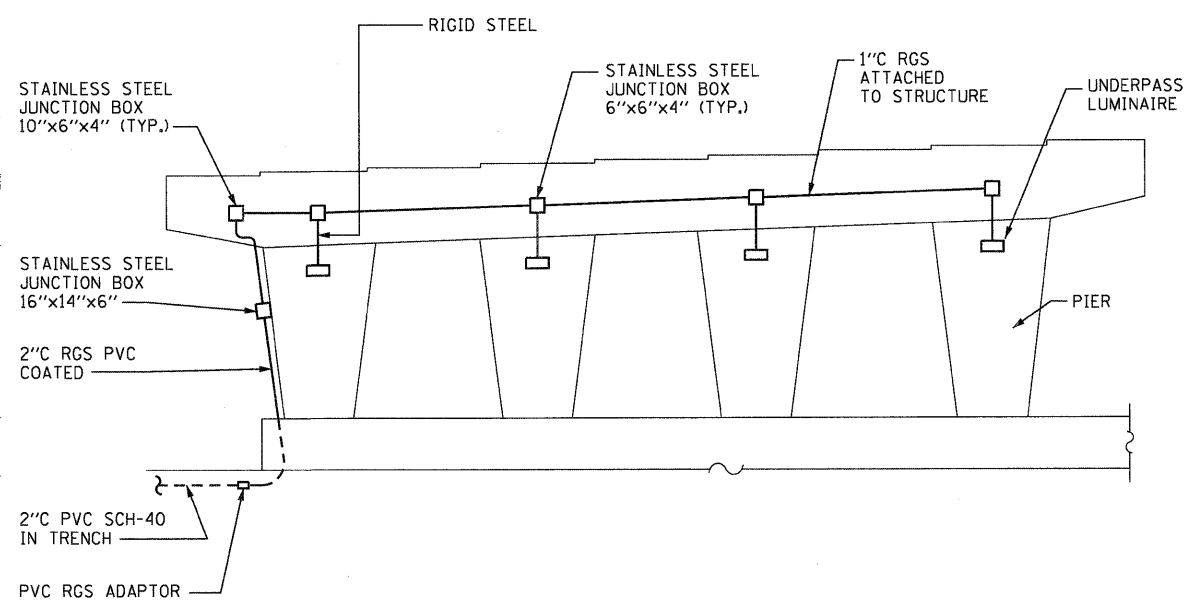

UNDERPASS LUMINAIRE MOUNTING DETAIL
 SCALE: N.T.S.

NOTES:

- FOR GENERAL NOTES, SYMBOLS LEGEND AND ABBREVIATIONS REFER TO SHEET LI-01.
- FOR LOAD TABLES, CABLE SCHEDULES AND VOLTAGE DROP TABLES REFER TO SHEET LI-16.
- ALL UNDERPASS LUMINAIRES SHALL BE MOUNTED ON THE PIERS.
- UNDERPASS LUMINAIRES MOUNTING HARDWARE SHALL BE INCLUDED IN THE COST OF THE UNDERPASS LUMINAIRE PAY ITEM.
- JUNCTION BOXES LOCATIONS ARE SHOWN DIAGRAMMATICALLY AND ACTUALLY THESE ARE MOUNTED ABOVE THE LUMINAIRES ON STRUCTURE ABOVE THE PIERS.
- UNDERPASS LUMINAIRE SHALL INCLUDE ALL WORK FROM THE STAINLESS STEEL JUNCTION BOX 16"x14"x6" TO THE UNDERPASS LUMINAIRES. THEREFORE THE CONDUIT, WIRES AND JUNCTION BOXES ATTACHED TO THE STRUCTURE AFTER THIS JUNCTION BOX (16"x14"x6") SHALL NOT BE PAID SEPARATELY BUT SHALL BE INCLUDED WITH THE COST OF UNDERPASS LUMINAIRE PAY ITEM.
- MOUNT WALKWAY LIGHTING FIXTURES ON STRUCTURE ABOVE PIERS AT 17.5 FT ABOVE PAVEMENT.

KEY PLAN

FILE NAME = g:\zd40403\LI-15.dgn	USER NAME = kkh	DESIGNED - HS	REVISIONS -	STATE OF ILLINOIS DEPARTMENT OF TRANSPORTATION	UNDERPASS LIGHTING PLAN			F.A.I. RTE. 57	SECTION (46-2) I, HBR, VBR	COUNTY KANKAKEE	TOTAL SHEETS 558	SHEET NO. 262	
	PLOT SCALE = 1:20	DRAWN - KK	REVISIONS -		SCALE:	SHEET NO.	OF	SHEETS	STA.	TO	STA.	FED. ROAD DIST. NO. 3	ILLINOIS FED. AID PROJECT
	PLOT DATE = 12/17/2010	CHECKED - HS	REVISIONS -										
		DATE - 12-17-2010	REVISIONS -										