
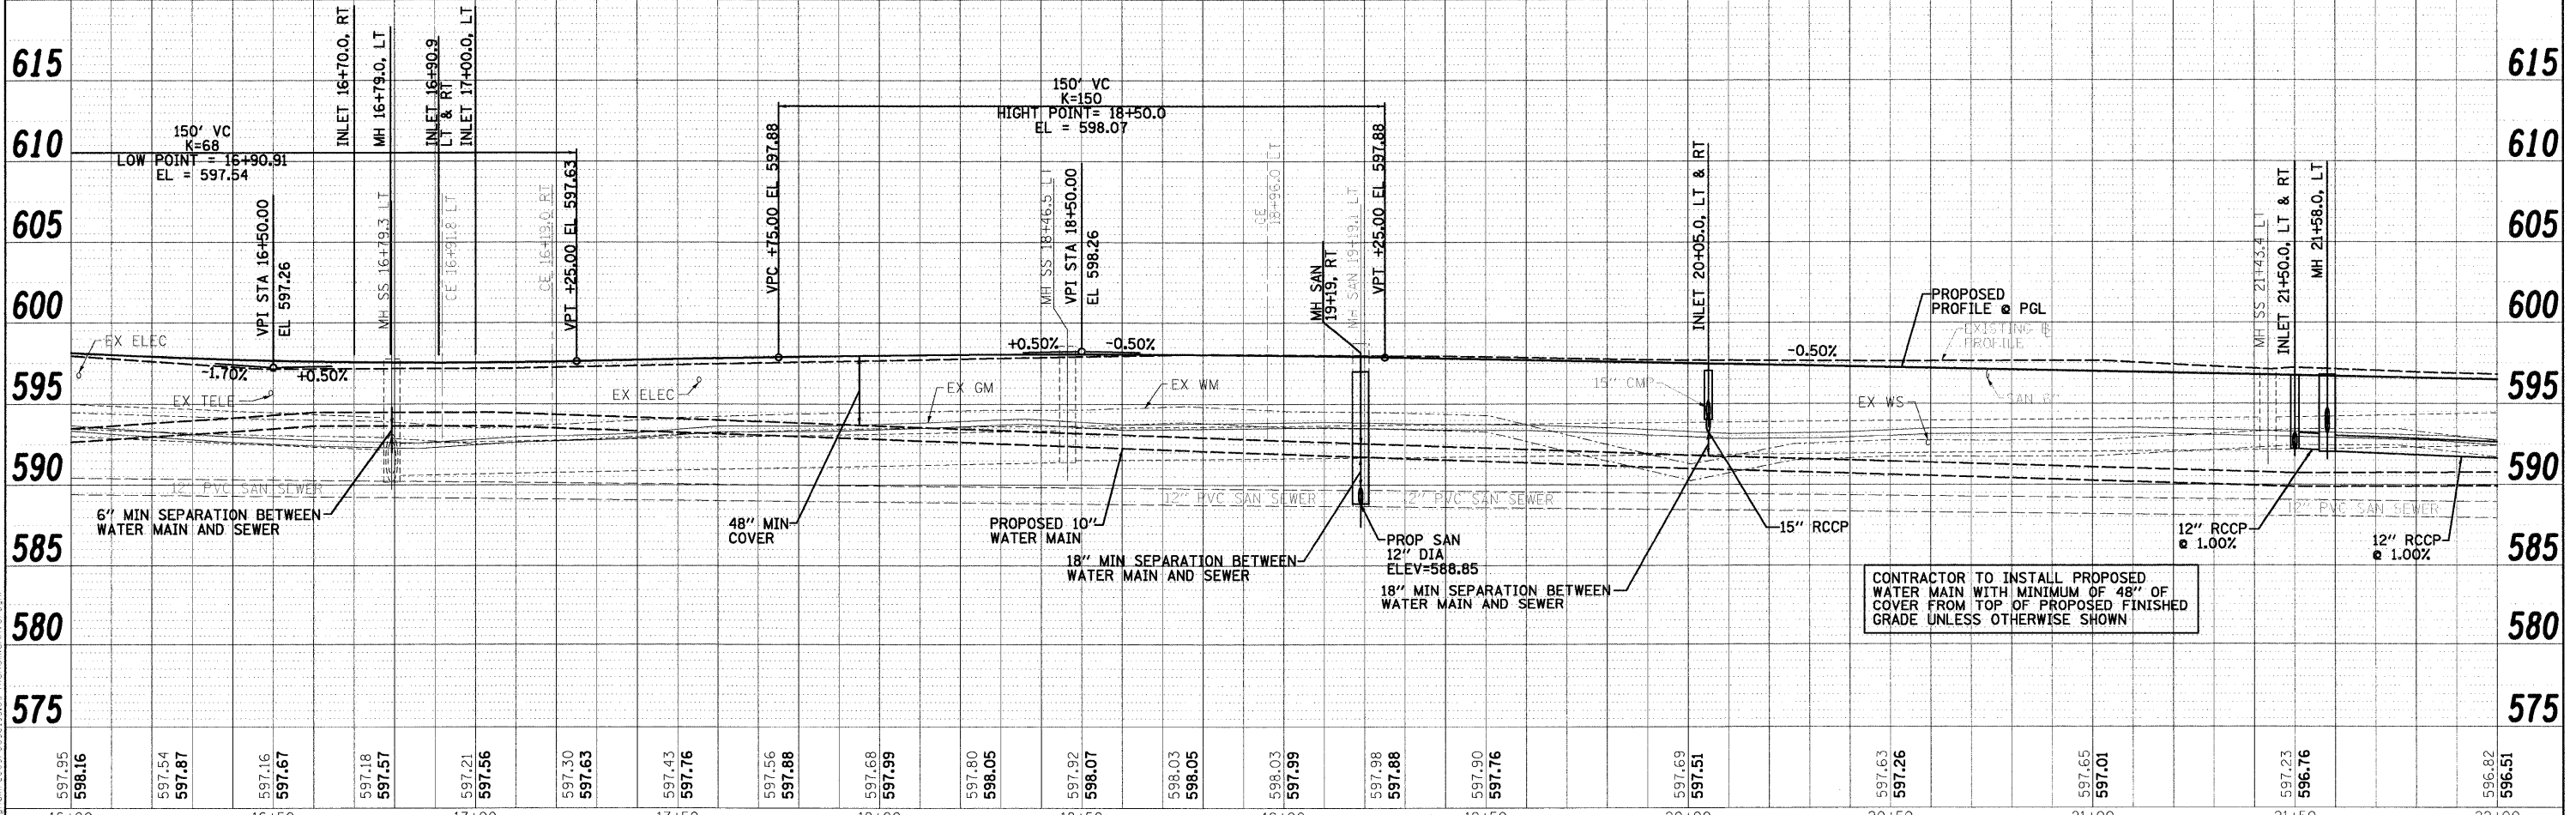


DATE	10/19/10
BY	JTC
CHECKED	ACH
DATE	10/19/10
SCALE	AS SHOWN
PROJECT	WATER MAIN
NO.	00112-00-PV
DATE	10/19/10
SCALE	AS SHOWN
PROJECT	WATER MAIN
NO.	00112-00-PV

DATE	10/19/10
BY	JTC
CHECKED	ACH
DATE	10/19/10
SCALE	AS SHOWN
PROJECT	WATER MAIN
NO.	00112-00-PV
DATE	10/19/10
SCALE	AS SHOWN
PROJECT	WATER MAIN
NO.	00112-00-PV

IL 45 TO EAST OF BOX  
 009018.WM.P&P-west.dgn  
 10/19/2010 1:08:13 PM  
 P:\City of Effingham\2009-2010\00112-00-PV-RickelmanAve.dwg

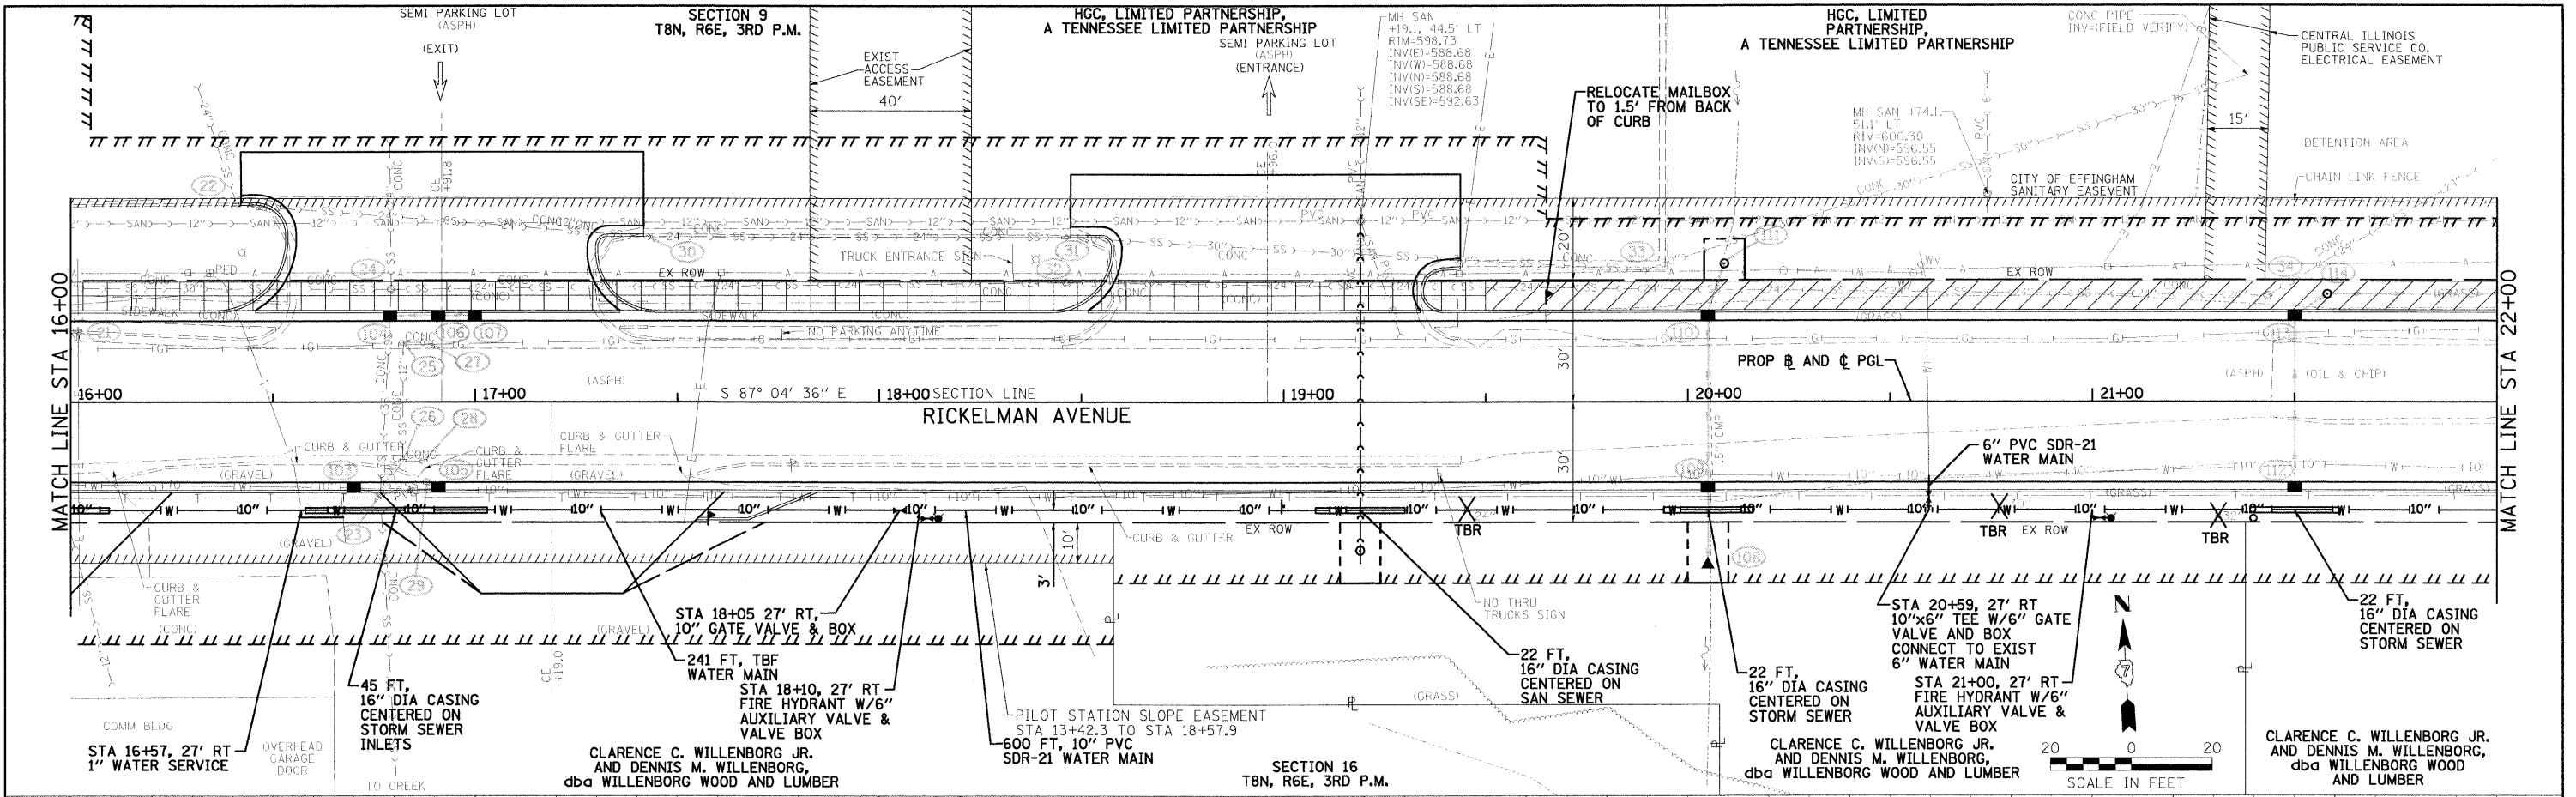

FILE NAME 009018.WM.P&P-west.dgn	USER NAME #USER#	DESIGNED RJB/ACH	REVISED -	<b>CITY OF EFFINGHAM</b>	<b>RICKELMAN AVE (FAU 8376) SECTION 07-00112-00-PV WATER MAIN PLAN AND PROFILE</b>	F.A.U. RTE. 8376	SECTION 07-00112-00-PV	COUNTY EFFINGHAM	TOTAL SHEETS 53	SHEET NO. 24	
PLCT SCALE #SCALE#	CHECKED ACH	REVISOR -	DATE 10/19/10			SCALE 1"=20'	SHEET NO. OF SHEETS	STA. 16+00.0 TO STA. 22+00.0	FED. ROAD DIST. NO.	ILLINOIS FED. AID PROJECT	CONTRACT NO. 95635
PLCT DATE 10/19/2010	DATE 10/19/10	REVISOR -	DATE 10/19/10								