

TIE-IN #3 NOTE:


WHERE THE EXISTING UNDERDRAIN FROM UNDER RUNWAY 9-27 TIES TO THE EXISTING UNDERDRAIN RUNNING PARALLEL TO RUNWAY 9-27, THE EXISTING INSPECTION HOLE WILL BE REMOVED SO AS NOT TO DAMAGE THE EXISTING UNDERDRAIN GOING UNDER RUNWAY 9-27. THIS UNDERDRAIN WILL BE CONNECTED WITH A SECTION OF UNDERDRAIN AND ATTACHED TO THE ADJACENT PROPOSED UNDERDRAIN TO FORM A SAND-TIGHT CONNECTION. THE LENGTH OF UNDERDRAIN WILL BE PAID FOR PER L.F. UNDER THE UNDERDRAIN PAY ITEM. THESE CONNECTIONS WILL BE CONSIDERED PART OF THE UNDERDRAIN INSTALLATION AND NO ADDITIONAL COMPENSATION WILL BE ALLOWED.

TIE-IN NOTE:

AT LOCATIONS WHERE THE PROPOSED UNDERDRAIN IS TO BE CONNECTED TO THE EXISTING UNDERDRAIN, THE CONTRACTOR WILL EXCAVATE AND EXPOSE THE EXISTING UNDERDRAIN AND VERIFY THE EXISTING UNDERDRAIN ELEVATIONS PRIOR TO INSTALLING THAT SECTION OF UNDERDRAIN.



ELECTRICAL DUCT NOTE:

THE ELECTRICAL CONTRACTOR WILL INSTALL THE PROPOSED DUCT BELOW THE FLOWLINE ELEVATION OF THE PROPOSED EDGEDRAIN. ANY ADDITIONAL EXCAVATION OR INCIDENTALS WILL BE CONSIDERED PART OF THE DUCT INSTALLATION AND NO ADDITIONAL COMPENSATION WILL BE ALLOWED.

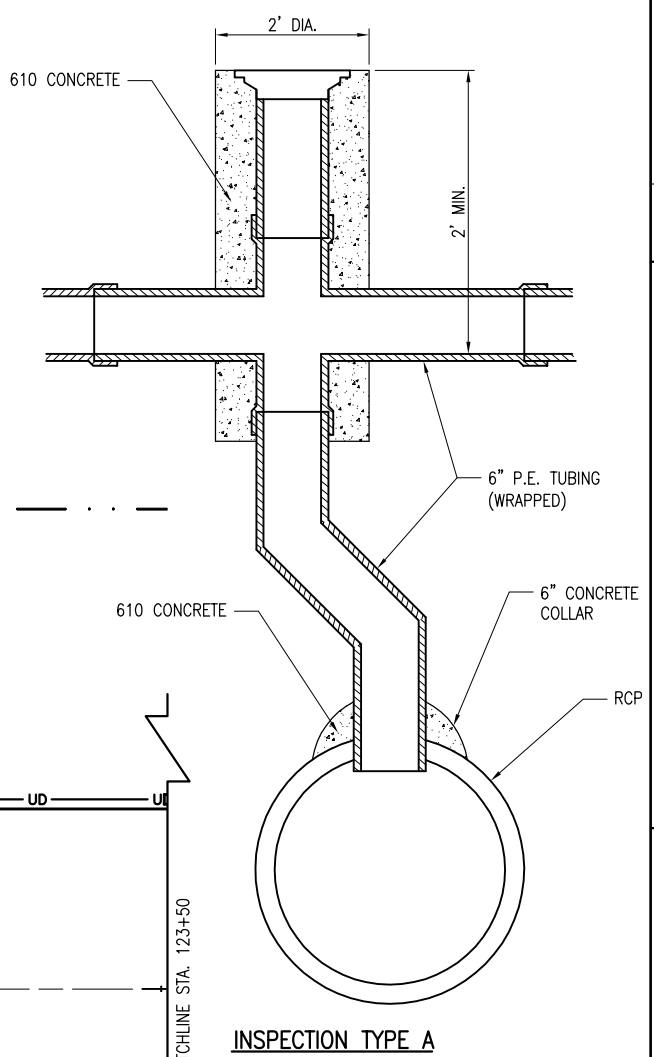

LEGEND

  - EXISTING IMPROVEMENTS
- PROPOSED IMPROVEMENTS
- EXISTING CMP UNDER DRAIN
- EXISTING UNDER DRAIN TO BE REMOVED
- PROPOSED 6" UNDER DRAIN
- PROPOSED STORM SEWER
- EXISTING UNDER DRAIN CLEAN OUT TO BE REMOVED
- PROPOSED UNDER DRAIN CLEAN OUT
- EXISTING HEAD WALL
- PROPOSED FLARED END SECTION
- PROPOSED RIPRAP



| REVISION | DATE |
|----------|------|
| | |
| | |
| | |

EDGAR COUNTY AIRPORT
PARIS, ILLINOIS
A.I.P. PROJ.: 3-17-0077-B13
IL PROJ.: PRG-4018

| | | |
|--------------------------|-----|----------|
| Hanson Proj. No. 10A0053 | BAK | 01/10/11 |
| Filename R-131DRN_1.DWG | BAK | 01/10/11 |
| Scale NOT TO SCALE | | |
| Date 03/10/11 | | |
| LAYOUT | | |
| DRAWN | | |
| REVIEWED | | |

HANSON
Professional Services Inc. 2011
1525 South Sixth Street
Springfield, Illinois 62703-2886
www.hanson-inc.com
Offices Nationwide

CONSTRUCT CROSSWIND
RUNWAY 18-36
PROPOSED DRAINAGE PLAN
STA. 119+00 TO STA. 123+00

MAR 11, 2011 10:37 AM RINKED0461 C:\PWISE_WORK\DO_NOT_DELETE\DMST8063\RP-131DRN_1.DWG