


MATCHLINE - SEE TERMINAL AREA ELECTRICAL PLAN SHEET


LEGEND

- EXISTING PAVEMENT
- PROPOSED PAVEMENT
- EXISTING ELECTRICAL DUCT
- PROPOSED ELECTRICAL DUCT
- EXISTING ELECTRICAL CABLES
- PROPOSED 1/C #8 AWG, FAA L-824, 5000 VOLT TYPE C UG CABLE IN UNIT DUCT
- PROPOSED 2-1/C #4 AWG, XLP-USE 600 VOLT UG CABLE IN UNIT DUCT
- PROPOSED 3-1/C #6 AWG, XLP-USE 600 VOLT UG CABLE IN UNIT DUCT
- PROPOSED 3-1/C #4 AWG, XLP-USE 600 VOLT UG CABLE IN UNIT DUCT
- PROPOSED 12 PAIR #24 AWG COMMUNICATIONS CABLE IN UNIT DUCT
- EXISTING AWOS COMMUNICATION CABLE
- EXISTING STAKE MOUNTED TAXIWAY LIGHT
- EXISTING BASE MOUNTED TAXIWAY LIGHT
- PROPOSED STAKE MOUNTED TAXIWAY LIGHT
- PROPOSED BASE MOUNTED TAXIWAY LIGHT
- EXISTING STAKE MOUNTED RUNWAY LIGHT
- EXISTING BASE MOUNTED RUNWAY LIGHT
- PROPOSED STAKE MOUNTED RUNWAY LIGHT
- PROPOSED BASE MOUNTED RUNWAY LIGHT
- PROPOSED STAKE MOUNTED THRESHOLD LIGHT
- PROPOSED TAXI GUIDANCE SIGN
- EXISTING ELECTRICAL STRUCTURE (HANDHOLE, SPLICE CAN)
- PROPOSED ELECTRICAL STRUCTURE (MANHOLE, HANDHOLE, SPLICE CAN)
- EXISTING ELECTRICAL MARKER (DUCT MARKER, CABLE MARKER)

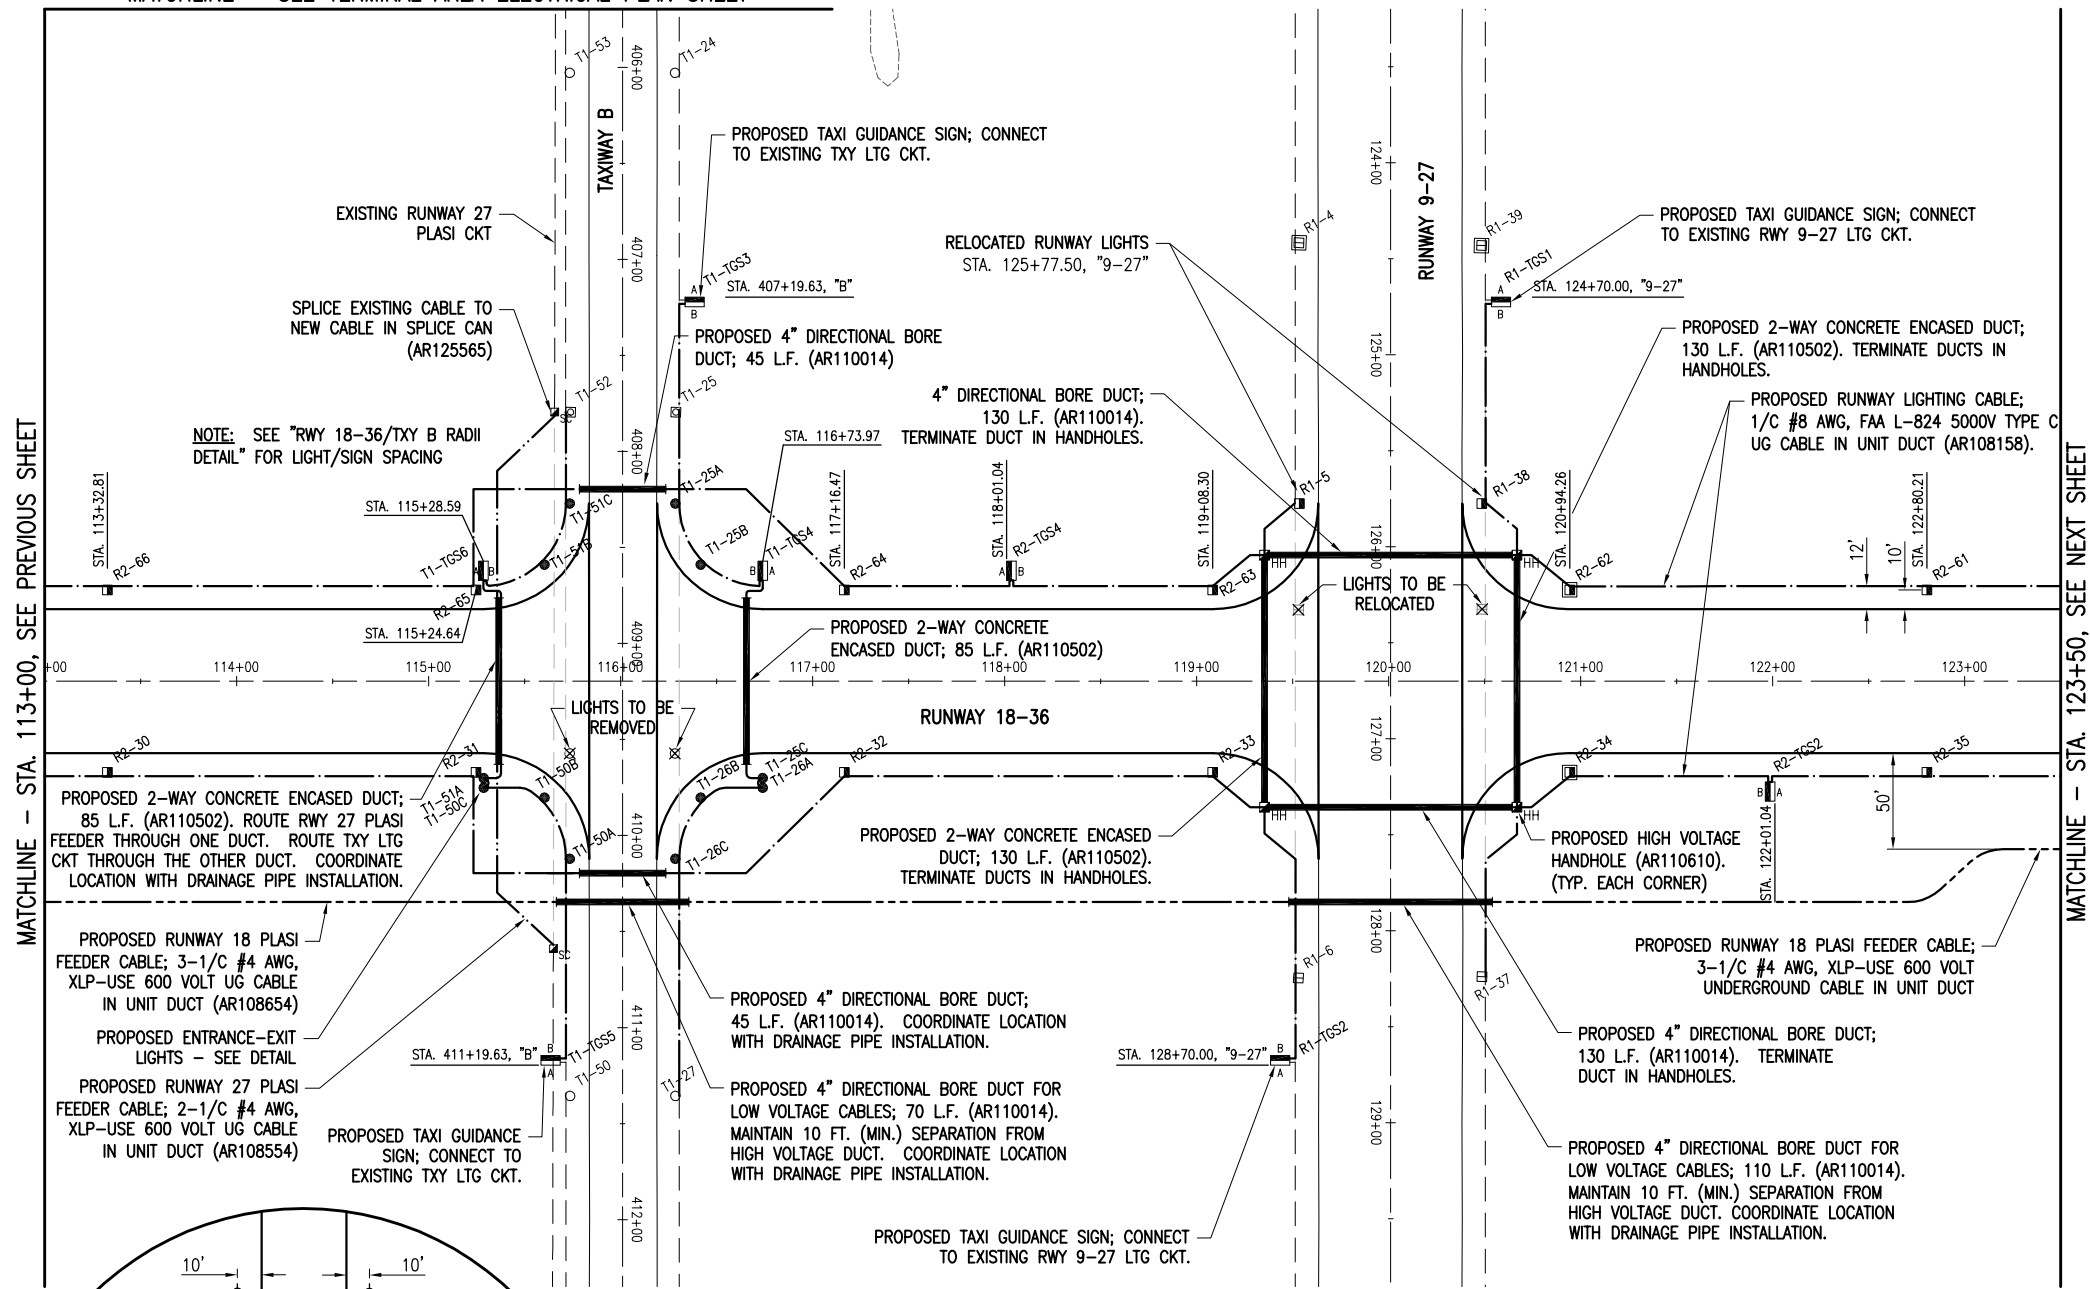

MATCHLINE - STA. 113+00, SEE PREVIOUS SHEET

MATCHLINE - STA. 123+50, SEE NEXT SHEET

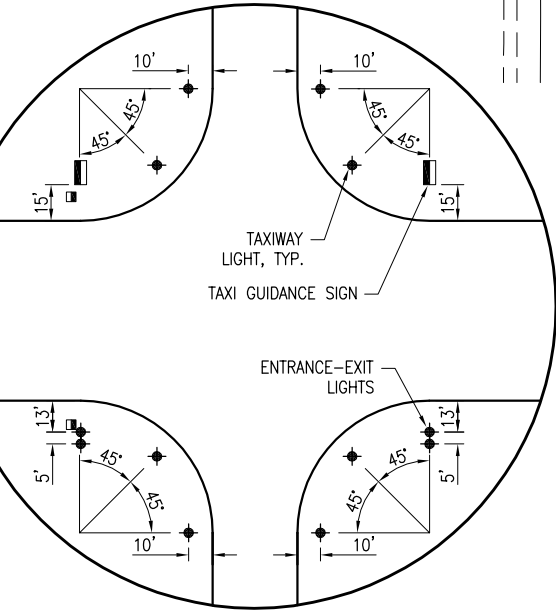


RWY 18-36/TXY B RADII DETAIL
NOT TO SCALE

LIGHT LENS SCHEDULE		
LIGHT NUMBERS	LENS	ORIENTATION
R2-1 TO R2-6	CLEAR WHITE/AMBER	AMBER SIDE FACING NORTH
R2-7 TO R2-15	BLUE	---
R2-16 TO R2-23	RED/GREEN	RED SIDE FACING NORTH (TOWARDS THRESHOLD)
R2-24 TO R2-31	CLEAR WHITE/AMBER	AMBER SIDE FACING NORTH
R2-32 TO R2-39	CLEAR WHITE/AMBER	AMBER SIDE FACING SOUTH
R2-40 TO R2-47	RED/GREEN	RED SIDE FACING SOUTH (TOWARDS THRESHOLD)
R2-48 TO R2-56	BLUE	---
R2-57 TO R2-64	CLEAR WHITE/AMBER	AMBER SIDE FACING SOUTH
R2-65 TO R2-66	CLEAR WHITE/AMBER	AMBER SIDE FACING NORTH
T1-25A TO T1-26C	BLUE	---
T1-50A TO T1-51C	BLUE	---

ELECTRICAL DUCT NOTE:

THE ELECTRICAL CONTRACTOR WILL INSTALL THE PROPOSED DUCT BELOW THE FLOWLINE ELEVATION OF THE PROPOSED EDGEDRAIN. ANY ADDITIONAL EXCAVATION OR INCIDENTALS WILL BE CONSIDERED PART OF THE DUCT INSTALLATION AND NO ADDITIONAL COMPENSATION WILL BE ALLOWED.

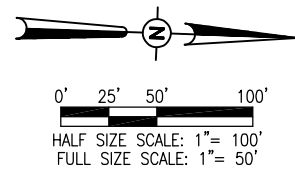

MAR 11, 2011 10:44 AM RINKED0461 C:\PWISE_WORK\DO_NOT_DELETE\DMST8063\14-142ELE.DWG

REVISION		EDGAR COUNTY AIRPORT PARIS, ILLINOIS	A.I.P. PROJ.: 3-17-0077-B13
DATE			
		IL PROJ.: PRG-4018 IL A.P. PROJ.: 3-17-0077-B13	
Hanson Proj. No. 10A00553 Filename R-142ELE.DWG Scale 1" = 50' Date 03/10/11			
LAYOUT	KML/MLH	01/04/11	01/04/11
DRAWN	MLH	01/04/11	01/04/11
REVIEWED	CAH	02/04/11	02/04/11
CONSTRUCT CROSSWIND RUNWAY 18-36		PROPOSED ELECTRICAL PLAN STA. 113+00 TO STA. 123+50	
35			
35 of 137 sheets			