


ROUTE NO.	SECTION	COUNTY	TOTAL SHEETS	SHEET NO.
F.A.I. 94	*	COOK	110	80
F.H.W.A.	REGION - I	ILLINOIS	PROJECT	
* 1010.1 B-R 1012.1 (85)				

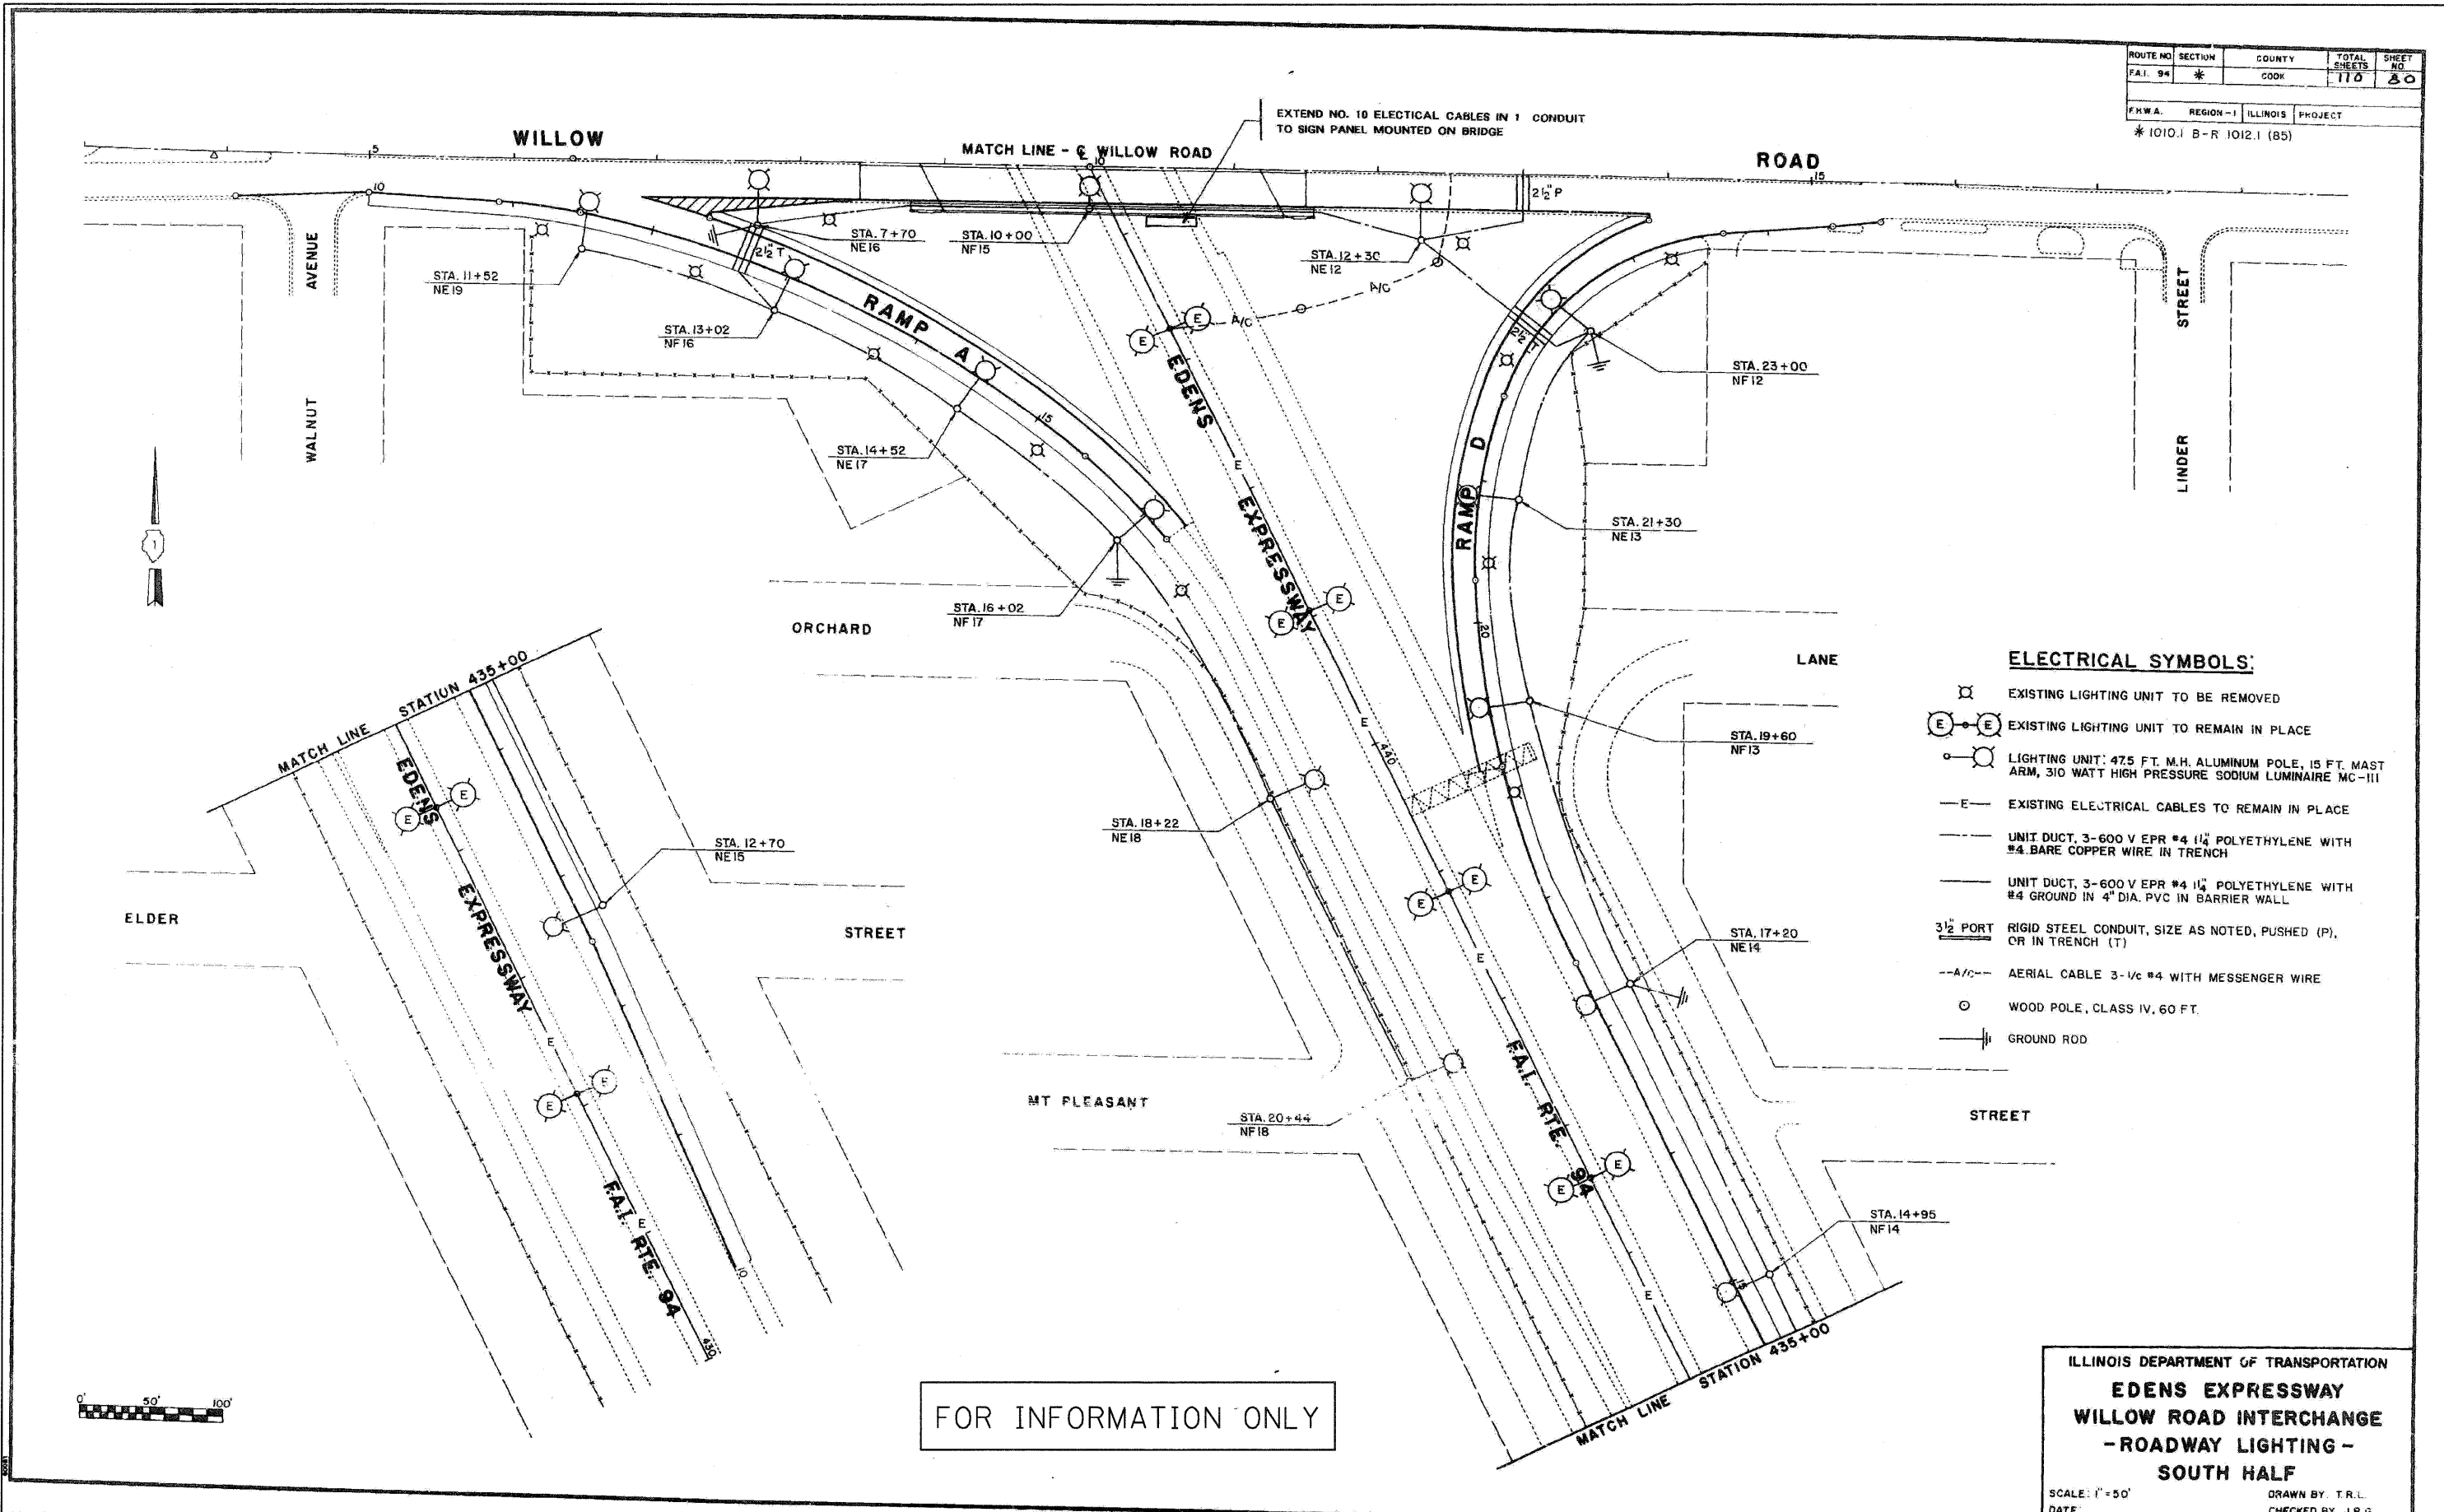

- ELECTRICAL SYMBOLS:**
- ⊠ EXISTING LIGHTING UNIT TO BE REMOVED
  - ⊙ EXISTING LIGHTING UNIT TO REMAIN IN PLACE
  - LIGHTING UNIT: 47.5 FT. M.H. ALUMINUM POLE, 15 FT. MAST ARM, 310 WATT HIGH PRESSURE SODIUM LUMINAIRE MC-III
  - E- EXISTING ELECTRICAL CABLES TO REMAIN IN PLACE
  - UNIT DUCT, 3-600 V EPR #4 1 1/2" POLYETHYLENE WITH #4 BARE COPPER WIRE IN TRENCH
  - UNIT DUCT, 3-600 V EPR #4 1 1/2" POLYETHYLENE WITH #4 GROUND IN 4" DIA. PVC IN BARRIER WALL
  - 3/2" PORT RIGID STEEL CONDUIT, SIZE AS NOTED, PUSHED (P), OR IN TRENCH (T)
  - A/C- AERIAL CABLE 3-1/2" #4 WITH MESSENGER WIRE
  - WOOD POLE, CLASS IV, 60 FT.
  - ⊥ GROUND ROD

FOR INFORMATION ONLY

ILLINOIS DEPARTMENT OF TRANSPORTATION  
**EDENS EXPRESSWAY  
 WILLOW ROAD INTERCHANGE  
 -ROADWAY LIGHTING -  
 SOUTH HALF**  
 SCALE: 1" = 50'  
 DATE: \_\_\_\_\_ DRAWN BY: T.R.L.  
 CHECKED BY: J.R.G.

FILE NAME =	DESIGNED - RMG	REVISED -
USER NAME =	DRAWN - RMG	REVISED -
PLOT DATE = 8/22/2010	CHECKED - KJN	REVISED -
	DATE - 3/19/10	REVISED -

**benesch**

STATE OF ILLINOIS  
 DEPARTMENT OF TRANSPORTATION

EXISTING LIGHTING PLANS

SCALE: N.T.S. SHEET NO. 2 OF 4 SHEETS STA. \_\_\_\_\_ TO STA. \_\_\_\_\_

F.A.I. RTE.	SECTION	COUNTY	TOTAL SHEETS	SHEET NO.
94	1010.1-1-2	COOK	37	10
FED. ROAD DIST. NO.				ILLINOIS FED. AID PROJECT
CONTRACT NO. 60J30				