
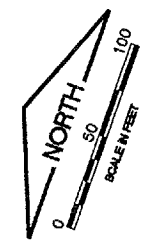




KA036

K:\Kankakee\0707502\Draw\Sheets
 FILE: Lighting--4.dwg
 LAYOUT: Layout1
 UPDATE BY: Jim Ohse
 SURVEY BOOK #
 DATE: Thursday, April 17, 2008 2:31:28 PM
 XREF DWG: tbcont.dwg
 tb.dwg
 elec-base.dwg

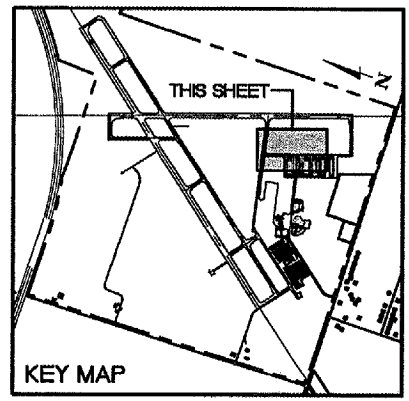

SEE LIGHTING PLAN SHEET 11
 FOR LEGEND AND NOTES

REVISIONS		
NUMBER	BY	DATE

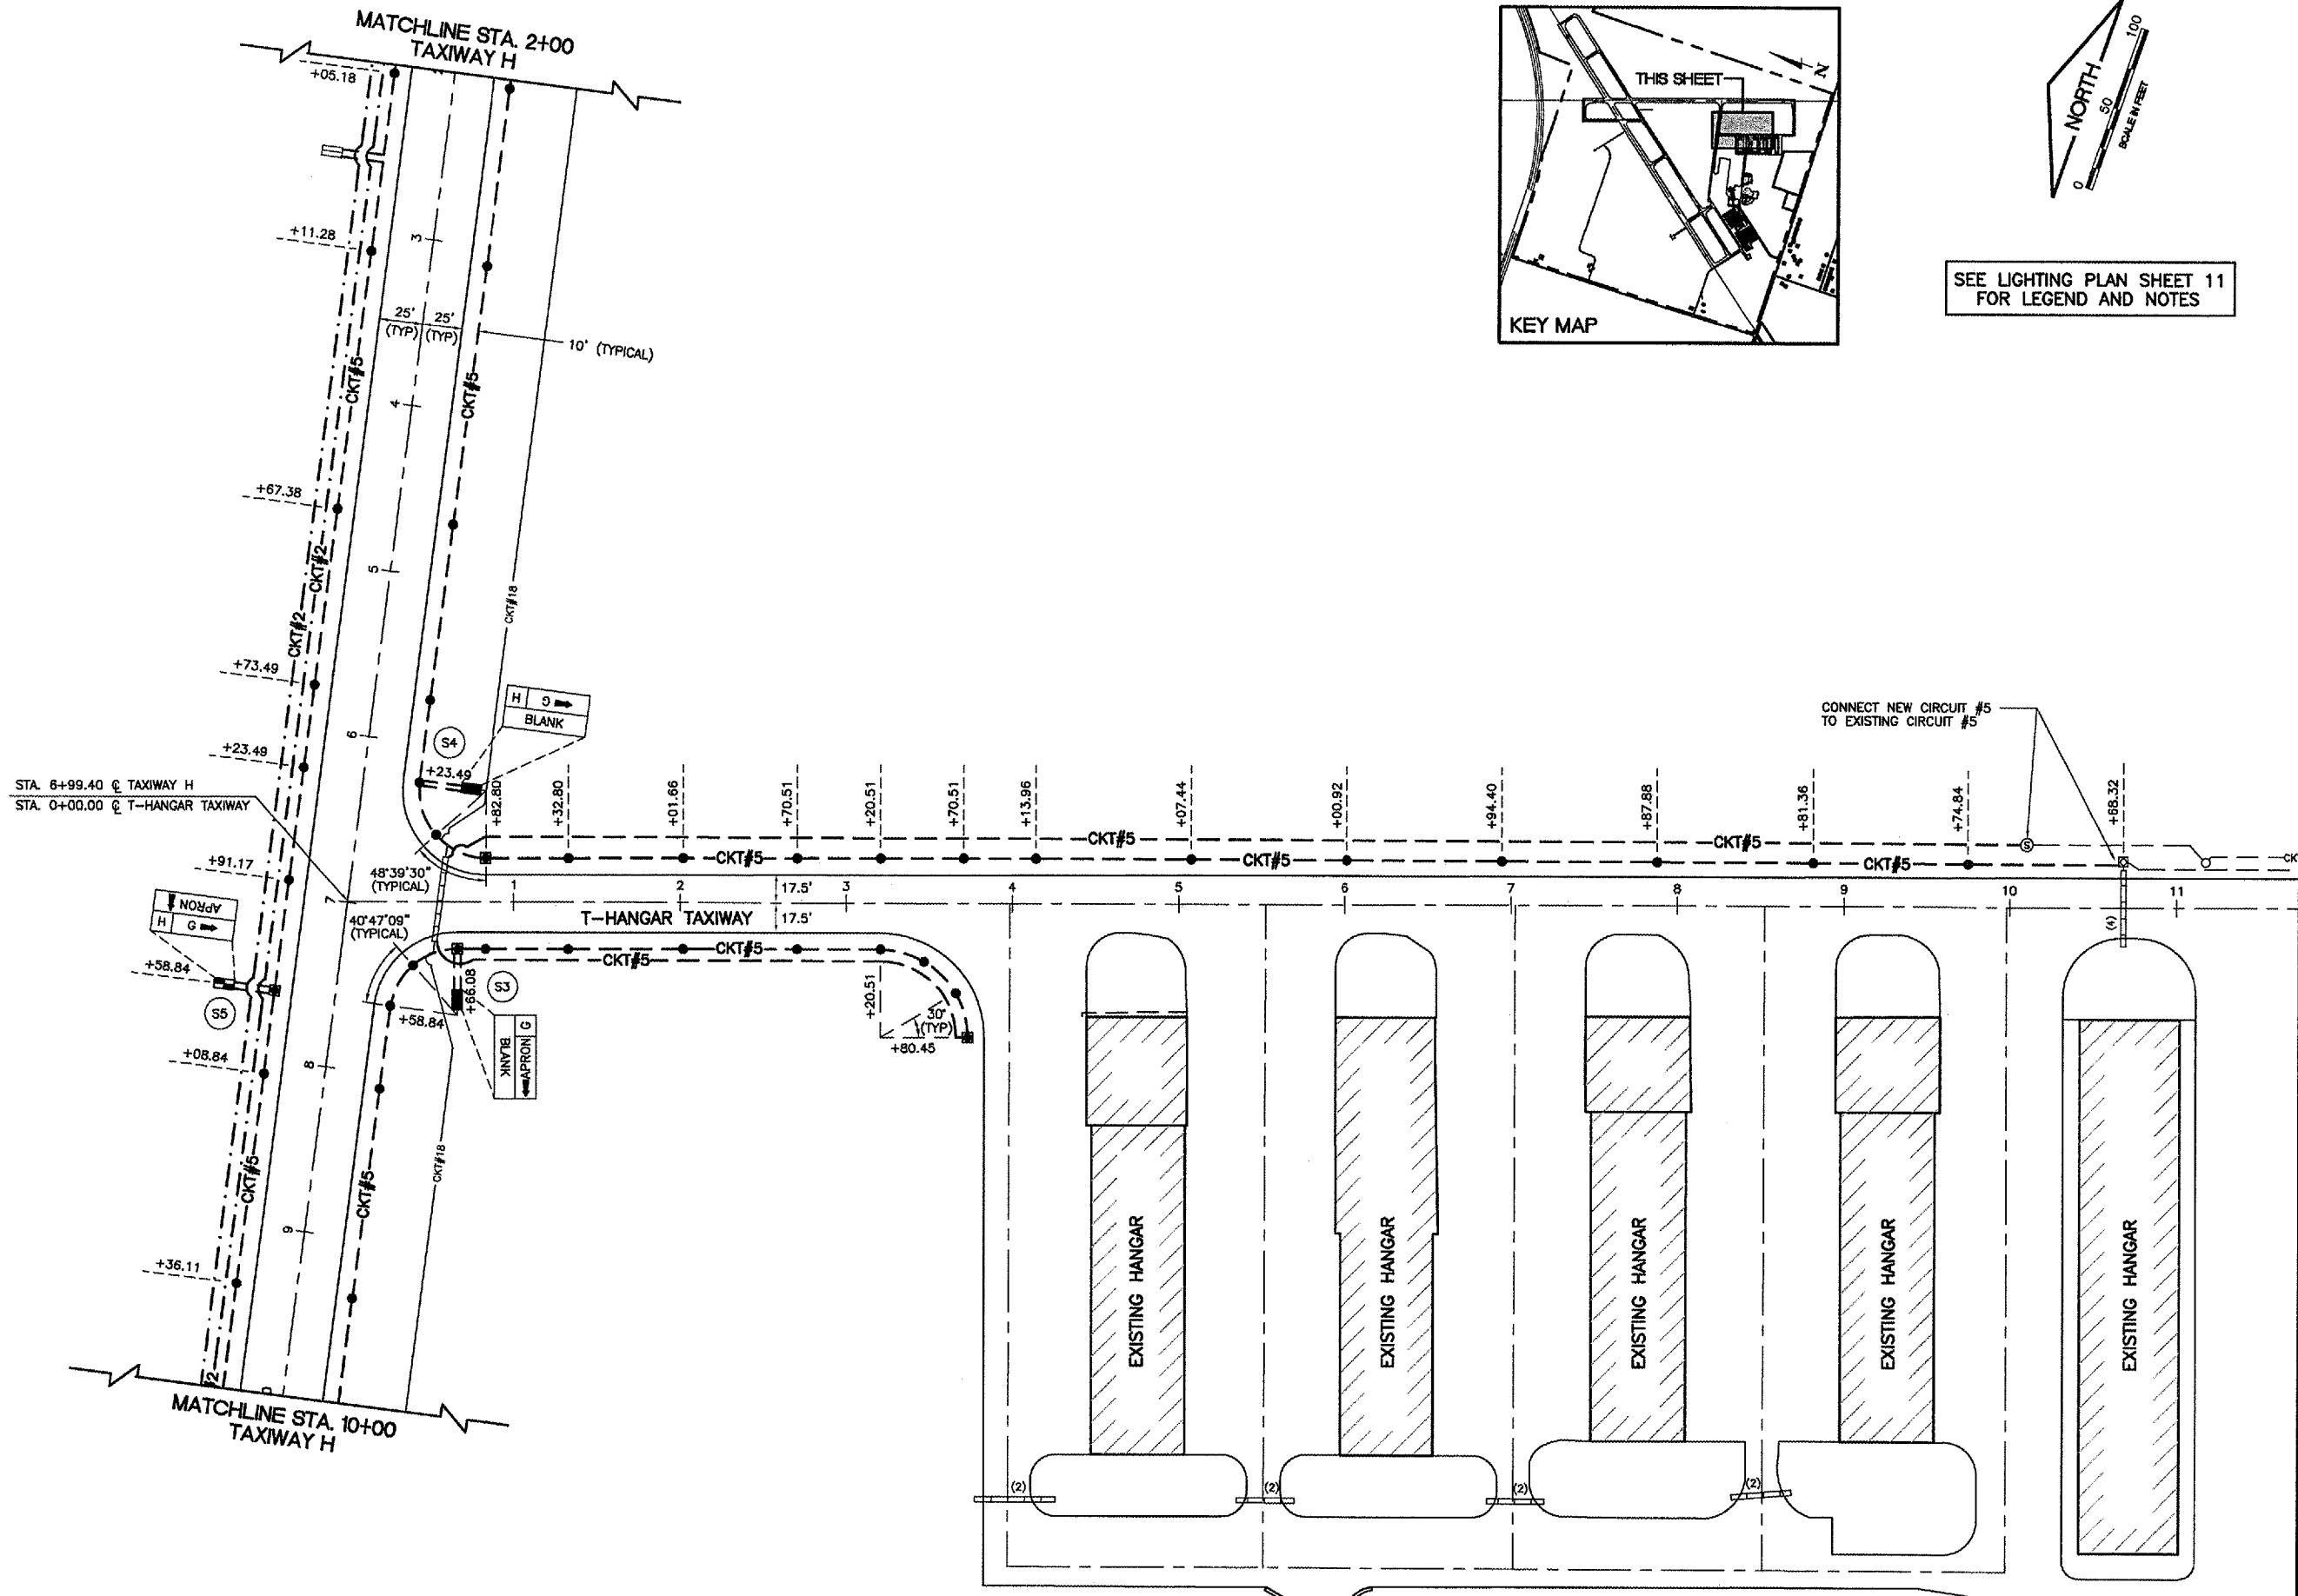 

**GREATER KANKAKEE AIRPORT
 KANKAKEE, ILLINOIS
 REHABILITATE AIRFIELD LIGHTING SYSTEM -
 RUNWAY 16/34 AND TAXIWAY H
 AIRFIELD LIGHTING PLAN
 TAXIWAY H
 STA. 2+00 TO STA. 10+00**

© Copyright CMT, Inc.
CMT
 CRAWFORD, MURPHY & TILLY, INC.
 CONSULTING ENGINEERS
 License No. 784-000618

DESIGN BY: MND
 DRAWN BY: JRO
 CHECKED BY: MND
 APPROVED BY:
 DATE: 02/29/08
 JOB No: 07075-02

IL PROJECT: IKK-3743
 A.I.P. PROJECT: 3-17-0057-B13