





KA036

K:\KankakeeAp\0707502\Draw\Sheets
 FILE: Lighting-5.dwg
 LAYOUT: Layout1
 UPDATE BY: Jim Ohse
 SURVEY BOOK #
 DATE: Thursday, April 17, 2008 2:30:21 PM
 XREF DWG: tbcInt.dwg
 tb.dwg
 elec-base.dwg

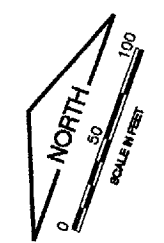

SEE LIGHTING PLAN SHEET 11
 FOR LEGEND AND NOTES

REVISIONS		
NUMBER	BY	DATE

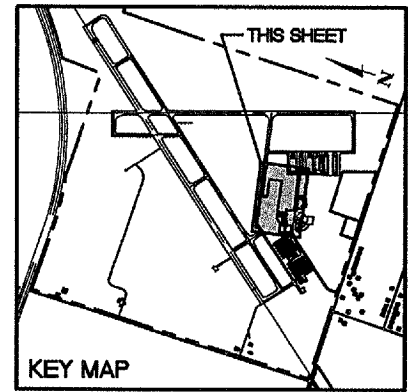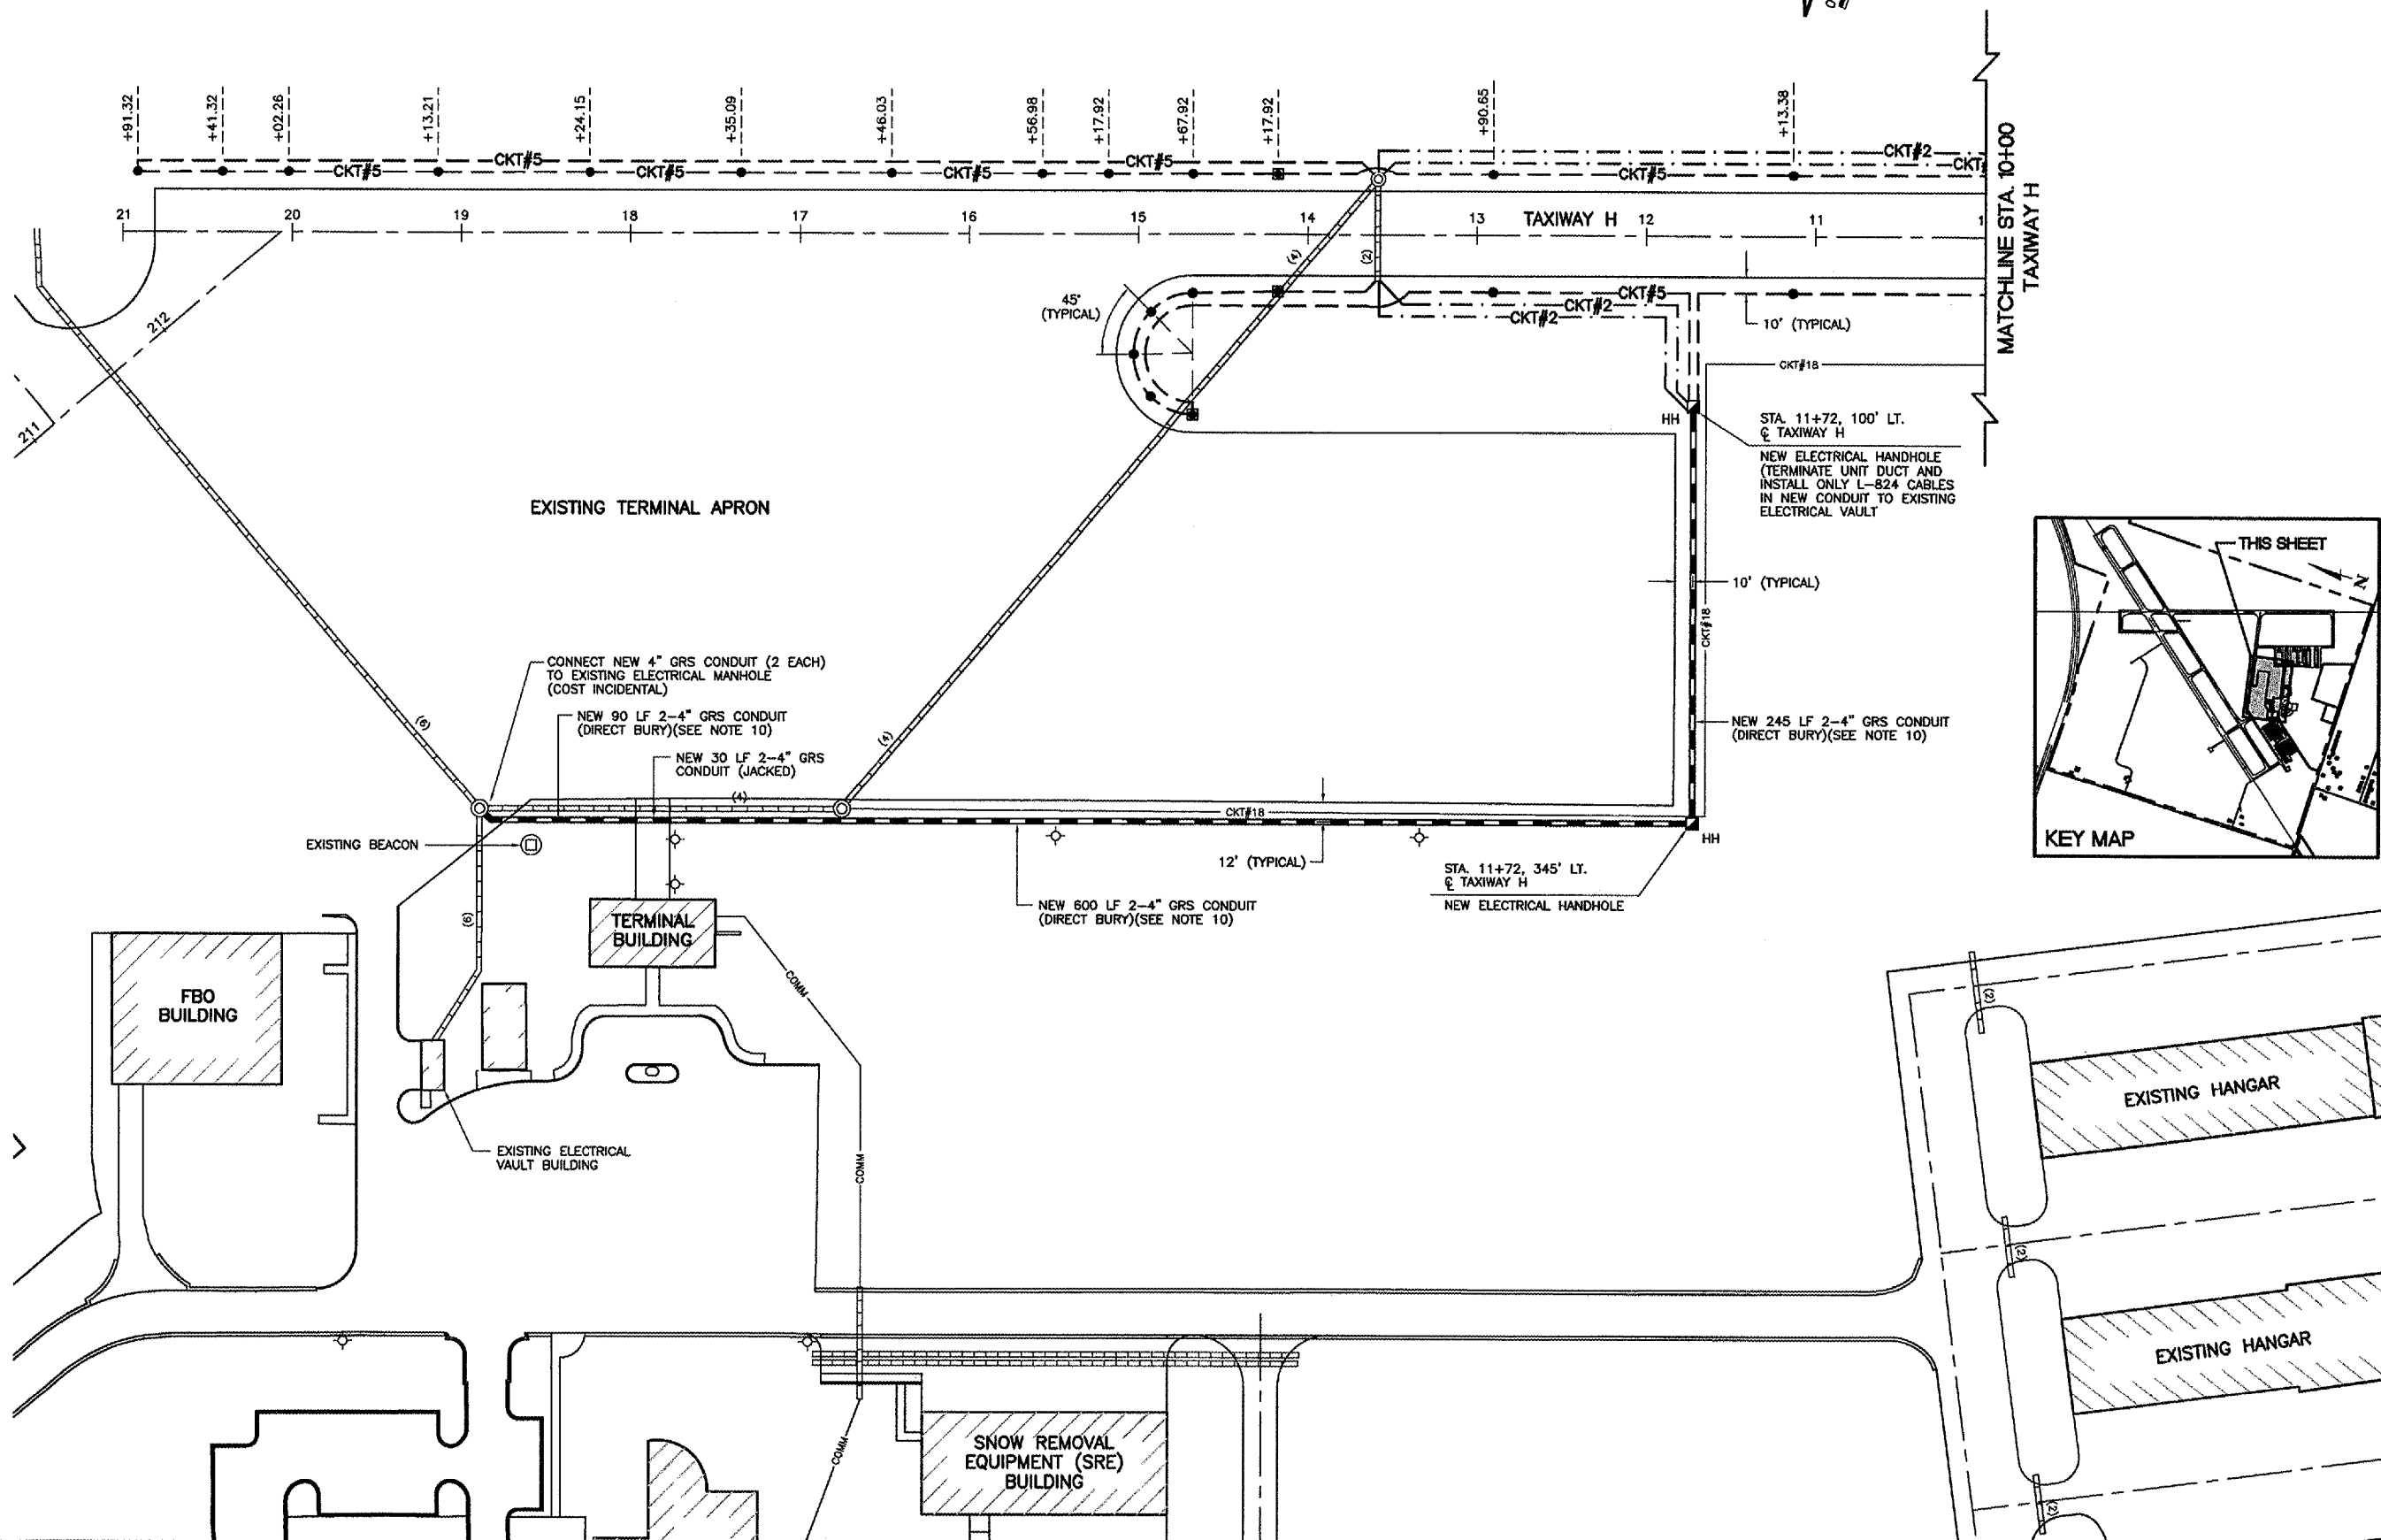 

**GREATER KANKAKEE AIRPORT
 KANKAKEE, ILLINOIS
 REHABILITATE AIRFIELD LIGHTING SYSTEM -
 RUNWAY 16/34 AND TAXIWAY H
 AIRFIELD LIGHTING PLAN
 TAXIWAY H
 STA. 10+00 TO STA. 21+00**

© Copyright CMT, Inc.
CMT
 CRAWFORD, MURPHY & TILLY, INC.
 CONSULTING ENGINEERS
 License No. 194-000613

DESIGN BY:	MND
DRAWN BY:	JRO
CHECKED BY:	MND
APPROVED BY:	
DATE:	02/28/08
JOB No:	07075-02
IL PROJECT:	IKK-3743
A.I.P. PROJECT:	3-17-0057-B13
SHEET 15 OF 17 SHEETS	