



BEGIN WORK
 CONTRACT 60R31
 STA. 3982+08

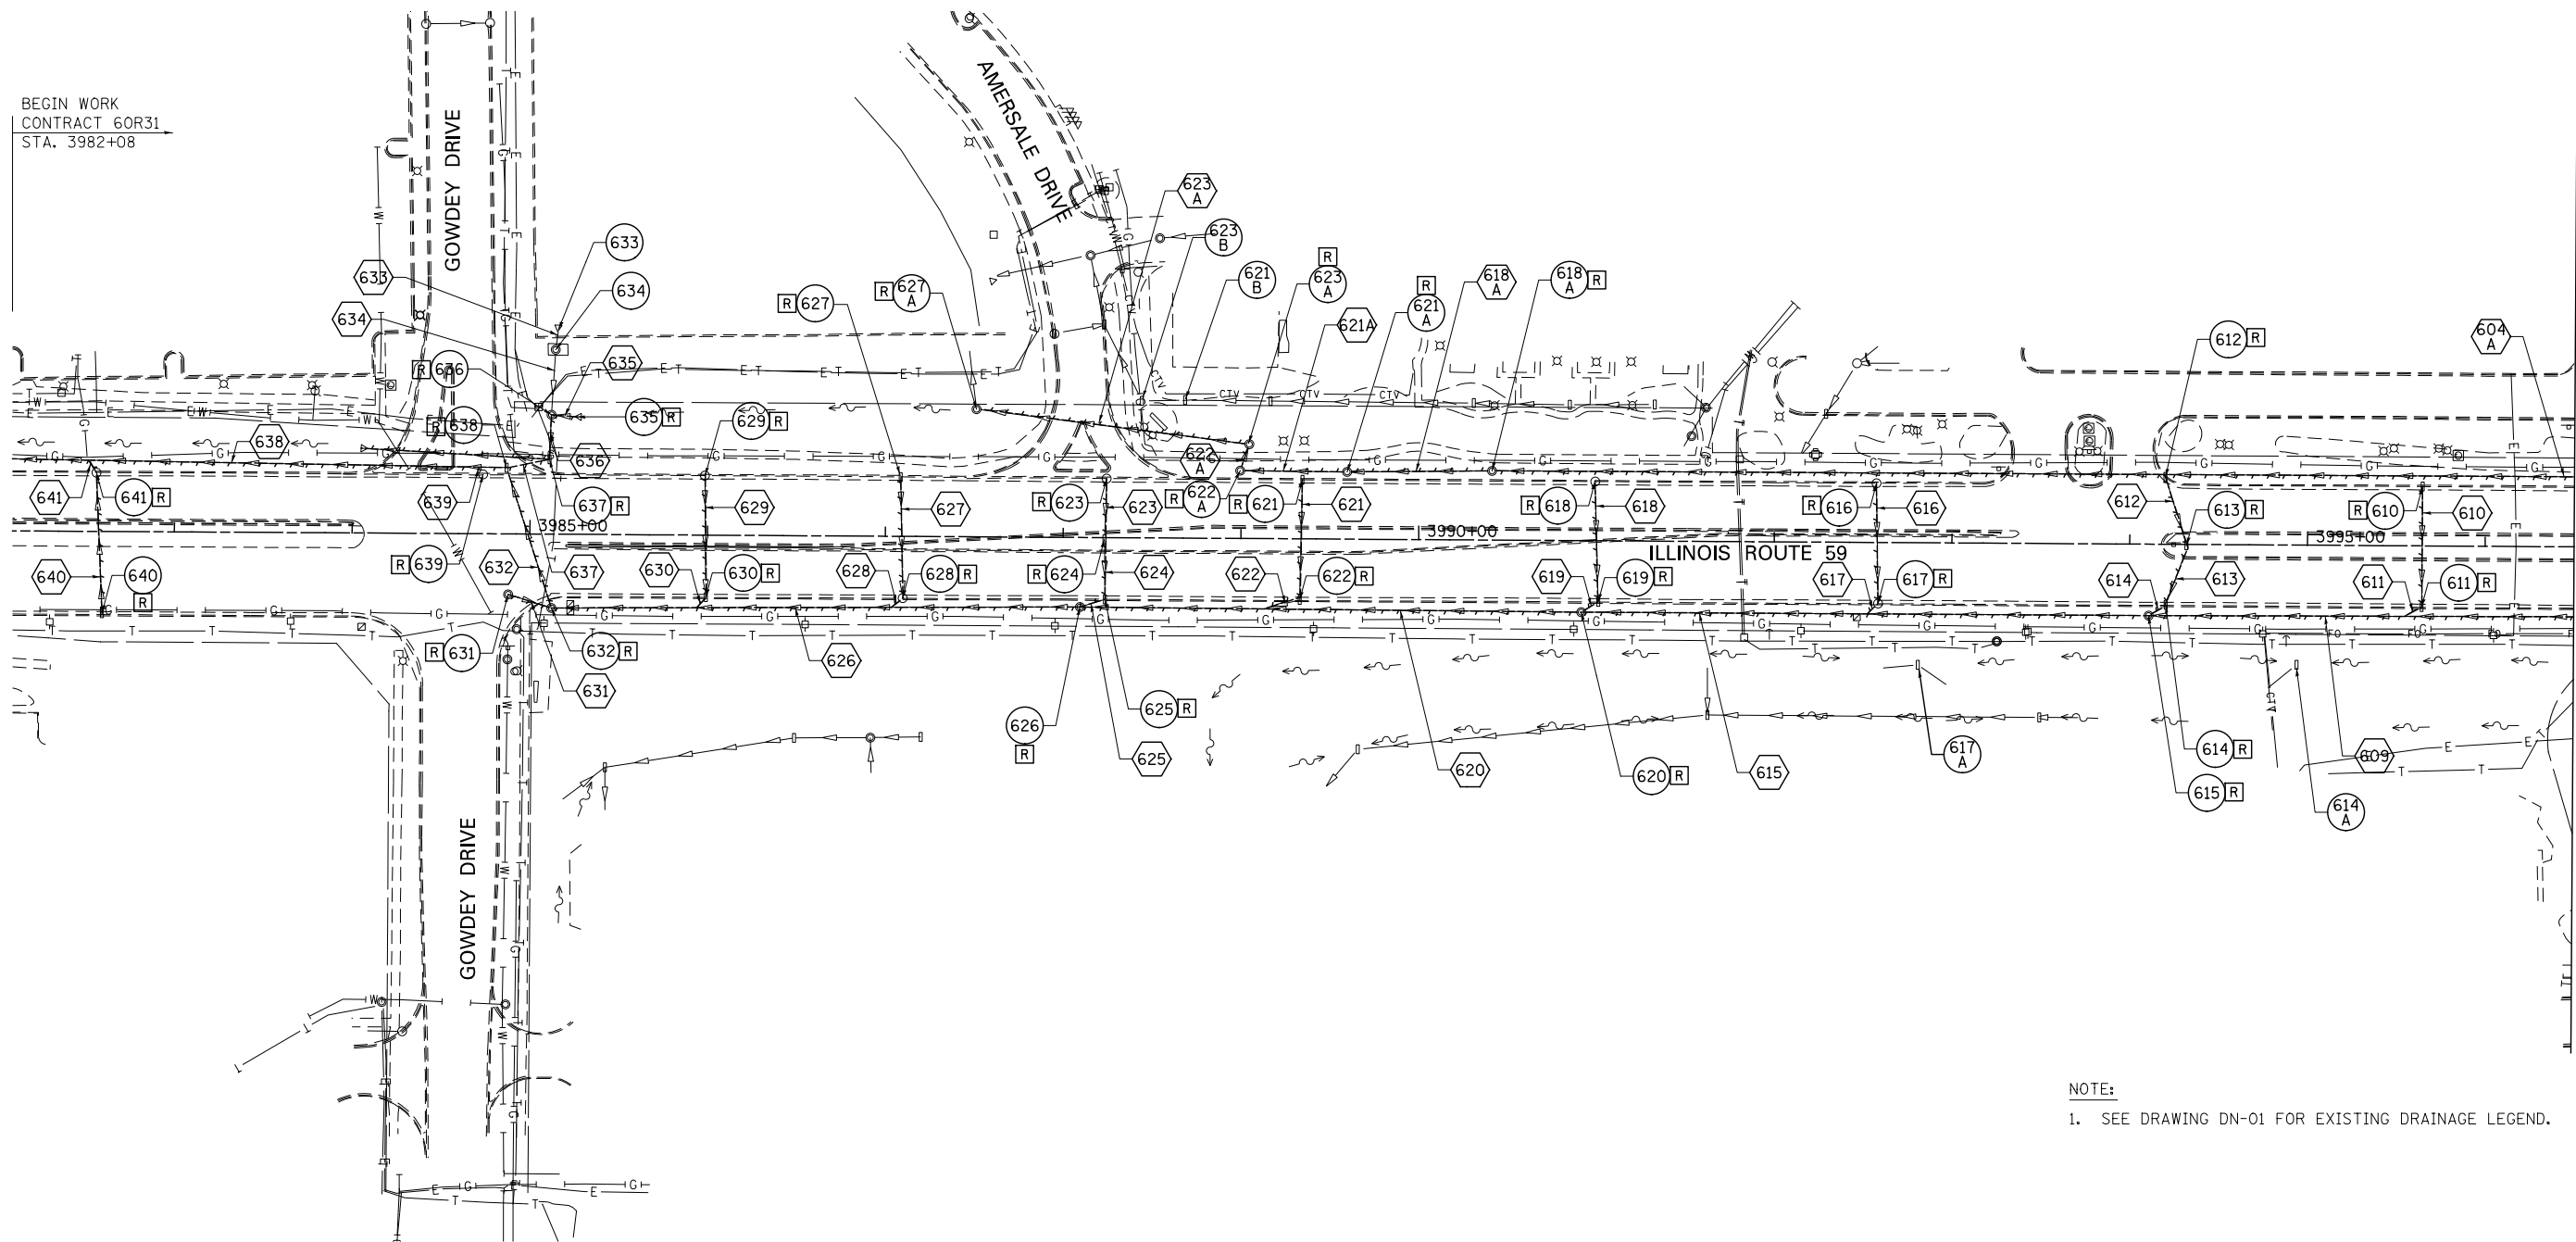

MATCH LINE STA. 3996+50
 SEE DRAWING DE-02

NOTE:
 1. SEE DRAWING DN-01 FOR EXISTING DRAINAGE LEGEND.

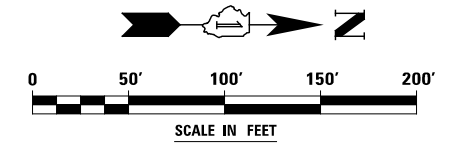

DESIGNED <i>PJO</i> DRAWN <i>KES</i> CHECKED <i>JCM</i> DATE <i>12/14/2012</i>	REVISED -	STATE OF ILLINOIS DEPARTMENT OF TRANSPORTATION	EXISTING DRAINAGE PLAN - ILLINOIS ROUTE 59		F.A.P. RTE. 338	SECTION (112 & 113) WRS-6	COUNTY DUPAGE	TOTAL SHEETS 734	SHEET NO. 289	
	REVISED -		SCALE: AS SHOWN	SHEET NO. 1 OF 9 SHEETS	STA. BEGIN TO STA. 3995+50	DE-01		CONTRACT NO. 60R31		
	REVISED -		ILLINOIS FED. AID PROJECT							
	REVISED -									