



END IMPRV. CONTRACT 60R30 STA. 3982+08
 BEGIN WORK CONTRACT 60R31 STA. 3982+08


END IMPRV. CONTRACT 60R30 STA. 3982+08
 BEGIN WORK CONTRACT 60R31 STA. 3982+08

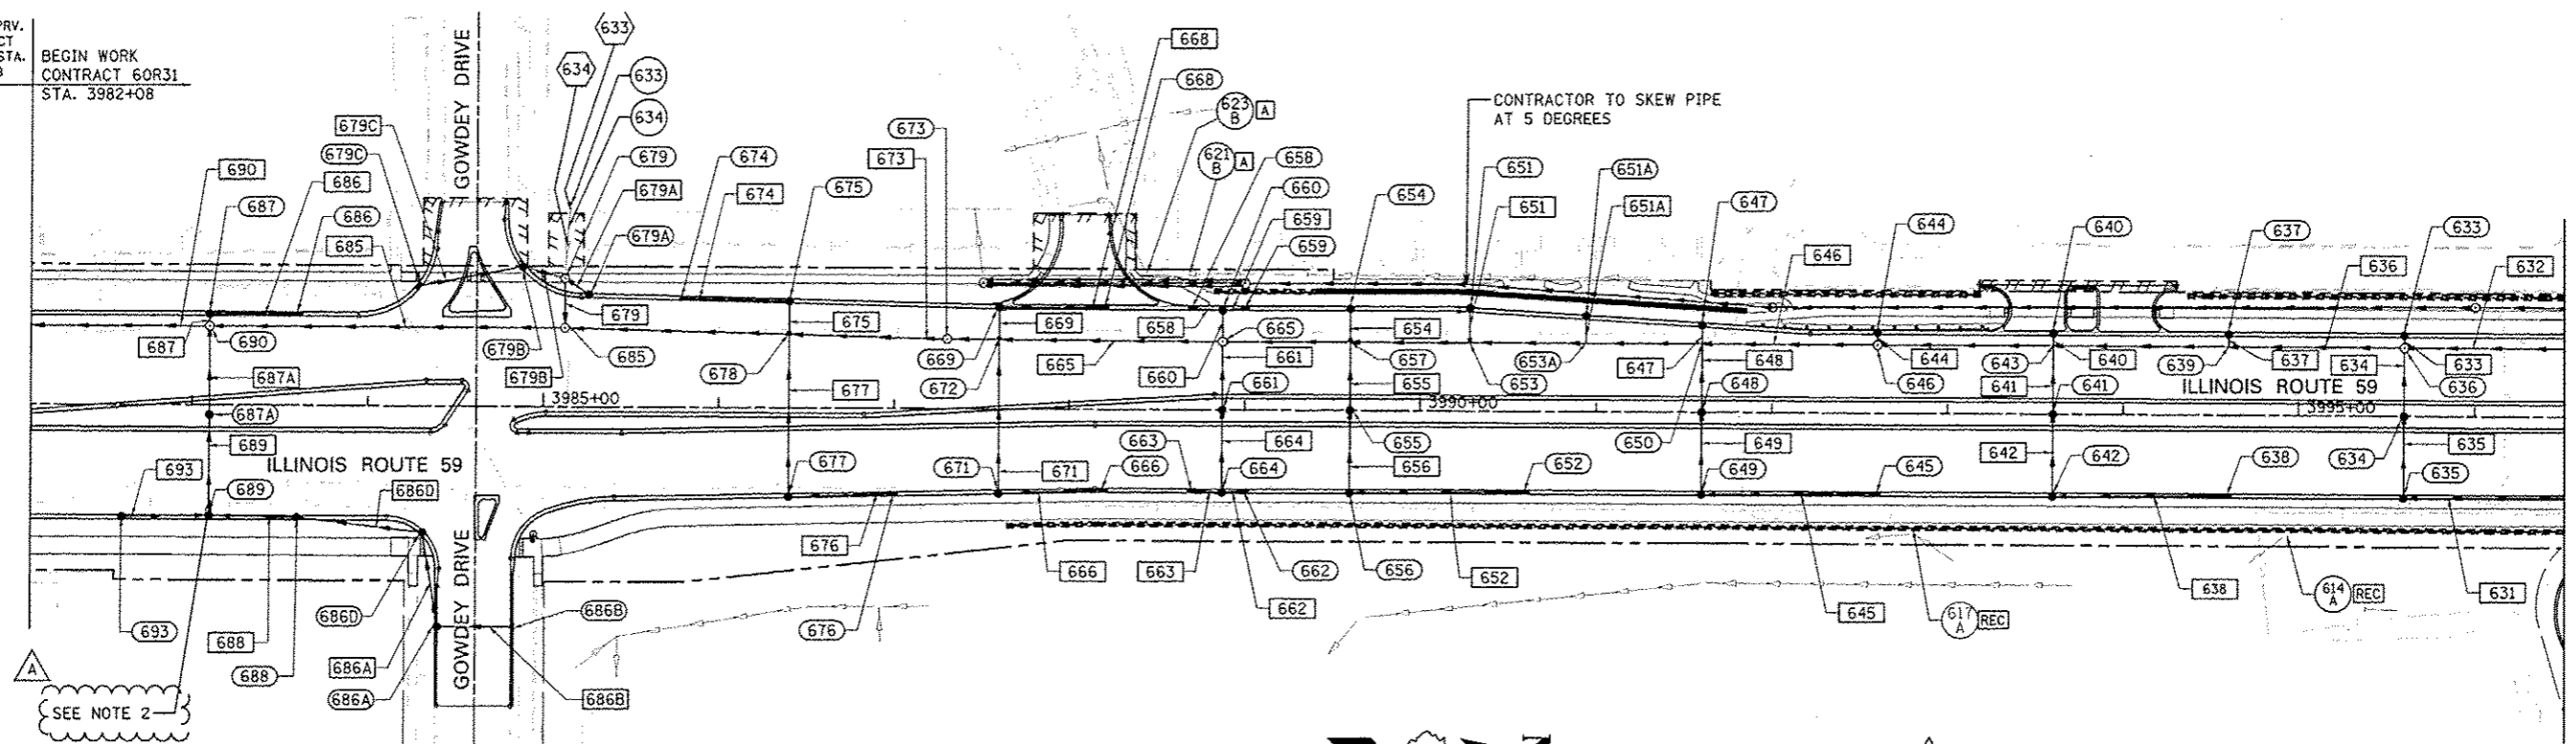

MATCH LINE STA. 3996+50
 SEE DRAWING DP-02A

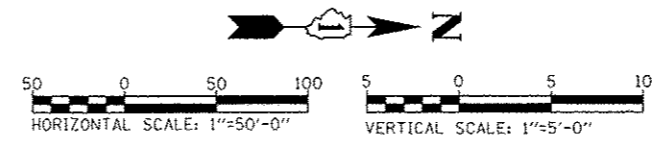

NOTE:
 1. SEE DRAWING DN-01 FOR DRAINAGE NOTES AND PROPOSED DRAINAGE LEGEND.
 2. AT&T UTILITY DUCT TO REMAIN

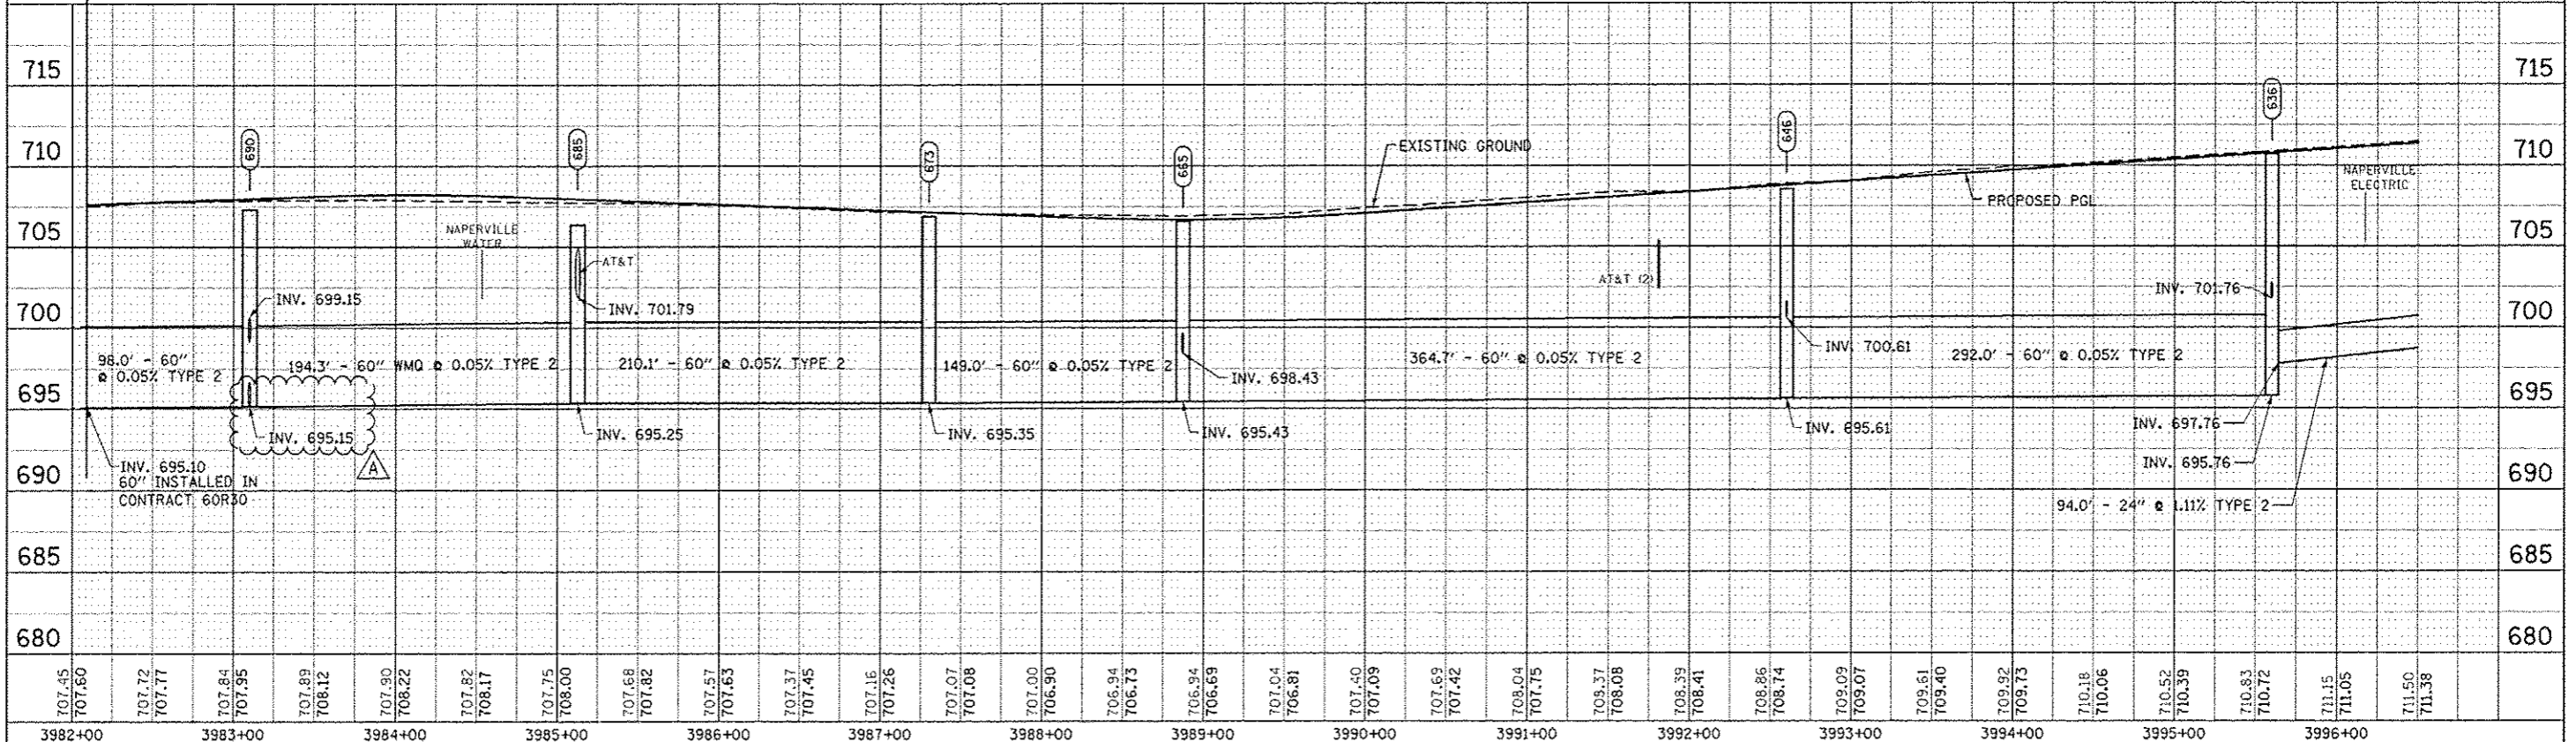

DESIGNED <i>JWM</i>	REVISED - ADDENDUM A 02/22/2013	STATE OF ILLINOIS DEPARTMENT OF TRANSPORTATION PROPOSED DRAINAGE PLAN & PROFILE - ILLINOIS ROUTE 59	F.A.P. RTE.	SECTION	COUNTY	TOTAL SHEETS	SHEET NO.
DRAWN <i>KES</i>	REVISED -		338	(112 & 113) WRS-7	DUPAGE	734	298
CHECKED <i>JRS</i>	REVISED -		DP-01A		CONTRACT NO. 60R31		
DATE <i>12/14/2012</i>	REVISED -		FED. ROAD DIST. NO. ILLINOIS FED. AID PROJECT				