
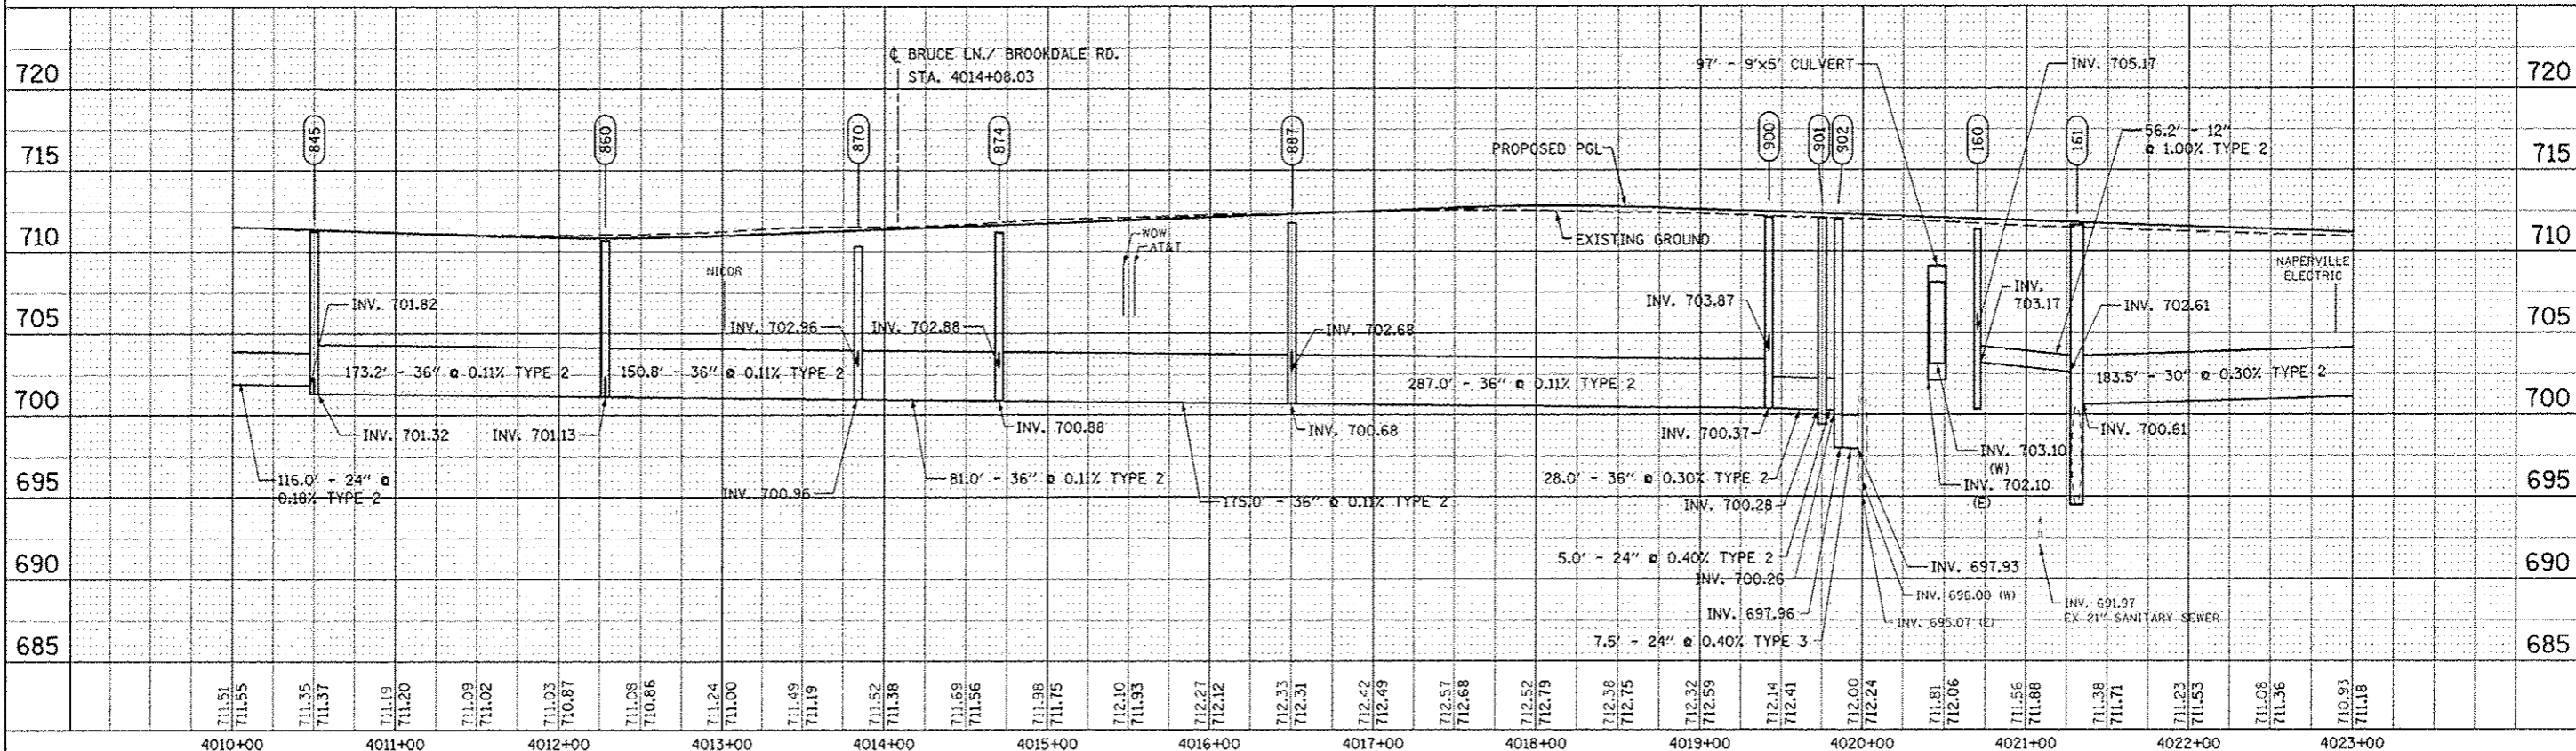


SN-022-0011					
PRECAST BOX CULVERT SCHEDULE (ASTM C 1577)					
STATION	SIZE (SPAN X HEIGHT)	SKEW	DESIGN FILL (FT.)		PGE BACKFILL REQUIRED
			MINIMUM	MAXIMUM	
4020+44.3	9' X 5'	SKEW	2.4'	3.8'	YES

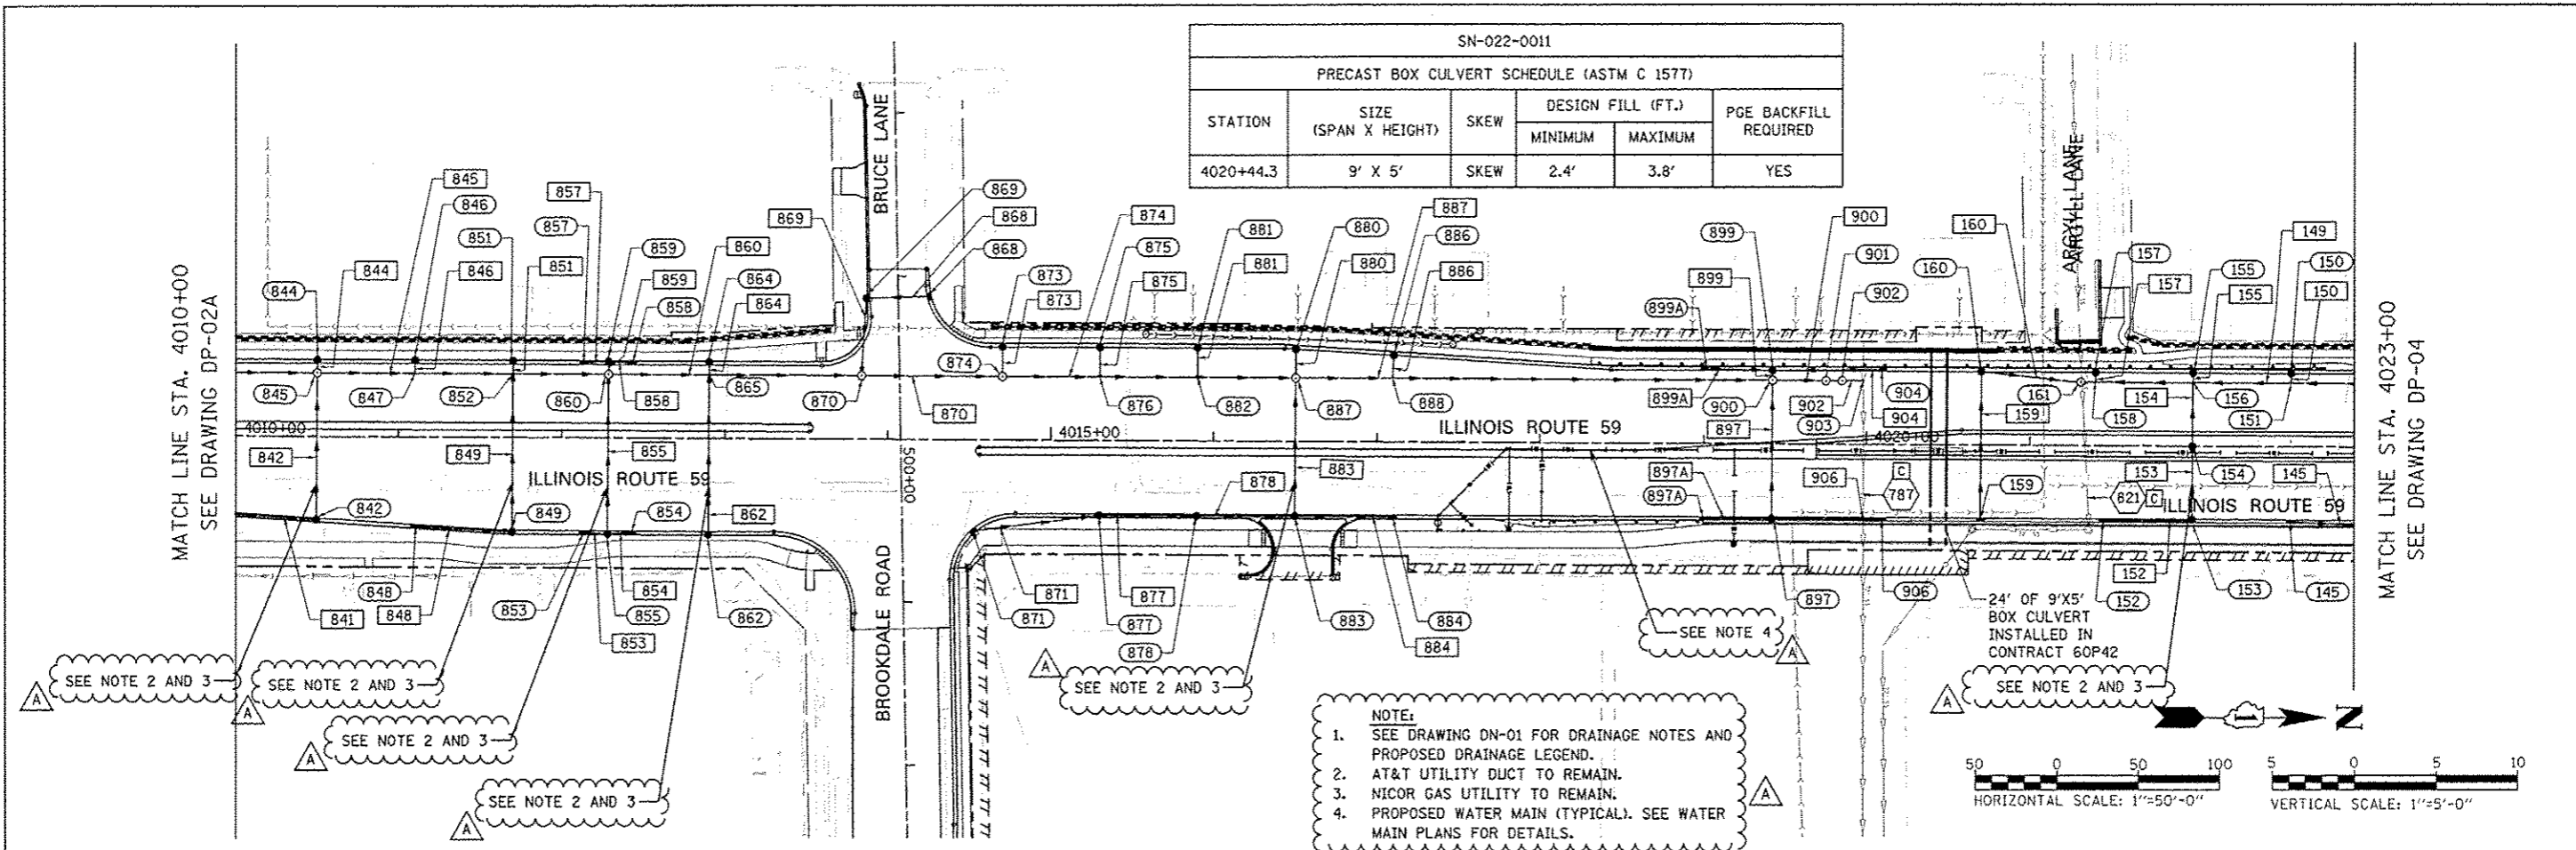

DATE	
SCALE	
PROJECT NO.	
NOTE BOOK NO.	
NO.	
FILE NAME	

DATE	
SCALE	
PROJECT NO.	
NOTE BOOK NO.	
NO.	
FILE NAME	

DESIGNED <i>JWM</i>	REVISED - ADDENDUM A 02/22/2013
DRAWN <i>RES</i>	REVISED -
CHECKED <i>JRS</i>	REVISED -
DATE <i>12/14/2012</i>	REVISED -

STATE OF ILLINOIS  
DEPARTMENT OF TRANSPORTATION

PROPOSED DRAINAGE PLAN & PROFILE - ILLINOIS ROUTE 59

F.A.P. RTE.	SECTION	COUNTY	TOTAL SHEETS	SHEET NO.
338	(112 & 113) WRS-7	DUPAGE	734	302
DP-03		CONTRACT NO. 60R31		
FED. ROAD DIST. NO. ILLINOIS FED. AID PROJECT				

SCALE: 1"=50' SHEET NO. 5 OF 11 SHEETS STA. 4010+00 TO STA. 4023+00