



DATE	
BY	
PROJECT	
NO.	
NO.	
NO.	
NO.	
NO.	

DATE	
BY	
PROJECT	
NO.	
NO.	
NO.	
NO.	
NO.	

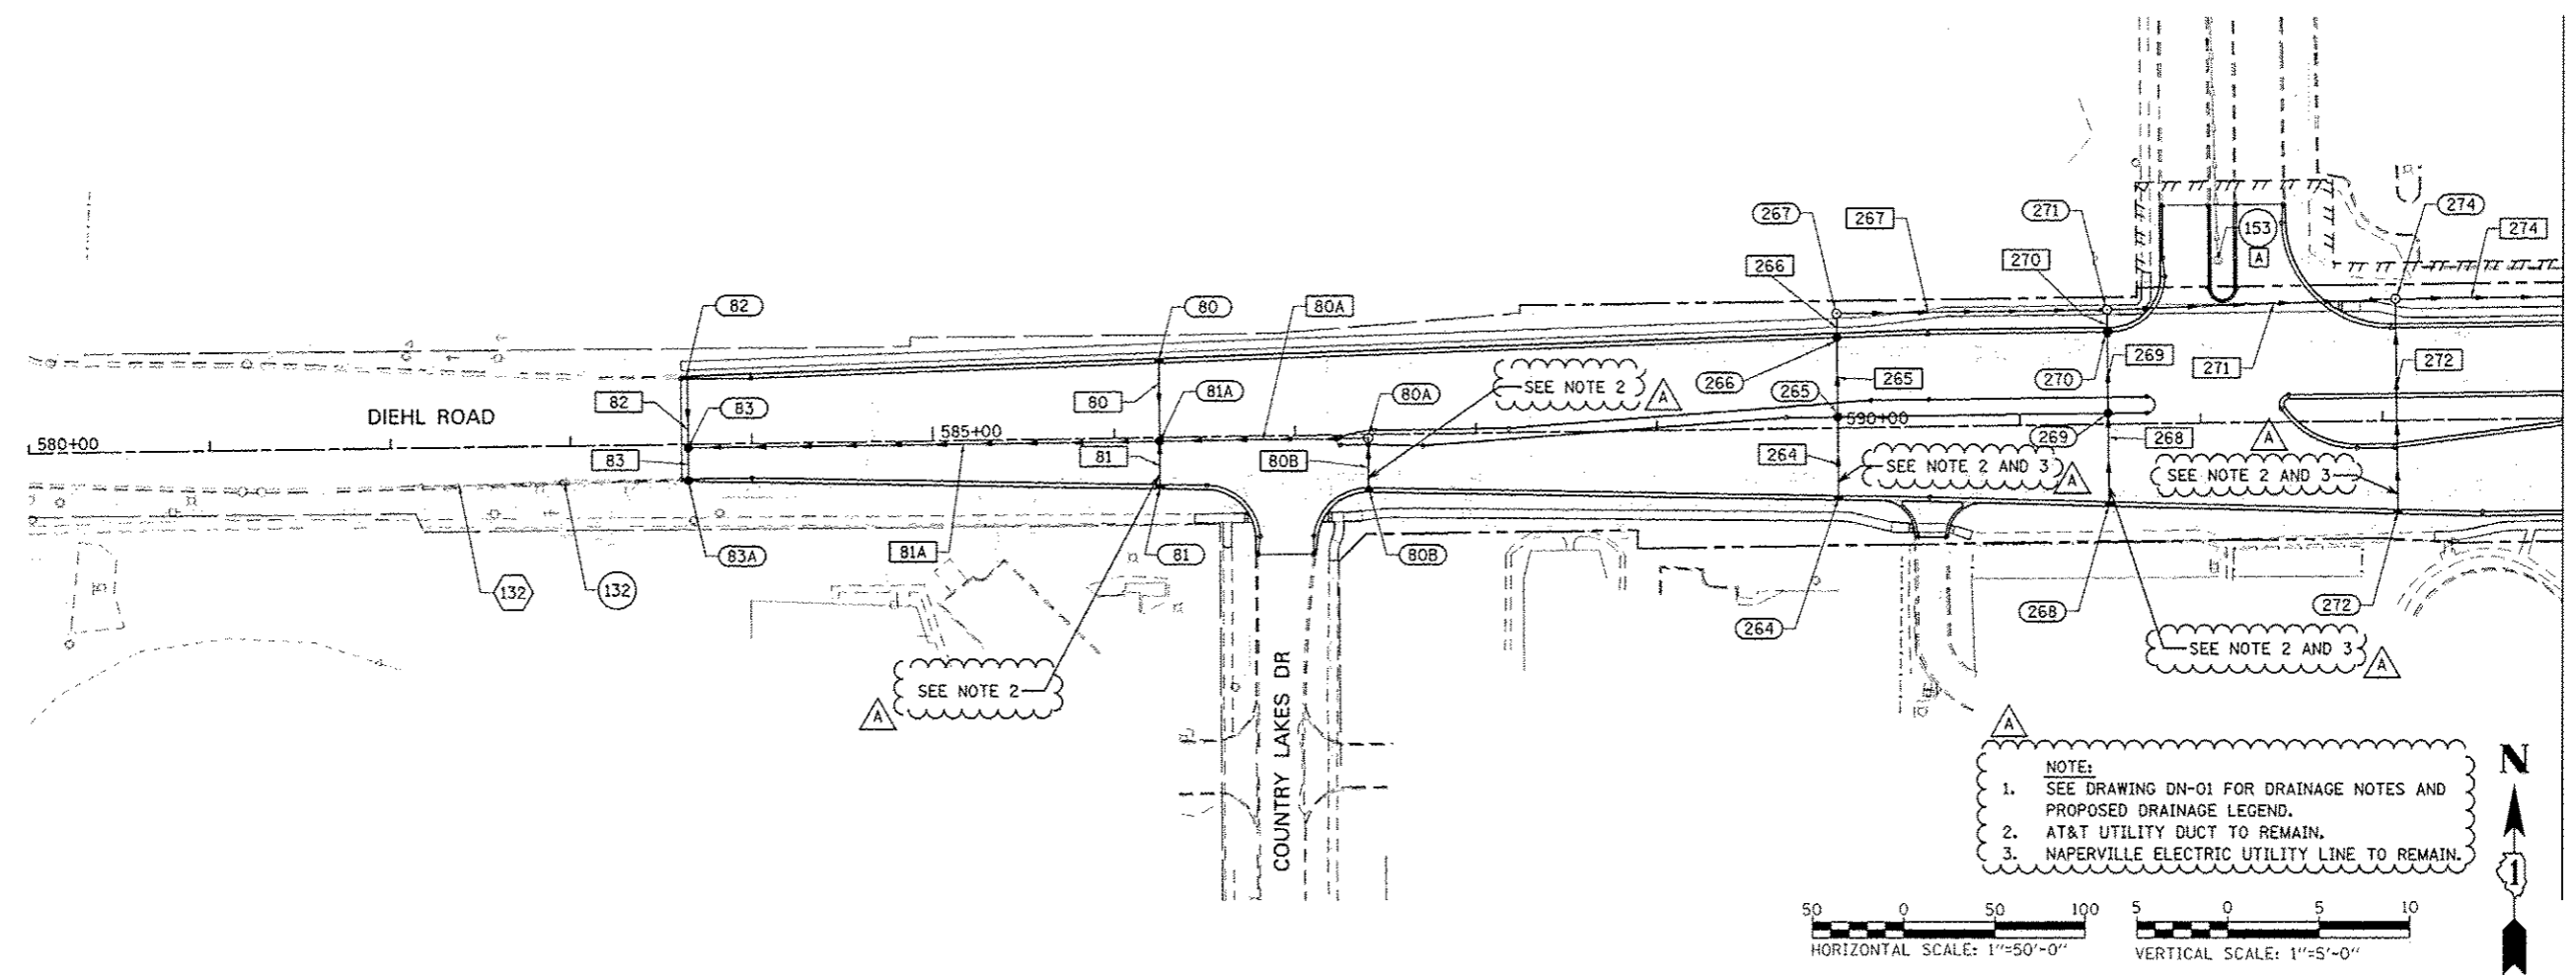

MATCH LINE STA. 594+00
SEE DRAWING DP-08

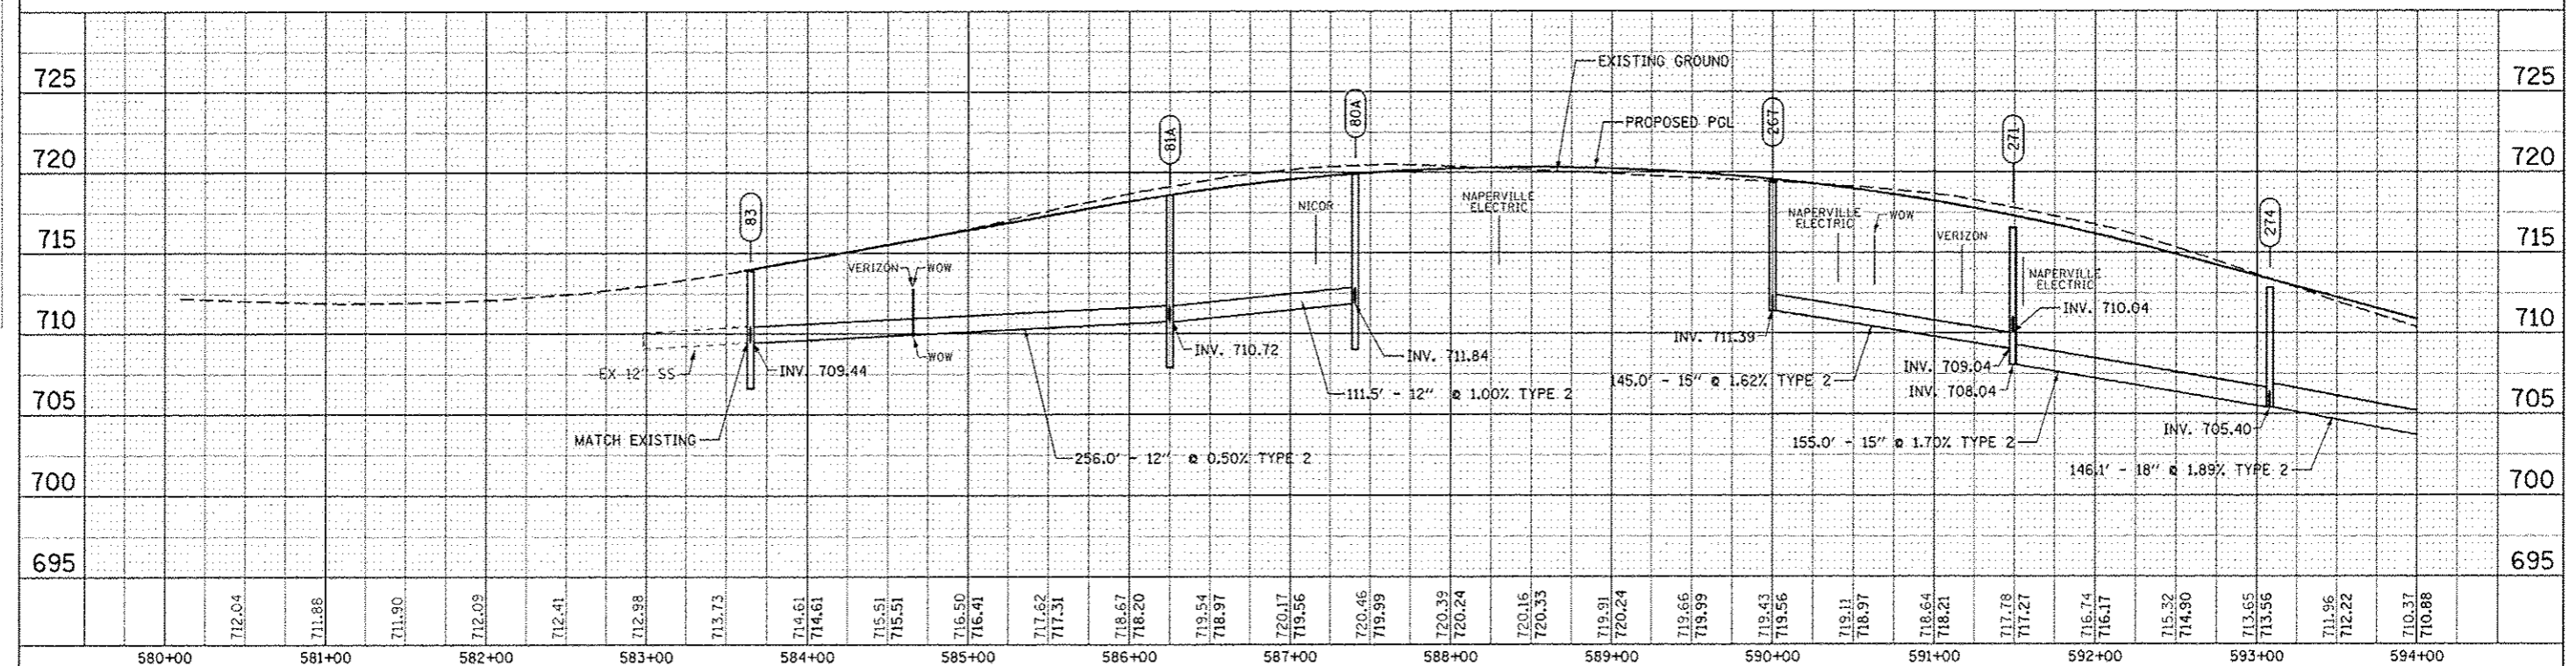

DESIGNED	JWH	REVISED	-ADDENDUM A 02/22/2013	F.A.P. RTE.	SECTION	COUNTY	TOTAL SHEETS	SHEET NO.
DRAWN	KE'S	REVISED	-	338	(112 & 113) WRS-7	DUPAGE	734	306
CHECKED	JRS	REVISED	-	DP-07		CONTRACT NO. 60R31		
DATE	12/11/2012	REVISED	-	SCALE: 1"=50'		SHEET NO. 9 OF 11 SHEETS STA. BEGIN TO STA. 594+00		

STATE OF ILLINOIS
DEPARTMENT OF TRANSPORTATION

PROPOSED DRAINAGE PLAN & PROFILE - DIEHL ROAD

F.A.P. RTE.	SECTION	COUNTY	TOTAL SHEETS	SHEET NO.
338	(112 & 113) WRS-7	DUPAGE	734	306
DP-07		CONTRACT NO. 60R31		
FED. ROAD DIST. NO. ILLINOIS FED. AID PROJECT				