
 
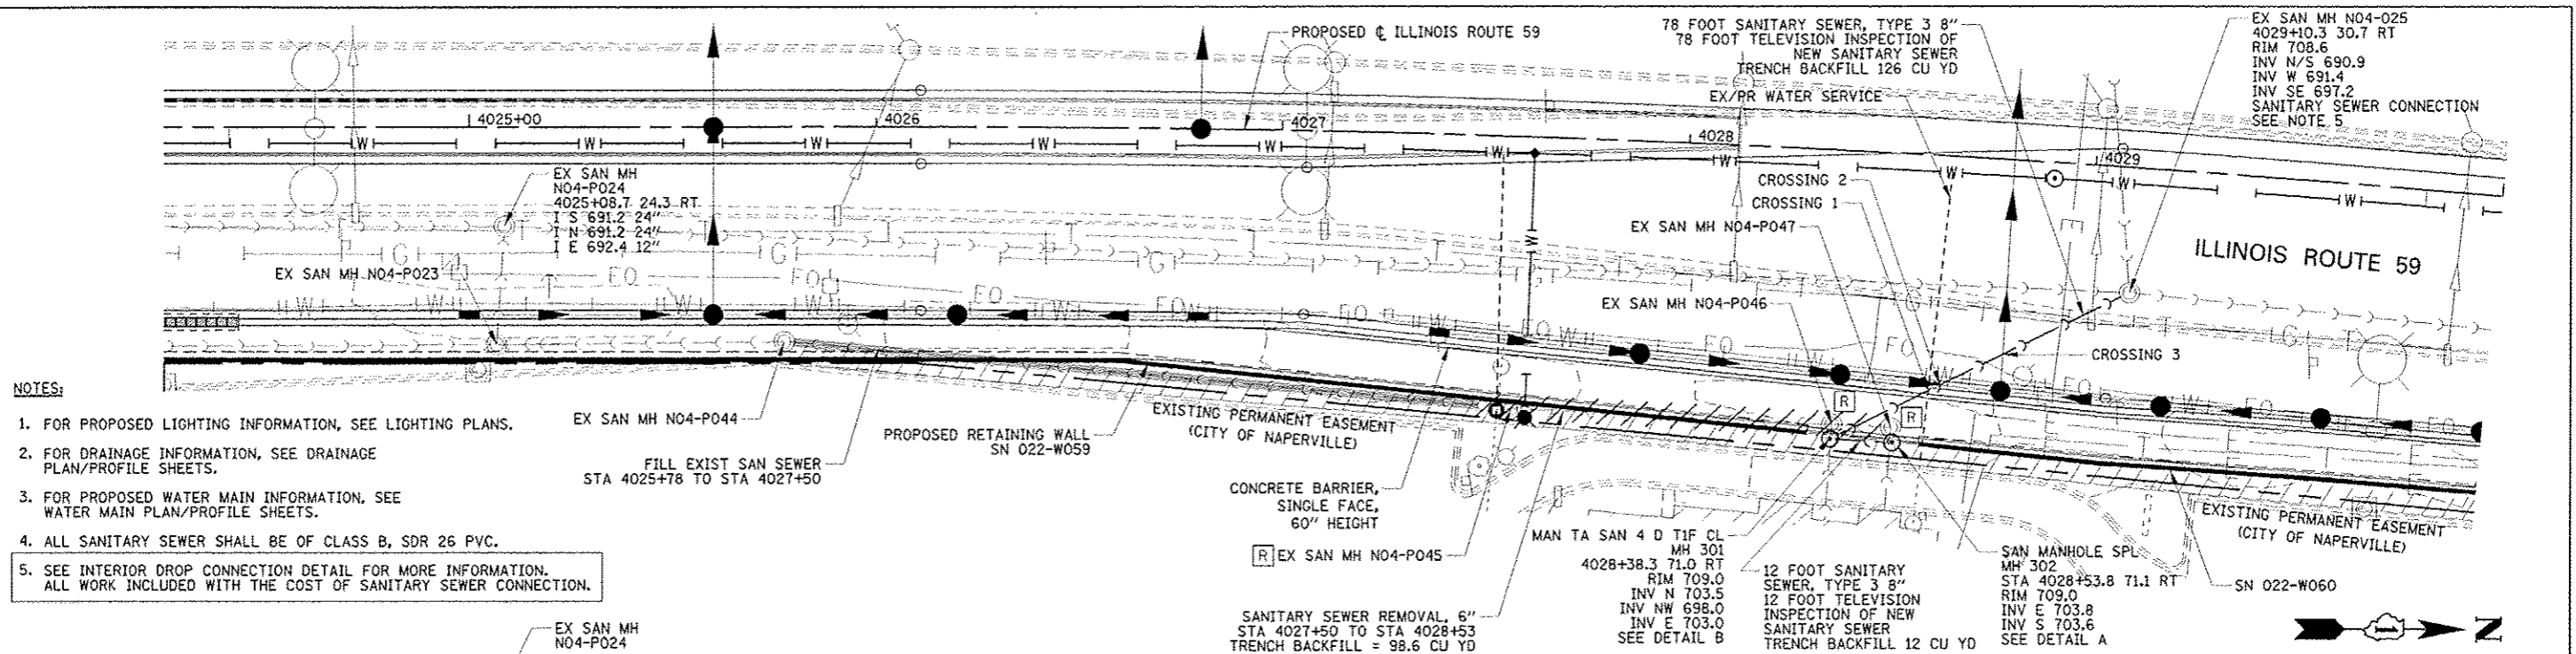


DATE	
BY	
CHECKED	
DESIGNED	
SCALE	
PROJECT	
SHEET	
TITLE	
NO.	
REVISED	
DATE	
BY	
CHECKED	
DESIGNED	
SCALE	
PROJECT	
SHEET	
TITLE	
NO.	



- NOTES:**
- FOR PROPOSED LIGHTING INFORMATION, SEE LIGHTING PLANS.
 - FOR DRAINAGE INFORMATION, SEE DRAINAGE PLAN/PROFILE SHEETS.
 - FOR PROPOSED WATER MAIN INFORMATION, SEE WATER MAIN PLAN/PROFILE SHEETS.
 - ALL SANITARY SEWER SHALL BE OF CLASS B, SDR 26 PVC.
 - SEE INTERIOR DROP CONNECTION DETAIL FOR MORE INFORMATION. ALL WORK INCLUDED WITH THE COST OF SANITARY SEWER CONNECTION.

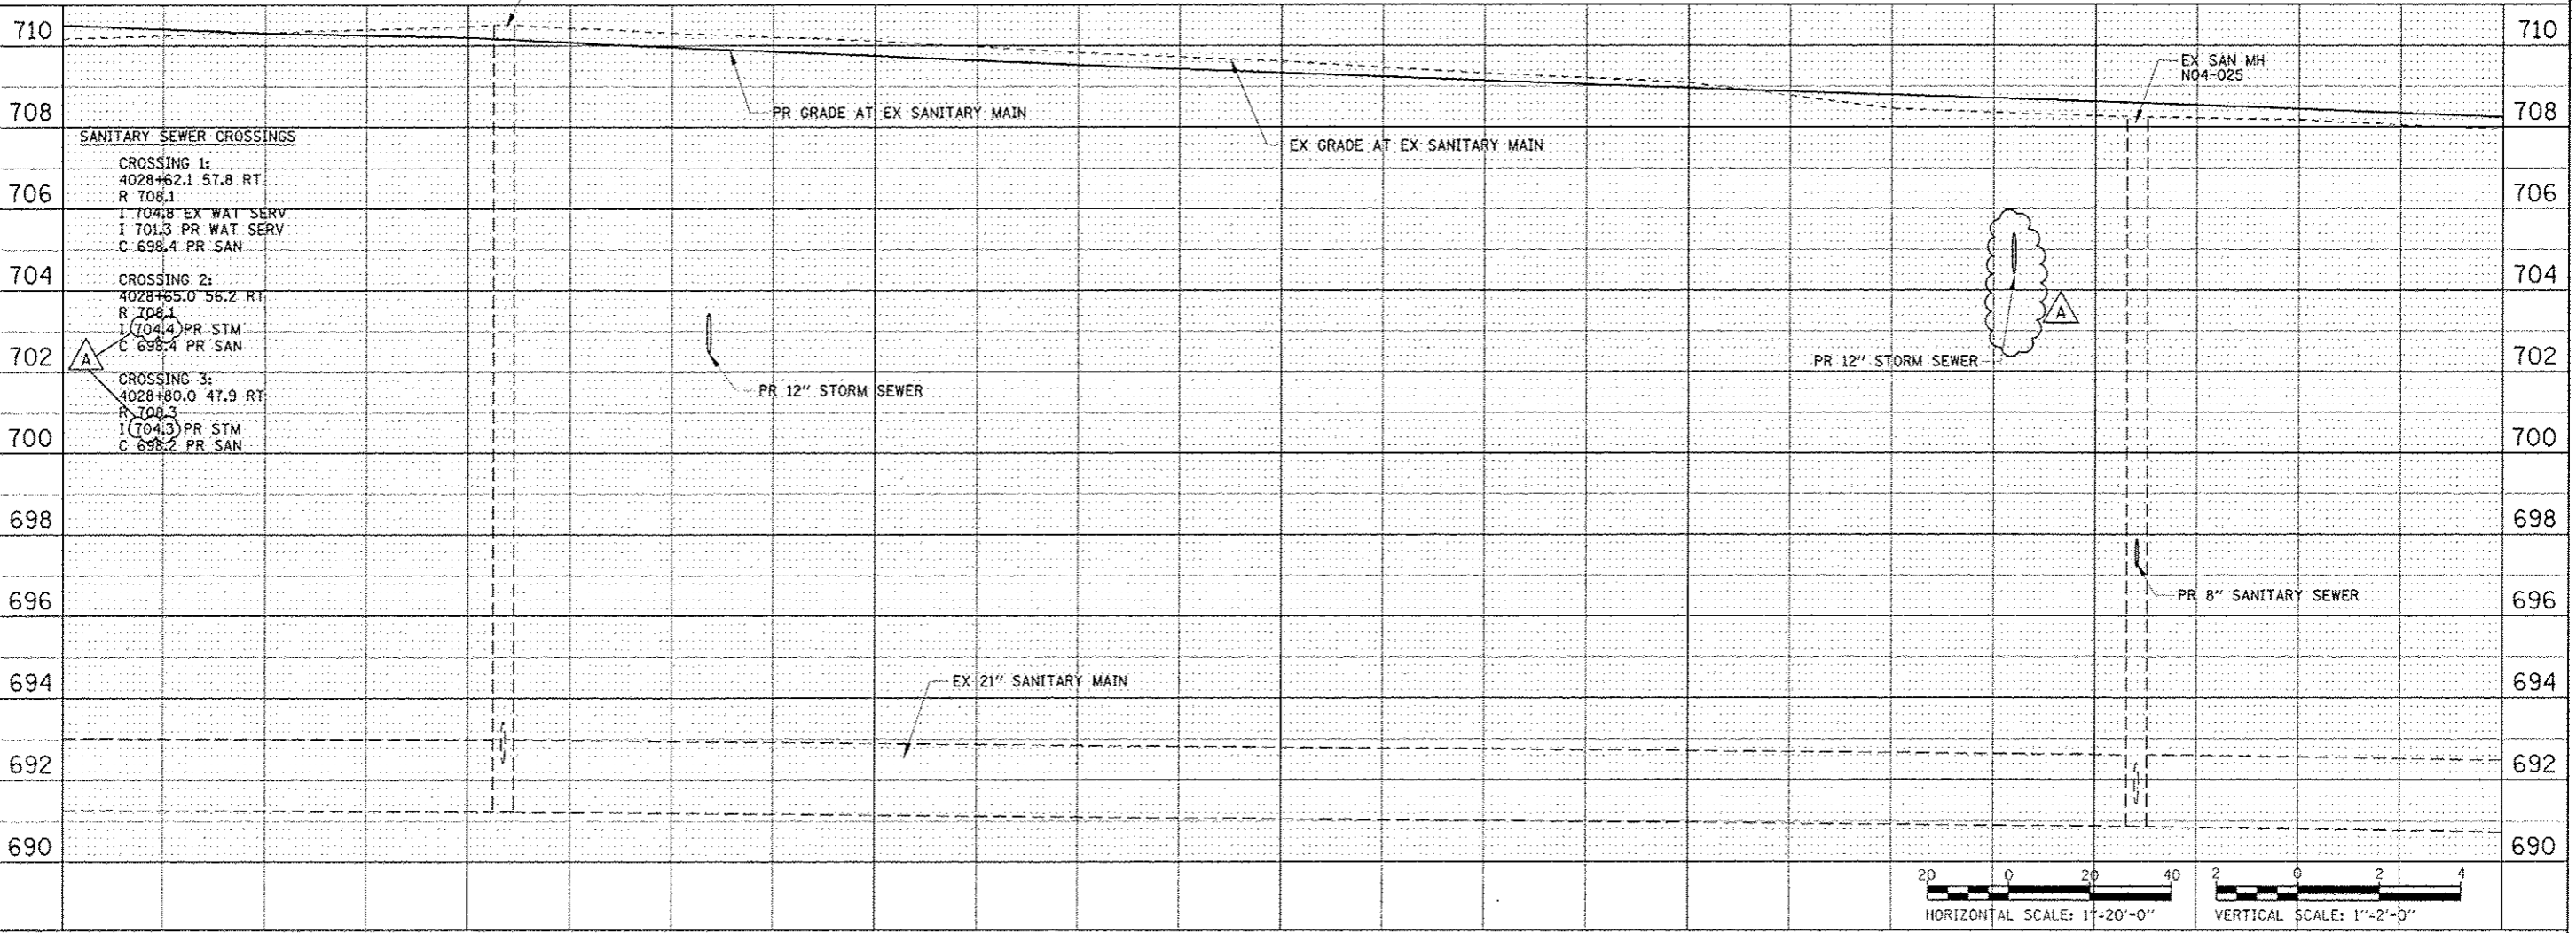

DESIGNED	PJO	REVISED - ADDENDUM A 02/22/2013	STATE OF ILLINOIS	SANITARY SEWER PLAN AND PROFILE	F.A.P. RTE.	SECTION	COUNTY	TOTAL SHEETS	SHEET NO.
DRAWN	KES	REVISED -	DEPARTMENT OF TRANSPORTATION	SCALE: AS SHOWN SHEET NO. 2 OF 2 SHEETS STA. 4024+25 TO STA. 4030+00	338	(112 & 113) WRS-6	DUPAGE	734	331
CHECKED	JCM	REVISED -			SAN PP-2		CONTRACT NO. 60R31		
DATE	12/14/2012	REVISED -			REG. ROAD DIST. NO. ILLINOIS FED. AID PROJECT				