
 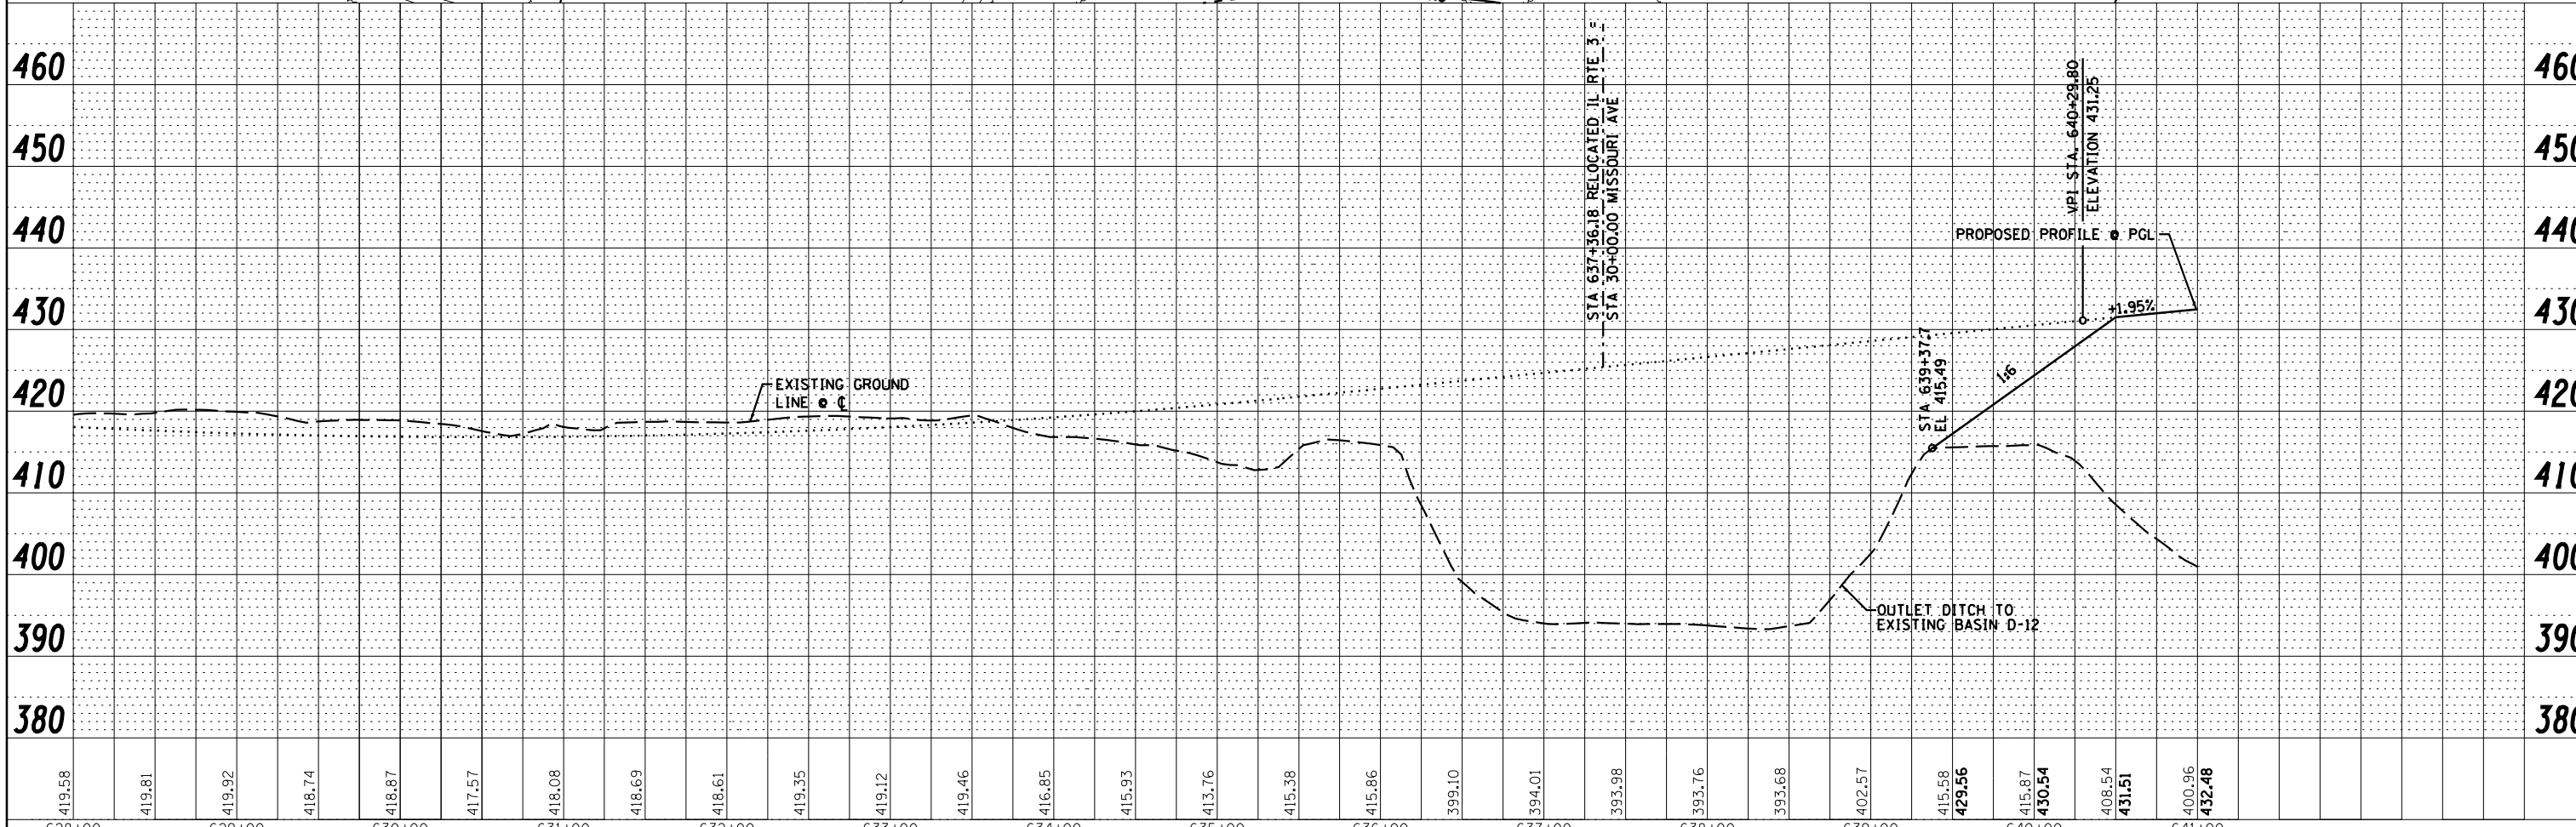



PLAN	SURVEYED	BY	DATE
	PLOTTED		
	ALIGNED		
	CHECKED		
	FILED		
	NO.		

PROFILE	SURVEYED	BY	DATE
	PLOTTED		
	GRADES		
	CHECKED		
	STRUCTURE		
	NOTATIONS		
	CHKD		
	NO.		

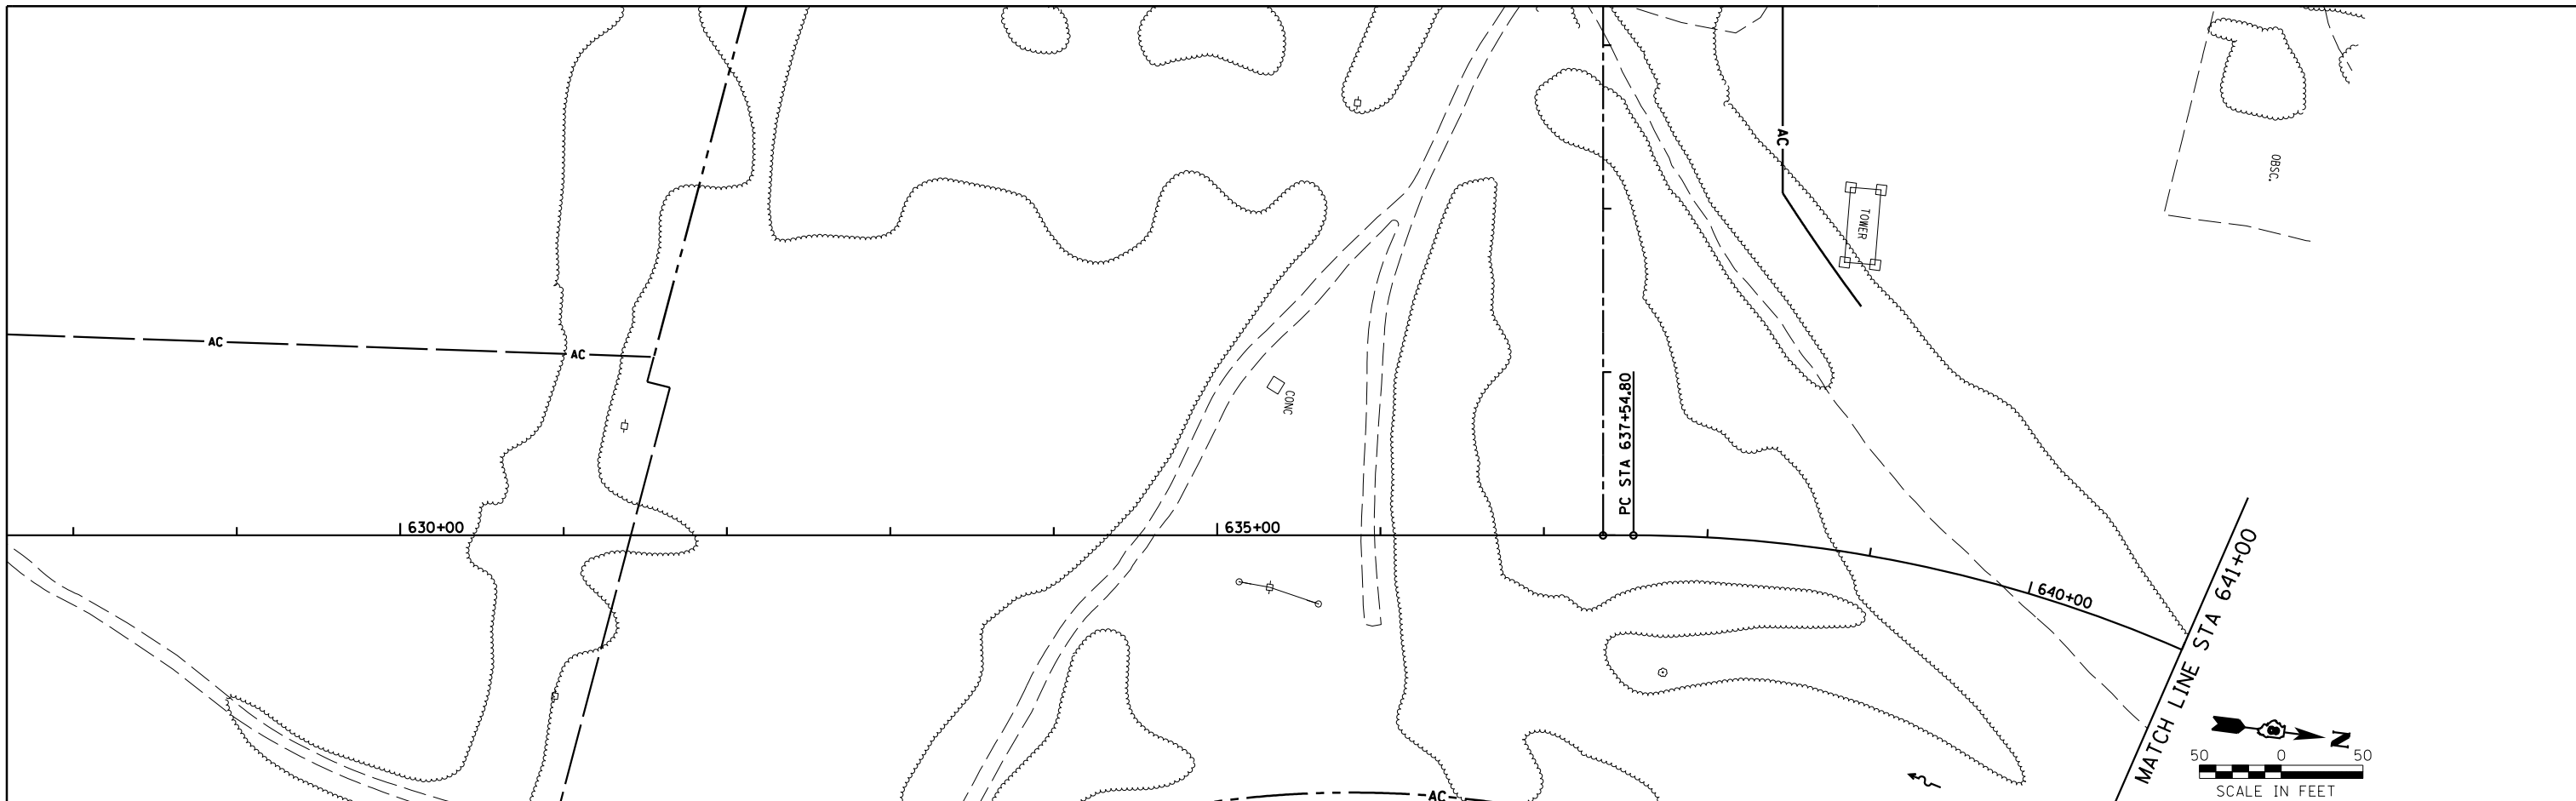

419.58	419.81	419.92	418.74	418.87	417.57	418.08	418.69	418.61	419.35	419.12	419.46	416.85	415.93	413.76	415.38	415.86	399.10	394.01	393.98	393.76	393.68	402.57	415.58	429.56	415.87	430.54	408.54	431.51	400.96	432.48	
628+00	629+00	630+00	631+00	632+00	633+00	634+00	635+00	636+00	637+00	638+00	639+00	640+00	641+00																		

**Farnsworth GROUP, INC.**  
2709 McGraw Drive  
Bloomington, Illinois 61704  
309/663-8435, 309/663-1571 fax

USER NAME = dmeyer	DESIGNED - JJ0	REVISED -
	DRAWN - JJ0	REVISED - 03/15/13
PLOT SCALE = 100.0000' / 1"	CHECKED - PJM	REVISED -
PLOT DATE = 3/15/2013	DATE - 12/10/12	REVISED -

**STATE OF ILLINOIS  
DEPARTMENT OF TRANSPORTATION**

**DRAINAGE PLAN & PROFILE**

SCALE: SHEET NO. OF SHEETS STA. TO STA.

F.A.P. RTE.	SECTION	COUNTY	TOTAL SHEETS	SHEET NO.
788	520-1-2HVB, 520-1-2HVB-1	ST. CLAIR	237	32
CONTRACT NO. 76848				
ILLINOIS FED. AID PROJECT				