



F.A.I. RTE.	SECTION	COUNTY	TOTAL SHEETS	SHEET NO.
94	*	COOK	36	22
STA. 103+00		TO STA. 116+00		
FED. ROAD DIST. NO.	ILLINOIS FED. AID PROJECT			
* 2005-014L				62937

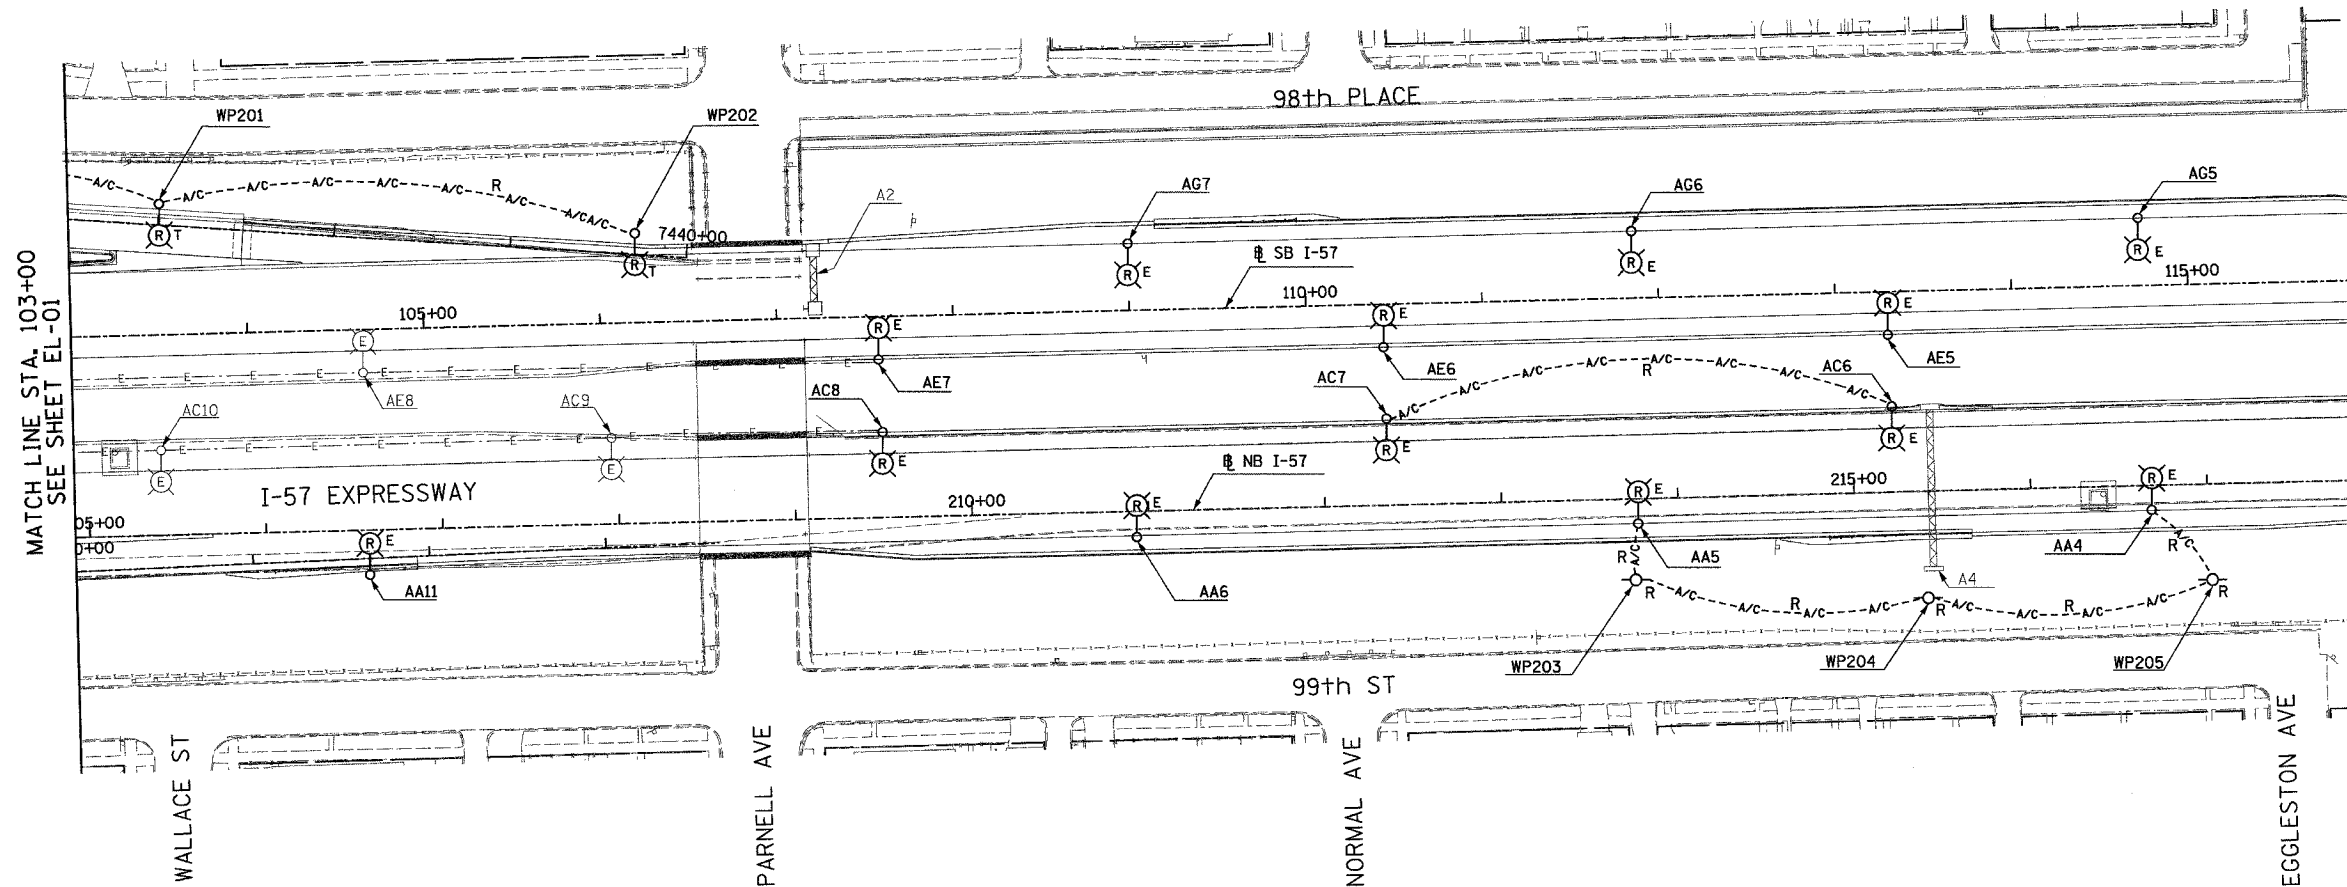

MATCH LINE STA. 103+00  
SEE SHEET EL-01

- LEGEND**
- EXISTING LIGHTING UNIT TO REMAIN
  - EXISTING LIGHTING CIRCUIT
  - AERIAL CABLE TO BE REMOVED
  - TEMPORARY LIGHTING UNIT TO BE REMOVED
  - EXISTING LIGHTING UNIT TO BE REMOVED
  - EXISTING WOOD POLE TO BE REMOVED

 - NOTES:**
1. UNLESS NOTED OTHERWISE, ALL ITEMS AND WORK SHOWN IN HEAVY LINE WEIGHT ON THIS DRAWING ARE PROPOSED NEW ITEMS OF WORK.
  2. COORDINATE ALL WORK WITH IDOT ELECTRICAL CONTRACT 62583 AND CIVIL CONTRACTS 62694, 62695, 62304 AND 62593.
  3. REMOVAL OF LIGHT POLES, WOOD POLES AND LUMINAIRES IS PART OF CONTRACT 62937. FOUNDATION REMOVAL WILL BE DONE UNDER SEPARATE CONTRACT.



2D/EL-02

REVISIONS	
NAME	DATE

ILLINOIS DEPARTMENT OF TRANSPORTATION  
F.A.I. 94 (DAN RYAN EXPRESSWAY)

ROADWAY LIGHTING PLANS  
EXISTING AND REMOVAL

SCALE: 1"=50'      DRAWN BY: VG  
DATE: JANUARY 13, 2006      CHECKED BY: TM

**SINGH** 300 W. ADAMS ST.  
SINGH & ASSOCIATES, INC. CHICAGO, IL 60606  
CONSULTING ENGINEERS TEL: (312) 629-0240  
FAX: (312) 629-8449

1/11/2006 12:44:32 PM