


F.A.I. RTE.	SECTION	COUNTY	TOTAL SHEETS	SHEET NO.
94		COOK	36	27
STA. 116+00.00		TO STA. 129+00		
FED. ROAD DIST. NO.		ILLINOIS FED. AID PROJECT		
• 2005-014L		62937		



- LEGEND**
- HIGH MAST LIGHT TOWERS (PROVIDED UNDER SEPARATE CONTRACT)
 - EXISTING HANDHOLE (PROVIDED UNDER THE SEPARATE CONTRACT)
 - UNDERGROUND REINFORCED CONCRETE ENCASED CNC DUCTBANK. (PROVIDED UNDER SEPARATE CONTRACT).
 - JUNCTION BOX: TYPE AND SIZE AS INDICATED ON PLANS
 - DIRECT BURIAL CABLE UNDERGROUND WITHOUT ENCASEMENT

- NOTES:**
1. UNLESS NOTED OTHERWISE ALL ITEMS AND WORK SHOWN IN HEAVY LINE WEIGHT ON THIS DRAWING ARE PROPOSED NEW ITEMS OF WORK.
 2. SPLICE UNIT DUCT CABLES TO FEEDERS PROVIDED UNDER SEPARATE CONTRACT IN HIGH MAST TOWER.
 3. MOUNT JUNCTION BOX TO ABUTMENT OR PIER IN ACCORDANCE WITH DETAIL SHOWN ON SHEET 2D/RL-08. ROUTE UNITDUCT TO JUNCTION BOX AND SEAL FOR UNDERPASS LIGHTING TO BE PROVIDED UNDER SEPARATE CONTRACT. SPLICE MEDIAN LIGHTING TO UNIT DUCT IN JUNCTION BOX.

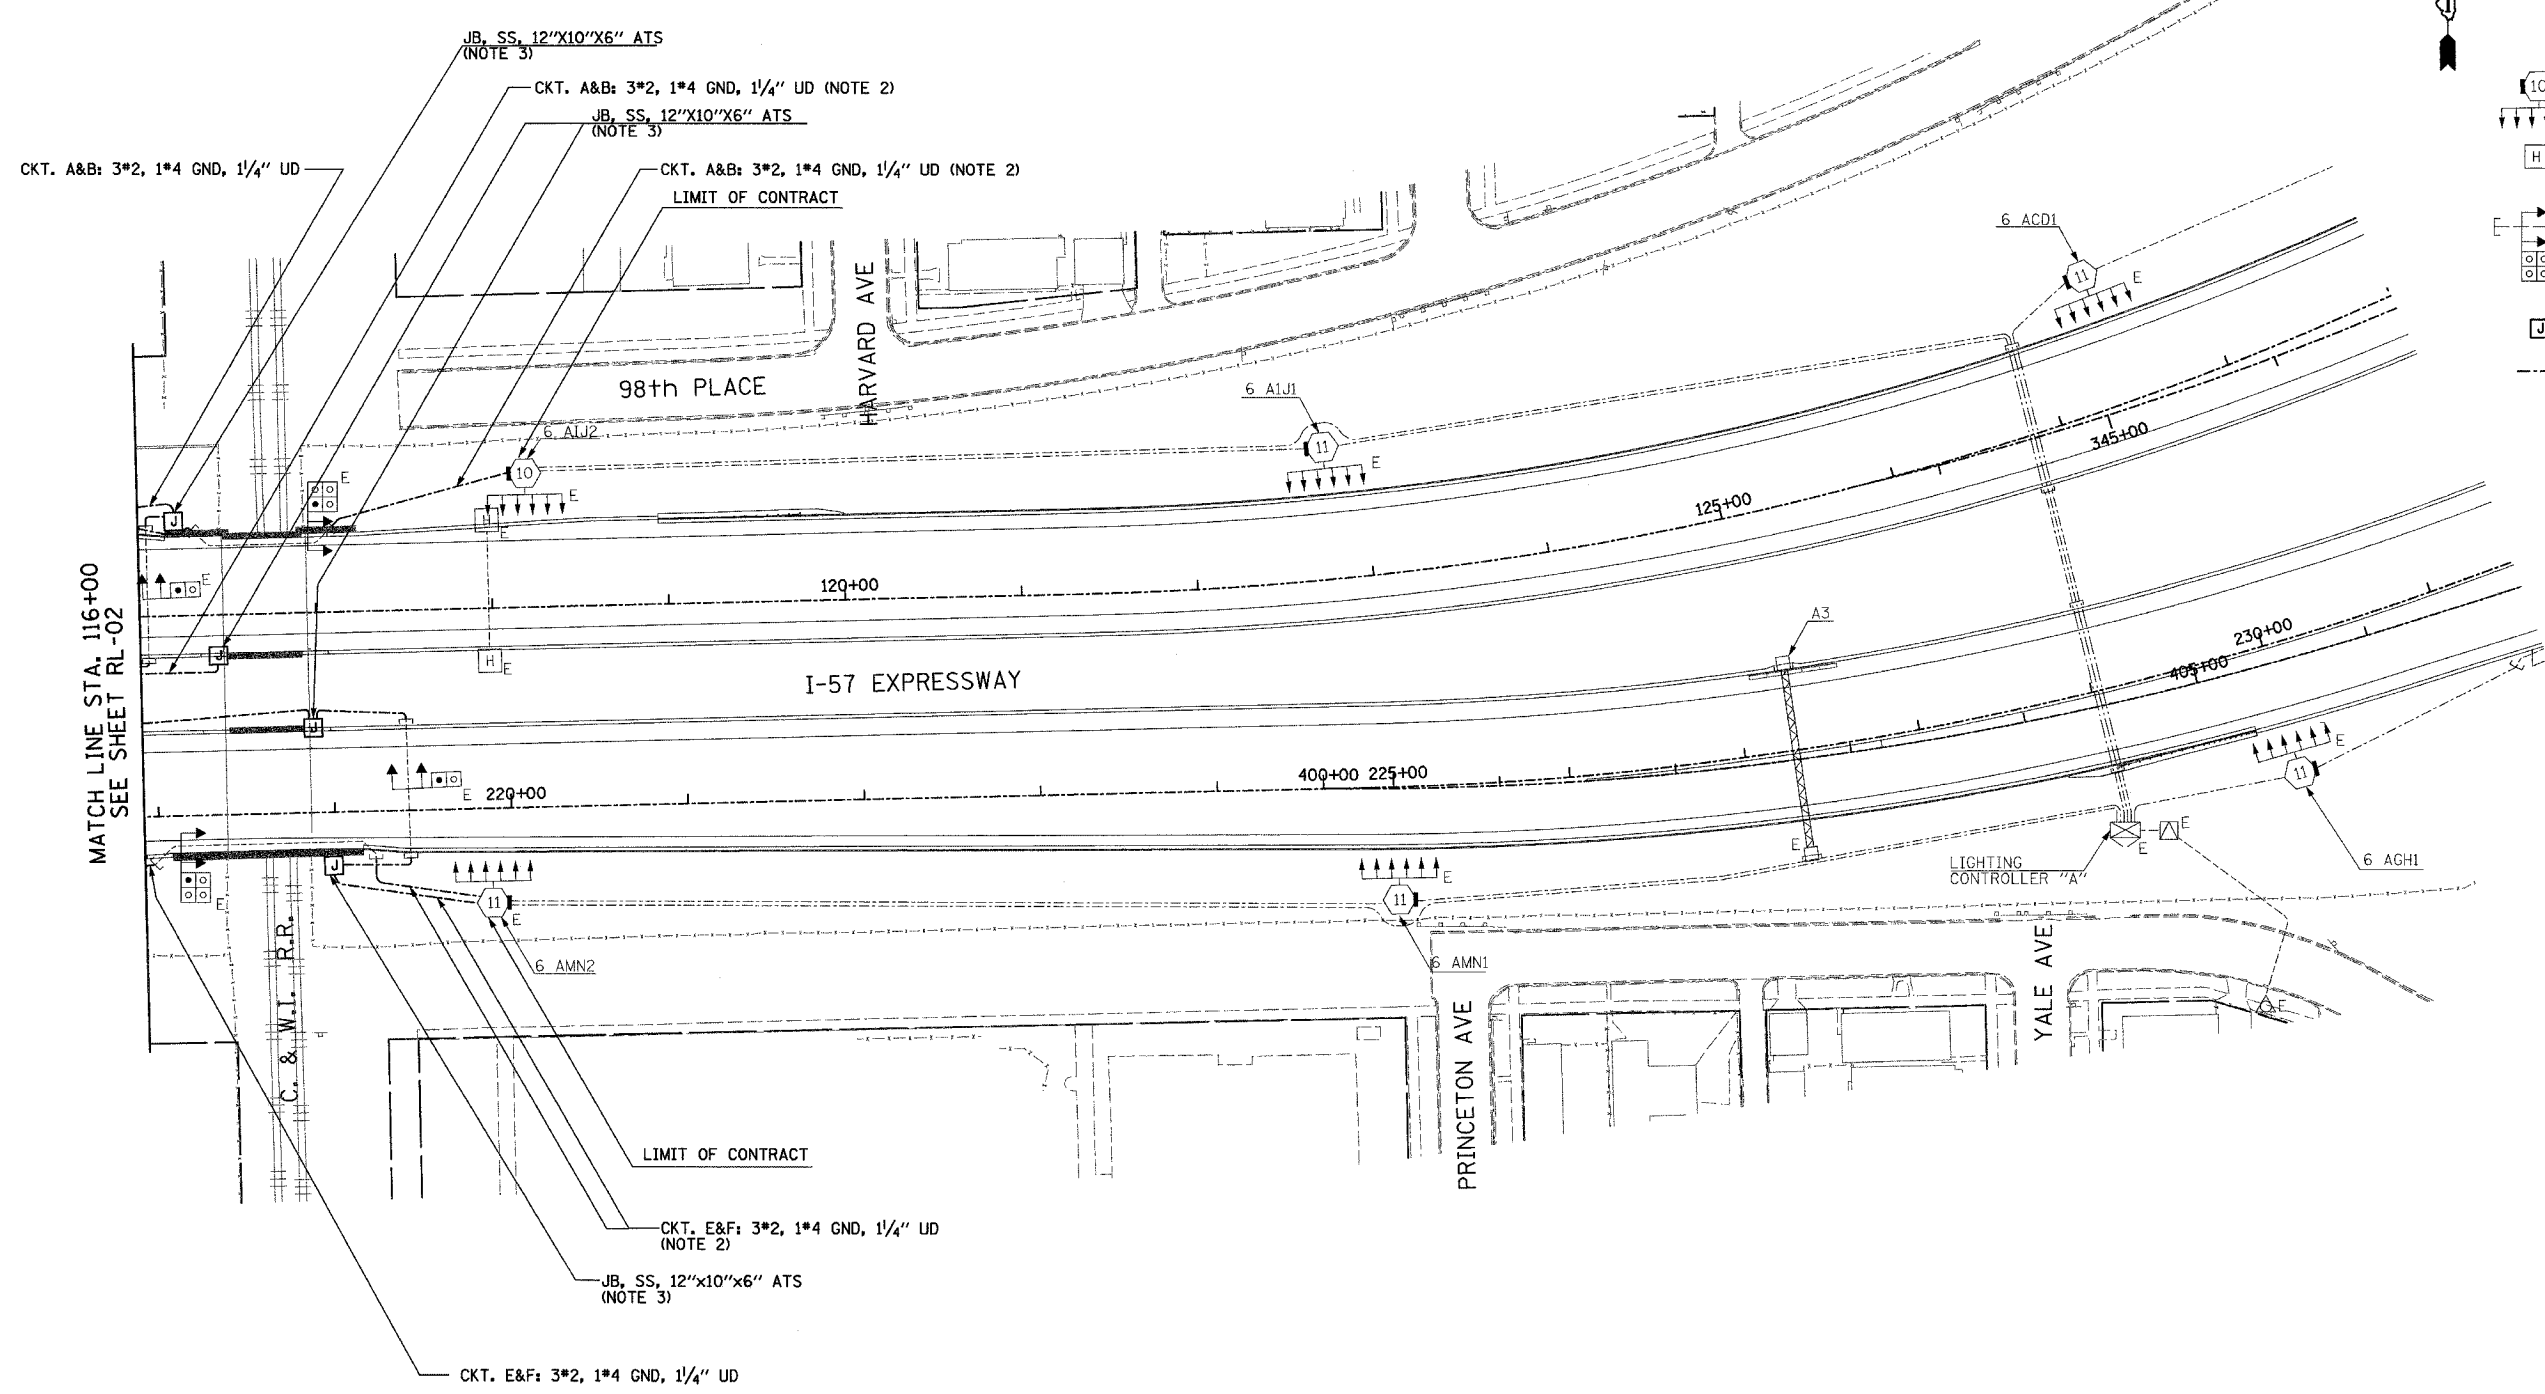

MATCH LINE STA. 116+00
SEE SHEET RL-02



2D/RL-03

REVISIONS	
NAME	DATE

ILLINOIS DEPARTMENT OF TRANSPORTATION
F.A.I. 94 (DAN RYAN EXPRESSWAY)

ROADWAY LIGHTING PLANS
PROPOSED IMPROVEMENTS

SCALE: 1"=50' DRAWN BY: VG
DATE: JANUARY 13, 2006 CHECKED BY: TM

SINGH 300 W. ADAMS ST.
CHICAGO, IL 60606
SINGH & ASSOCIATES, INC. TEL: (312) 629-0240
CONSULTING ENGINEERS FAX: (312) 629-8449

1:36:21 PM
2/4/2006