


**PLAN ABOVE EL. -48.0'**

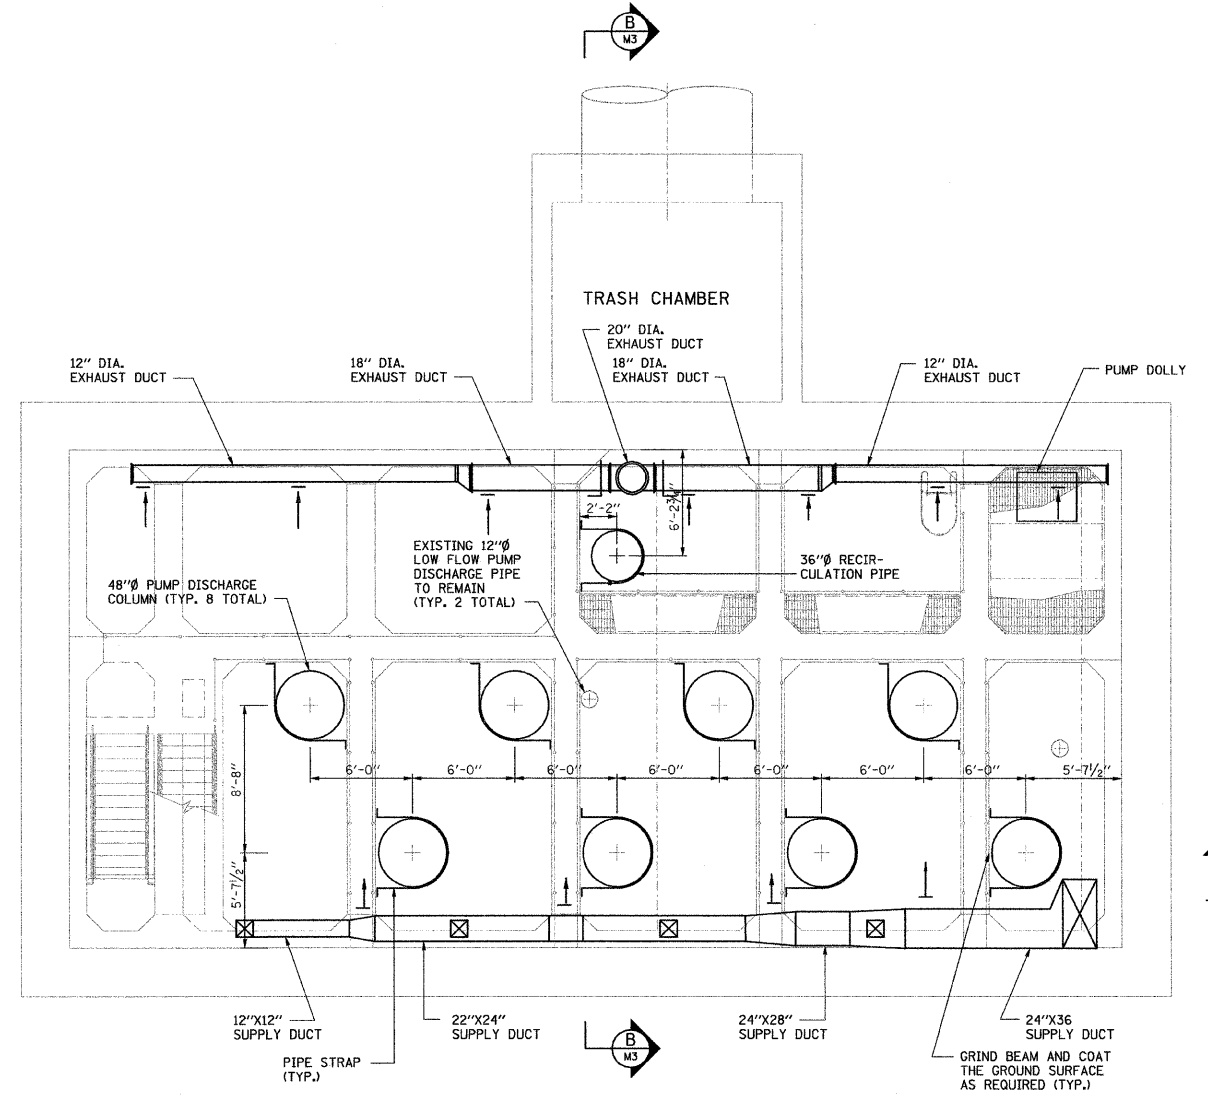

**PLAN ABOVE EL. -26.5'**

NOTE:  
 1. ALL ROOM EXCEPT ELECTRICAL CONTROL ROOM SHALL BE CLASS I, DIVISION 1, GROUP D EXPLOSION PROOF.



M2

REVISIONS	
NAME	DATE

ILLINOIS DEPARTMENT OF TRANSPORTATION

**PUMP STATION NO. 27  
REHABILITATION**

**MECHANICAL PLANS**

SCALE: AS SHOWN  
 DATE: 04-23-10

DRAWN BY: HFF  
 CHECKED BY: KHC