


SECTION A-A

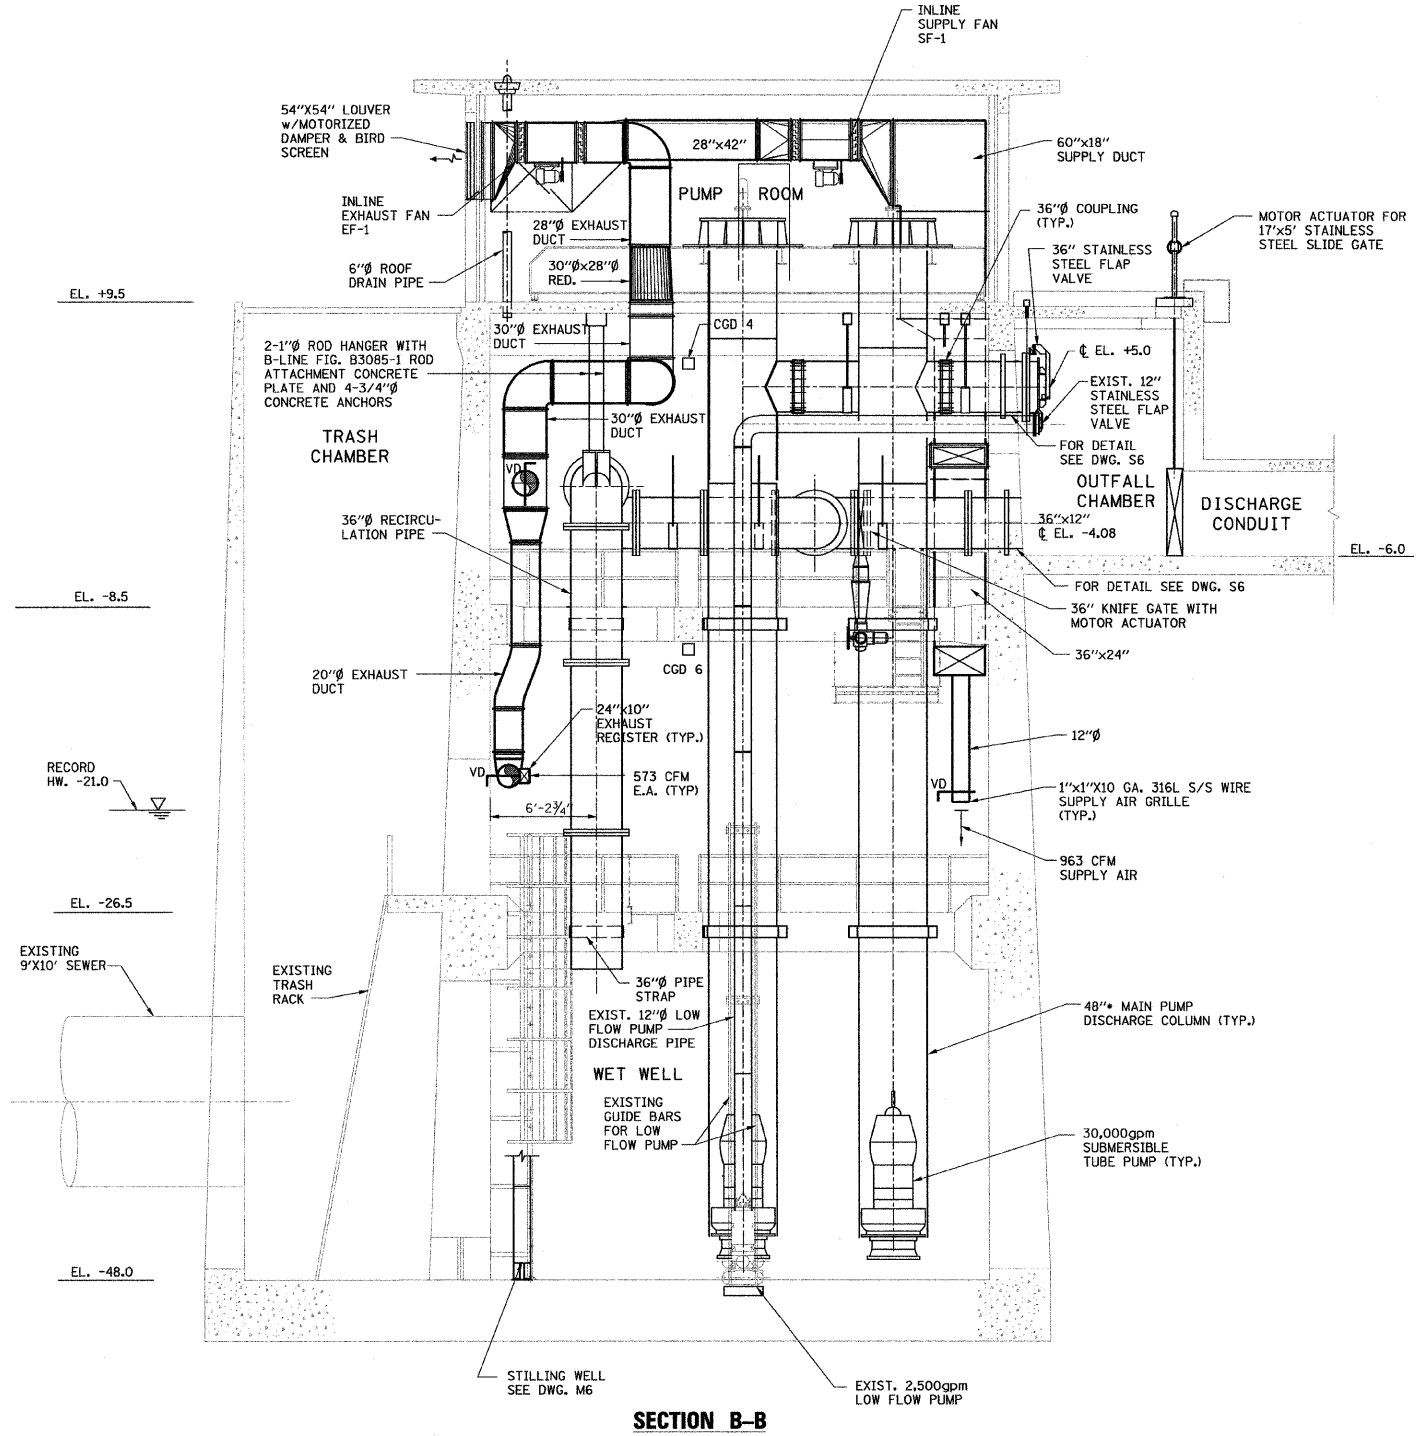


SECTION B-B

NOTES:

- ALL ROOM EXCEPT ELECTRICAL CONTROL ROOM SHALL BE CLASS I, DIVISION 1, GROUP D EXPLOSION PROOF.
- EXISTING 12" LOW FLOW PUMP DISCHARGE STEEL PIPE SHALL BE CLEANED AND PAINTED PER SECTION 9A.

M3

REVISIONS	
NAME	DATE

 

ILLINOIS DEPARTMENT OF TRANSPORTATION

PUMP STATION NO. 27
REHABILITATION

MECHANICAL PLANS

SCALE: AS SHOWN

DATE: 04-23-10

DRAWN BY: HFF

CHECKED BY: KHC