


F.A.P. RTE.	SECTION	COUNTY	TOTAL SHEETS	SHEET NO.
90/94	1999-161-1	COOK	75	45
STA.		TO STA.		
FED. ROAD DIST. NO.		ILLINOIS	FED. AID PROJECT	
D-91-411-99				

**IDOT PS26 ELECTRICAL SYSTEM ONE LINE DIAGRAM**

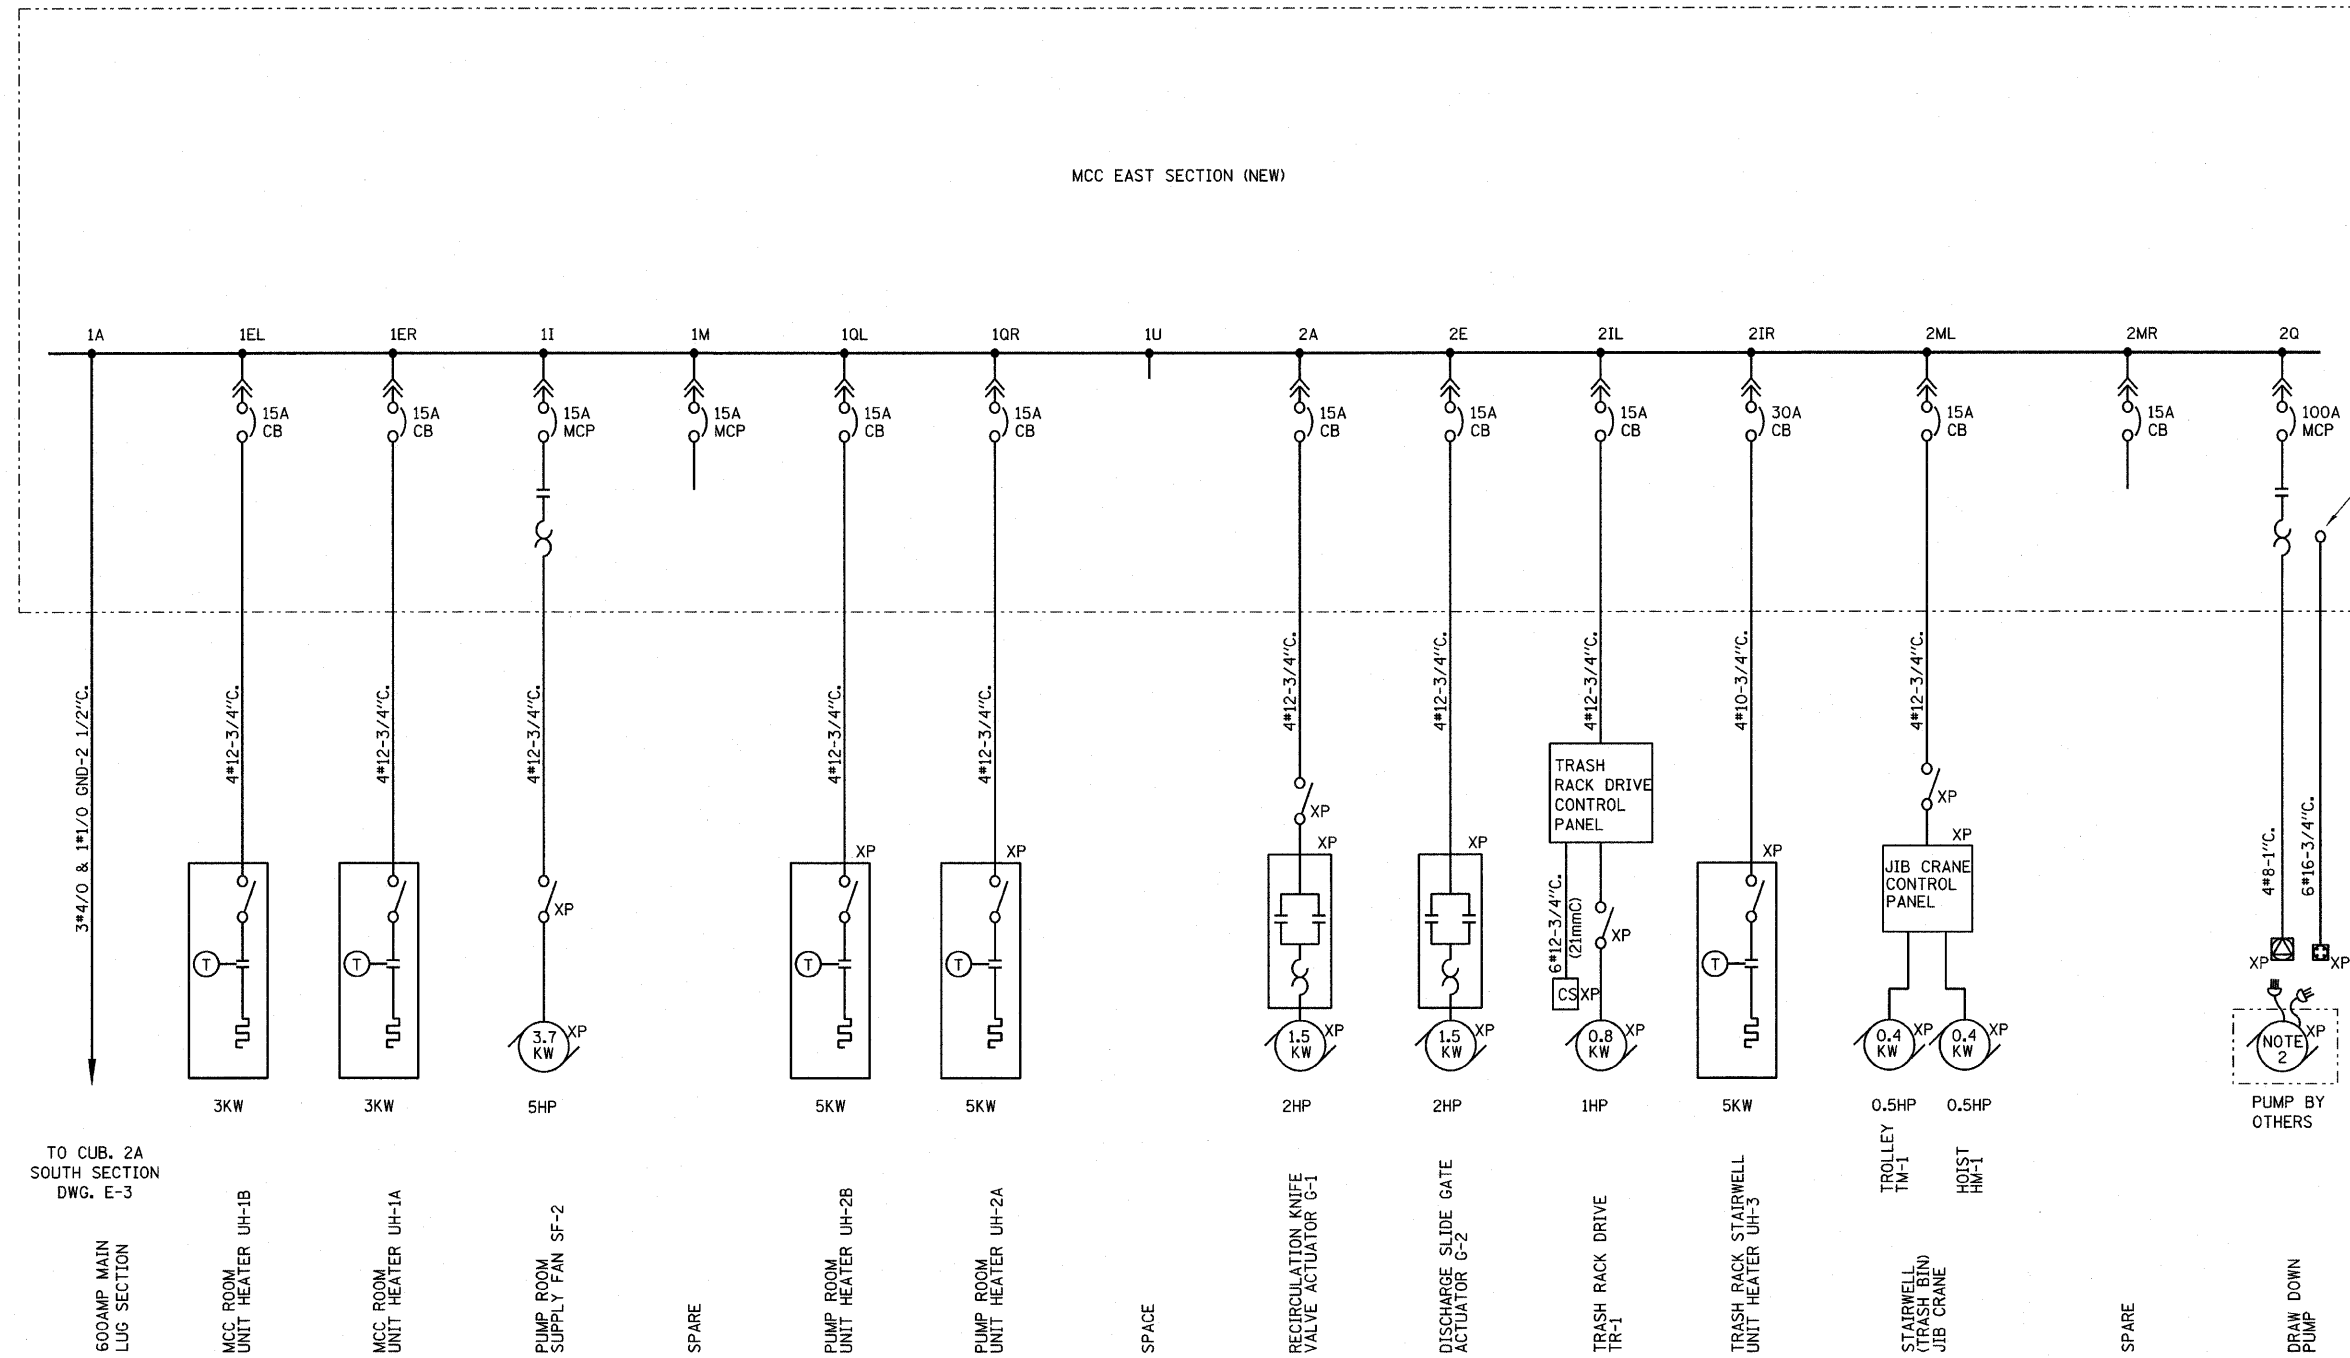

NOTE 1

**NOTES:**

- FVNR STARTER FOR DRAW DOWN PUMP LOCATED IN THE EXISTING COMPARTMENT 2N OF SOUTH SECTION MCC SHOULD BE RELOCATED INTO COMPARTMENT 2Q OF THE EAST SECTION. EXISTING CONDUIT AND CABLE SHALL BE REMOVED.
- DRAW DOWN PUMP PROVIDED BY IDOT AND CANNOT EXCEED 30HP.

TO CUB. 2A  
SOUTH SECTION  
DWG. E-3

PLOT DATE = 3/22/2010  
FILE NAME = D:\60828-161-1\11-E-3A.dgn  
PLOT SCALE = 1:1  
USER NAME = MUSER



REVISIONS	
NAME	DATE

ILLINOIS DEPARTMENT OF TRANSPORTATION

**MCC-PS26 ONE LINE DIAGRAM - SHEET 2**

SCALE: VERT. NO SCALE  
HORIZ. DATE: 3/23/2010

DRAWN BY: B.K.  
CHECKED BY: M.Z.