



F.A.P. RTE.	SECTION	COUNTY	TOTAL SHEETS	SHEET NO.
80/94	1999-161-1	COOK	75	65
STA.		TO STA.		
FED. ROAD DIST. NO.		ILLINOIS	FED. AID PROJECT	
D-91-411-99				

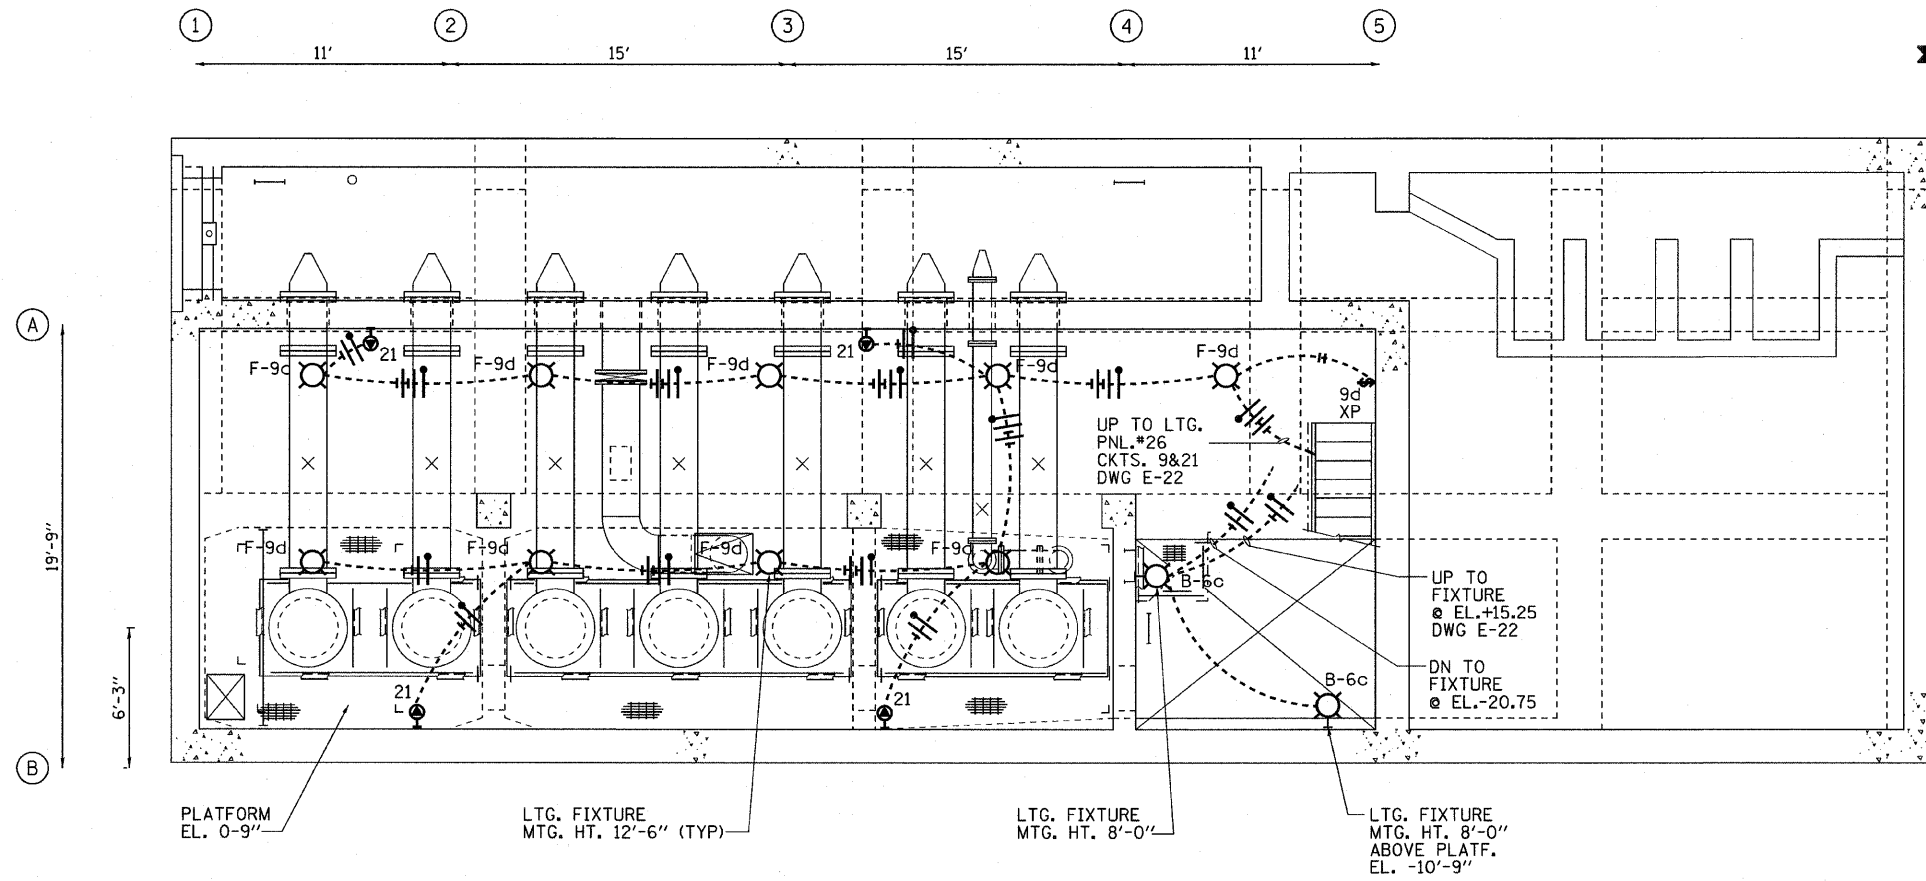

PLAN B-B AT EL.-2.75'

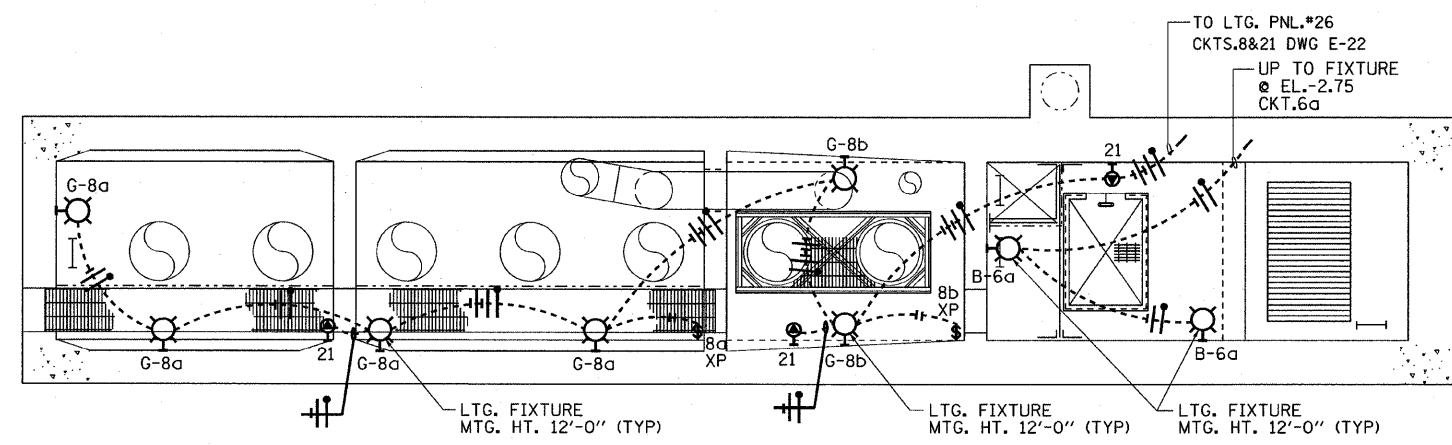

PLAN C-C AT EL.-20'-9'

**NOTES:**  
 ALL ELECTRICAL WORK SHALL BE IN ACCORDANCE WITH THE LATEST NEC REQUIREMENTS FOR CLASS 1 DIVISION 1 GROUP D HAZARDOUS LOCATIONS, EXCEPT THE ELECTRICAL ROOM.

REVISIONS		ILLINOIS DEPARTMENT OF TRANSPORTATION
NAME	DATE	
		<b>ELECTRICAL LIGHTING PLANS - SHEET 2</b>  SCALE: VERT. 1/4"=1'-0" HORIZ. 1/4"=1'-0" DATE: 3/23/2010  DRAWN BY: B.K. CHECKED BY: M.Z.



PLOT DATE = 3/22/2010  
 FILE NAME = D:\60828-ah-E-23.dgn  
 PLOT SCALE = 1/4"  
 USER NAME = MUSERN