


MATCH LINE SEE SHEET DU-15

MATCH LINE SEE SHEET DU-5
RAMP B STA. 3005+00.00
RAMP E STA. 121+92.75

MATCH LINE SEE SHEET DU-4
EAST FRONTAGE RD STA. 8033+00.00
RAMP B STA. 3018+96.11
RAMP E STA. 106+76.68


MATCH LINE SEE SHEET DU-7
EAST FRONTAGE RD STA. 8047+00.00

DETENTION POND 1E
100 YR DESIGN
HWL = 528.65
STORAGE PROVIDED = 14.02 AC-FT

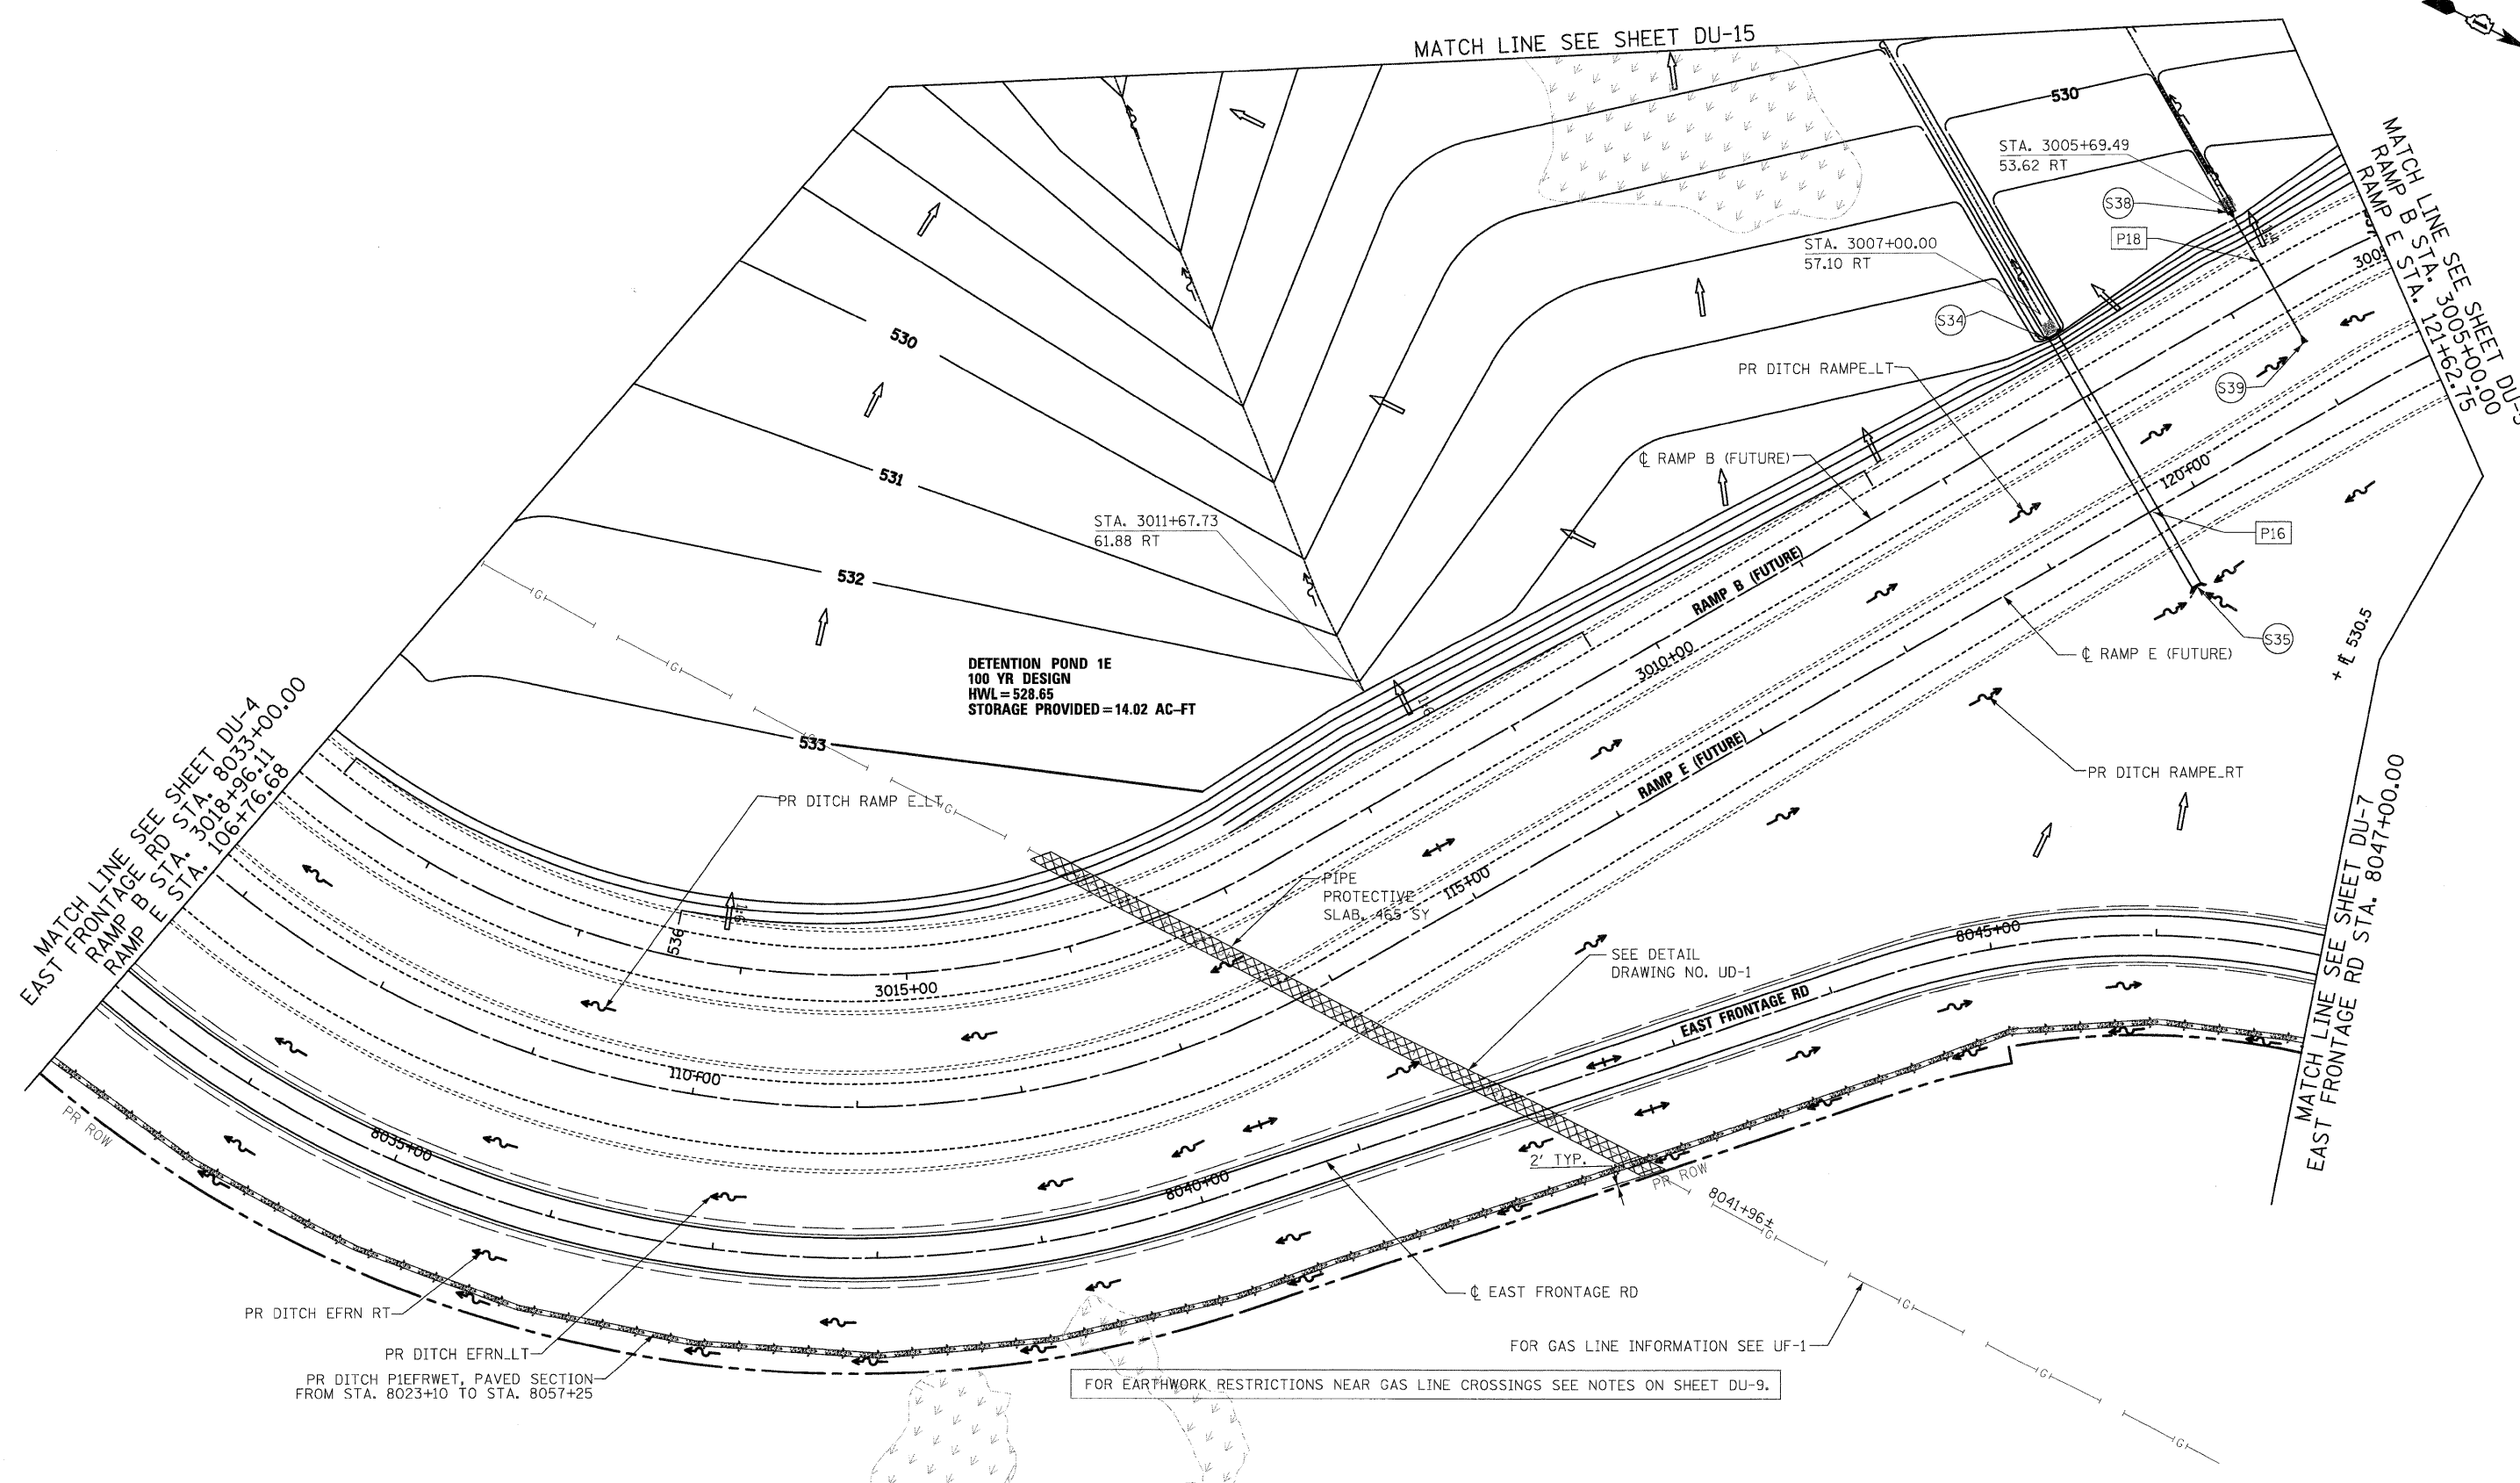

PR DITCH EFRN RT
PR DITCH EFRN LT
PR DITCH PIPEFRWT, PAVED SECTION
FROM STA. 8023+10 TO STA. 8057+25

FOR GAS LINE INFORMATION SEE UF-1
FOR EARTHWORK RESTRICTIONS NEAR GAS LINE CROSSINGS SEE NOTES ON SHEET DU-9.

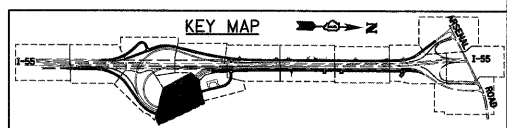

SINGH & ASSOCIATES, INC.
 CONSULTING ENGINEERS
 300 W. ADAMS ST.
 CHICAGO, IL 60606
 TEL: (312) 629-0240
 FAX: (312) 629-8449

FILE NAME = D162C31-SHT-DRAIN06.dgn	USER NAME = Tkluegel	DESIGNED - PKT/VP	REVISED -
		DRAWN - PKT/VP	REVISED -
		CHECKED - CL	REVISED -
		DATE - 12/18/09	REVISED -

STATE OF ILLINOIS
DEPARTMENT OF TRANSPORTATION

DRAINAGE AND UTILITY PLAN

SCALE: 1"=50' SHEET NO. 6 OF 22 SHEETS STA. TO STA.

F.A.I. RTE.	SECTION	COUNTY	TOTAL SHEETS	SHEET NO.
55	(99-1&2)AC-3	WILL	524	149
CONTRACT NO. 60C31				
FED. ROAD DIST. NO. 1 ILLINOIS FED. AID PROJECT				