




MATCH LINE SEE SHEET RL-P1
FRONTAGE RD WEST 5002+10.00
SB ENTRANCE RAMP 4021+8.63

MATCH LINE
FRONTAGE RD EAST 8005+50.00
NB I-55 EXIT 7000+16.15

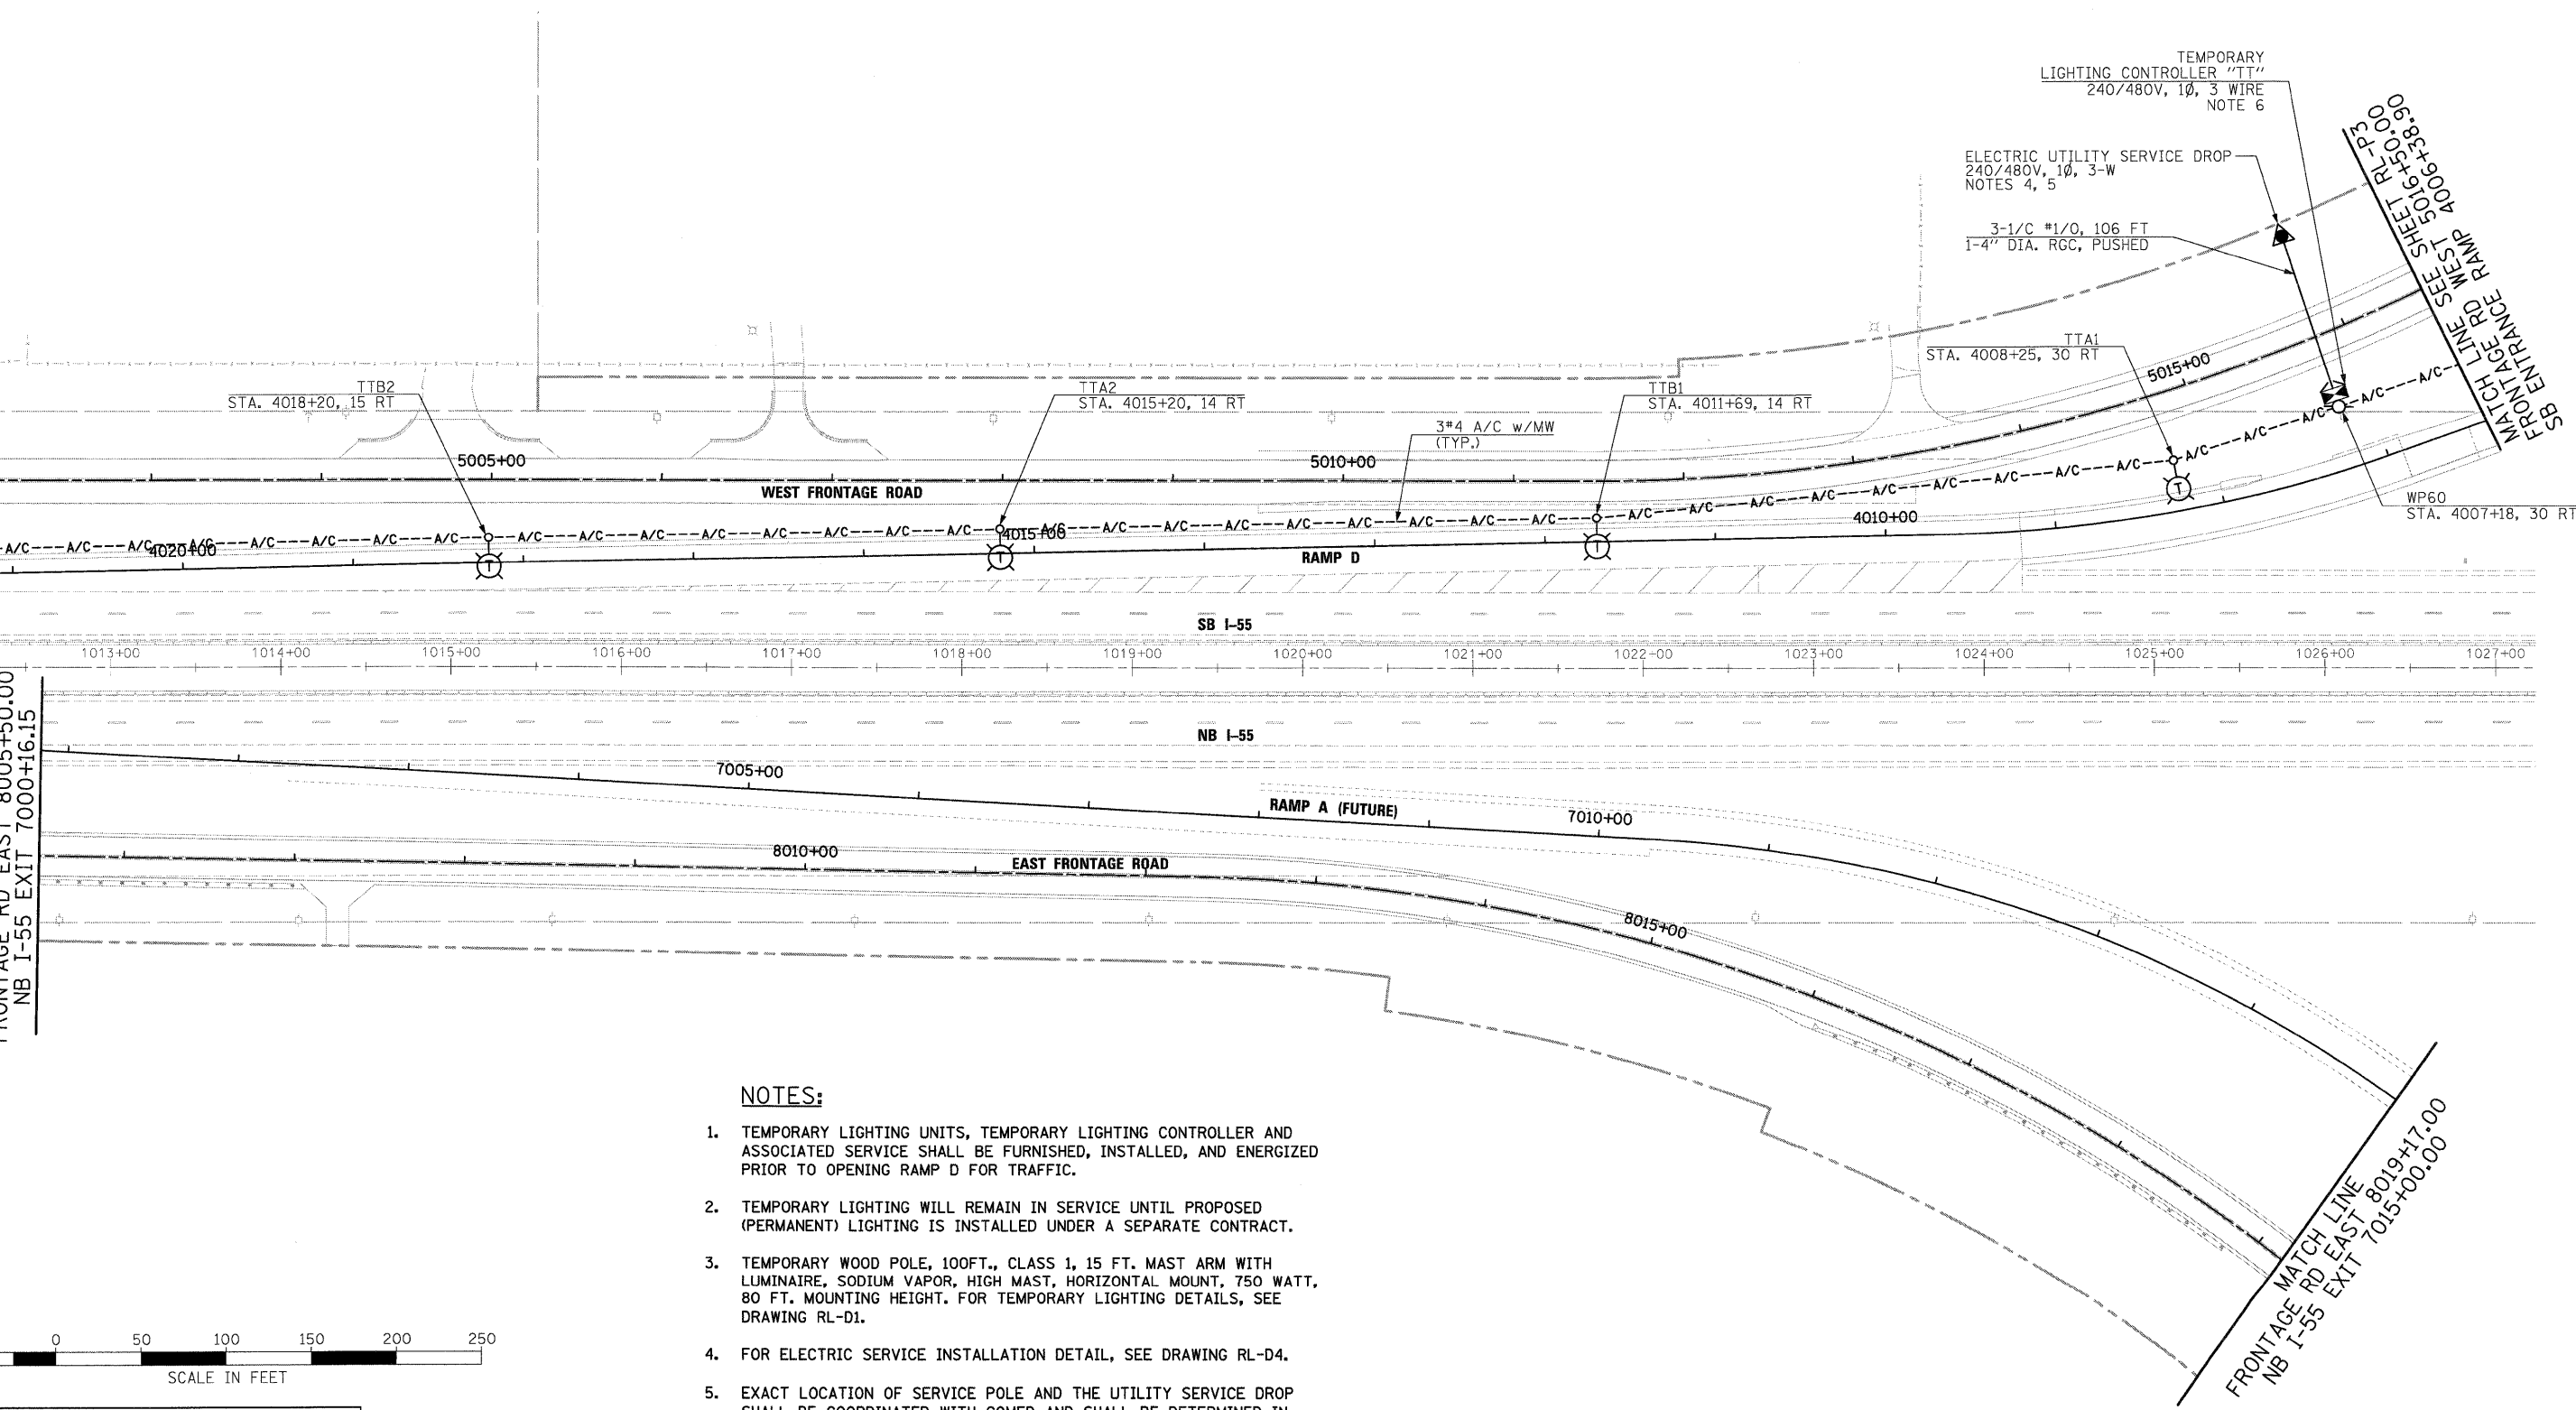

NOTES:

 1. TEMPORARY LIGHTING UNITS, TEMPORARY LIGHTING CONTROLLER AND ASSOCIATED SERVICE SHALL BE FURNISHED, INSTALLED, AND ENERGIZED PRIOR TO OPENING RAMP D FOR TRAFFIC.
2. TEMPORARY LIGHTING WILL REMAIN IN SERVICE UNTIL PROPOSED (PERMANENT) LIGHTING IS INSTALLED UNDER A SEPARATE CONTRACT.
3. TEMPORARY WOOD POLE, 100FT., CLASS 1, 15 FT. MAST ARM WITH LUMINAIRE, SODIUM VAPOR, HIGH MAST, HORIZONTAL MOUNT, 750 WATT, 80 FT. MOUNTING HEIGHT. FOR TEMPORARY LIGHTING DETAILS, SEE DRAWING RL-D1.
4. FOR ELECTRIC SERVICE INSTALLATION DETAIL, SEE DRAWING RL-D4.
5. EXACT LOCATION OF SERVICE POLE AND THE UTILITY SERVICE DROP SHALL BE COORDINATED WITH COMED AND SHALL BE DETERMINED IN THE FIELD WITH THE ENGINEER.
6. FOR TEMPORARY LIGHTING CONTROLLER INSTALLATION DETAILS, SEE DRAWING RL-D1.

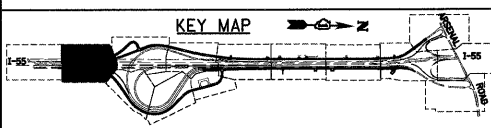

McDonough Associates Inc.
Engineers / Architects
130 East Randolph Street, Chicago, Illinois 60601

FILE NAME = D168C31-SHT-PLAN02.dgn	USER NAME = TKLuegel	DESIGNED - JLW	REVISED -
		DRAWN - CJM	REVISED -
		CHECKED - KMY	REVISED -
		DATE 12/18/09	REVISED -

**STATE OF ILLINOIS
DEPARTMENT OF TRANSPORTATION**

**I-55 AT ARSENAL ROAD
RAMP D TEMPORARY LIGHTING PLAN**

SCALE: 1" = 50' SHEET NO. 2 OF 3 SHEETS STA. TO STA.

F.A.I. RTE.	SECTION	COUNTY	TOTAL SHEETS	SHEET NO.
55	(99-1&2)AC-3	WILL	524	293
CONTRACT NO. 60C31				

FED. ROAD DIST. NO. 1 ILLINOIS FED. AID PROJECT