
 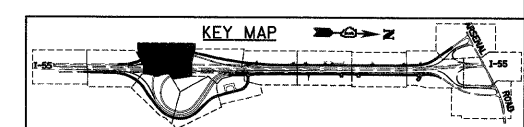


NOTES:

1. TEMPORARY LIGHTING UNITS, TEMPORARY LIGHTING CONTROLLER AND ASSOCIATED SERVICE SHALL BE FURNISHED, INSTALLED, AND ENERGIZED PRIOR TO OPENING RAMP D FOR TRAFFIC.
2. TEMPORARY LIGHTING WILL REMAIN IN SERVICE UNTIL PROPOSED (PERMANENT) LIGHTING IS INSTALLED UNDER A SEPARATE CONTRACT.
3. TEMPORARY WOOD POLE, 100FT., CLASS 1, 15 FT. MAST ARM WITH LUMINAIRE, SODIUM VAPOR, HIGH MAST, HORIZONTAL MOUNT, 750 WATT, 80 FT. MOUNTING HEIGHT. FOR TEMPORARY LIGHTING DETAILS, SEE DRAWING RL-D1.



McDonough Associates Inc.
 Engineers / Architects
 130 East Randolph Street, Chicago, Illinois 60601

FILE NAME =
 D162C31-SHT-PLAN03.dgn
 USER NAME = TKLuegel
 PLOT SCALE = 1:50
 PLOT DATE = 12/11/2009

DESIGNED - JLW	REVISED -
DRAWN - CJM	REVISED -
CHECKED - KMY	REVISED -
DATE - 12/18/09	REVISED -

STATE OF ILLINOIS
DEPARTMENT OF TRANSPORTATION

I-55 AT ARSENAL ROAD
RAMP D TEMPORARY LIGHTING PLAN

SCALE: 1" = 50' SHEET NO. 3 OF 3 SHEETS STA. TO STA.

F.A.I. RTE.	SECTION	COUNTY	TOTAL SHEETS	SHEET NO.
55	(99-1&2)AC-3	WILL	524	294
FED. ROAD DIST. NO. 1 ILLINOIS FED. AID PROJECT			CONTRACT NO. 60C31	

FINAL
 RL-P3