
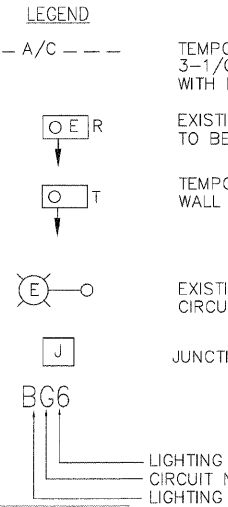
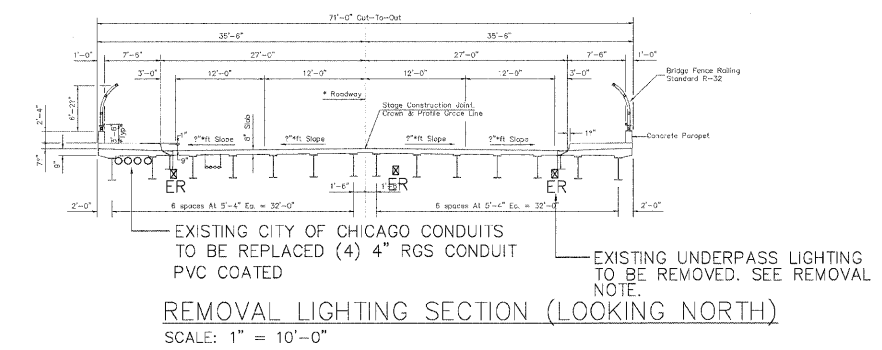


F.A. I. RTE.	SECTION	COUNTY	TOTAL SHEETS	SHEET NO.
57	068-2222-3B	COOK	77	22
STA.		TO STA.		
FED. ROAD DIST. NO.		ILLINOIS FED. AID PROJECT		

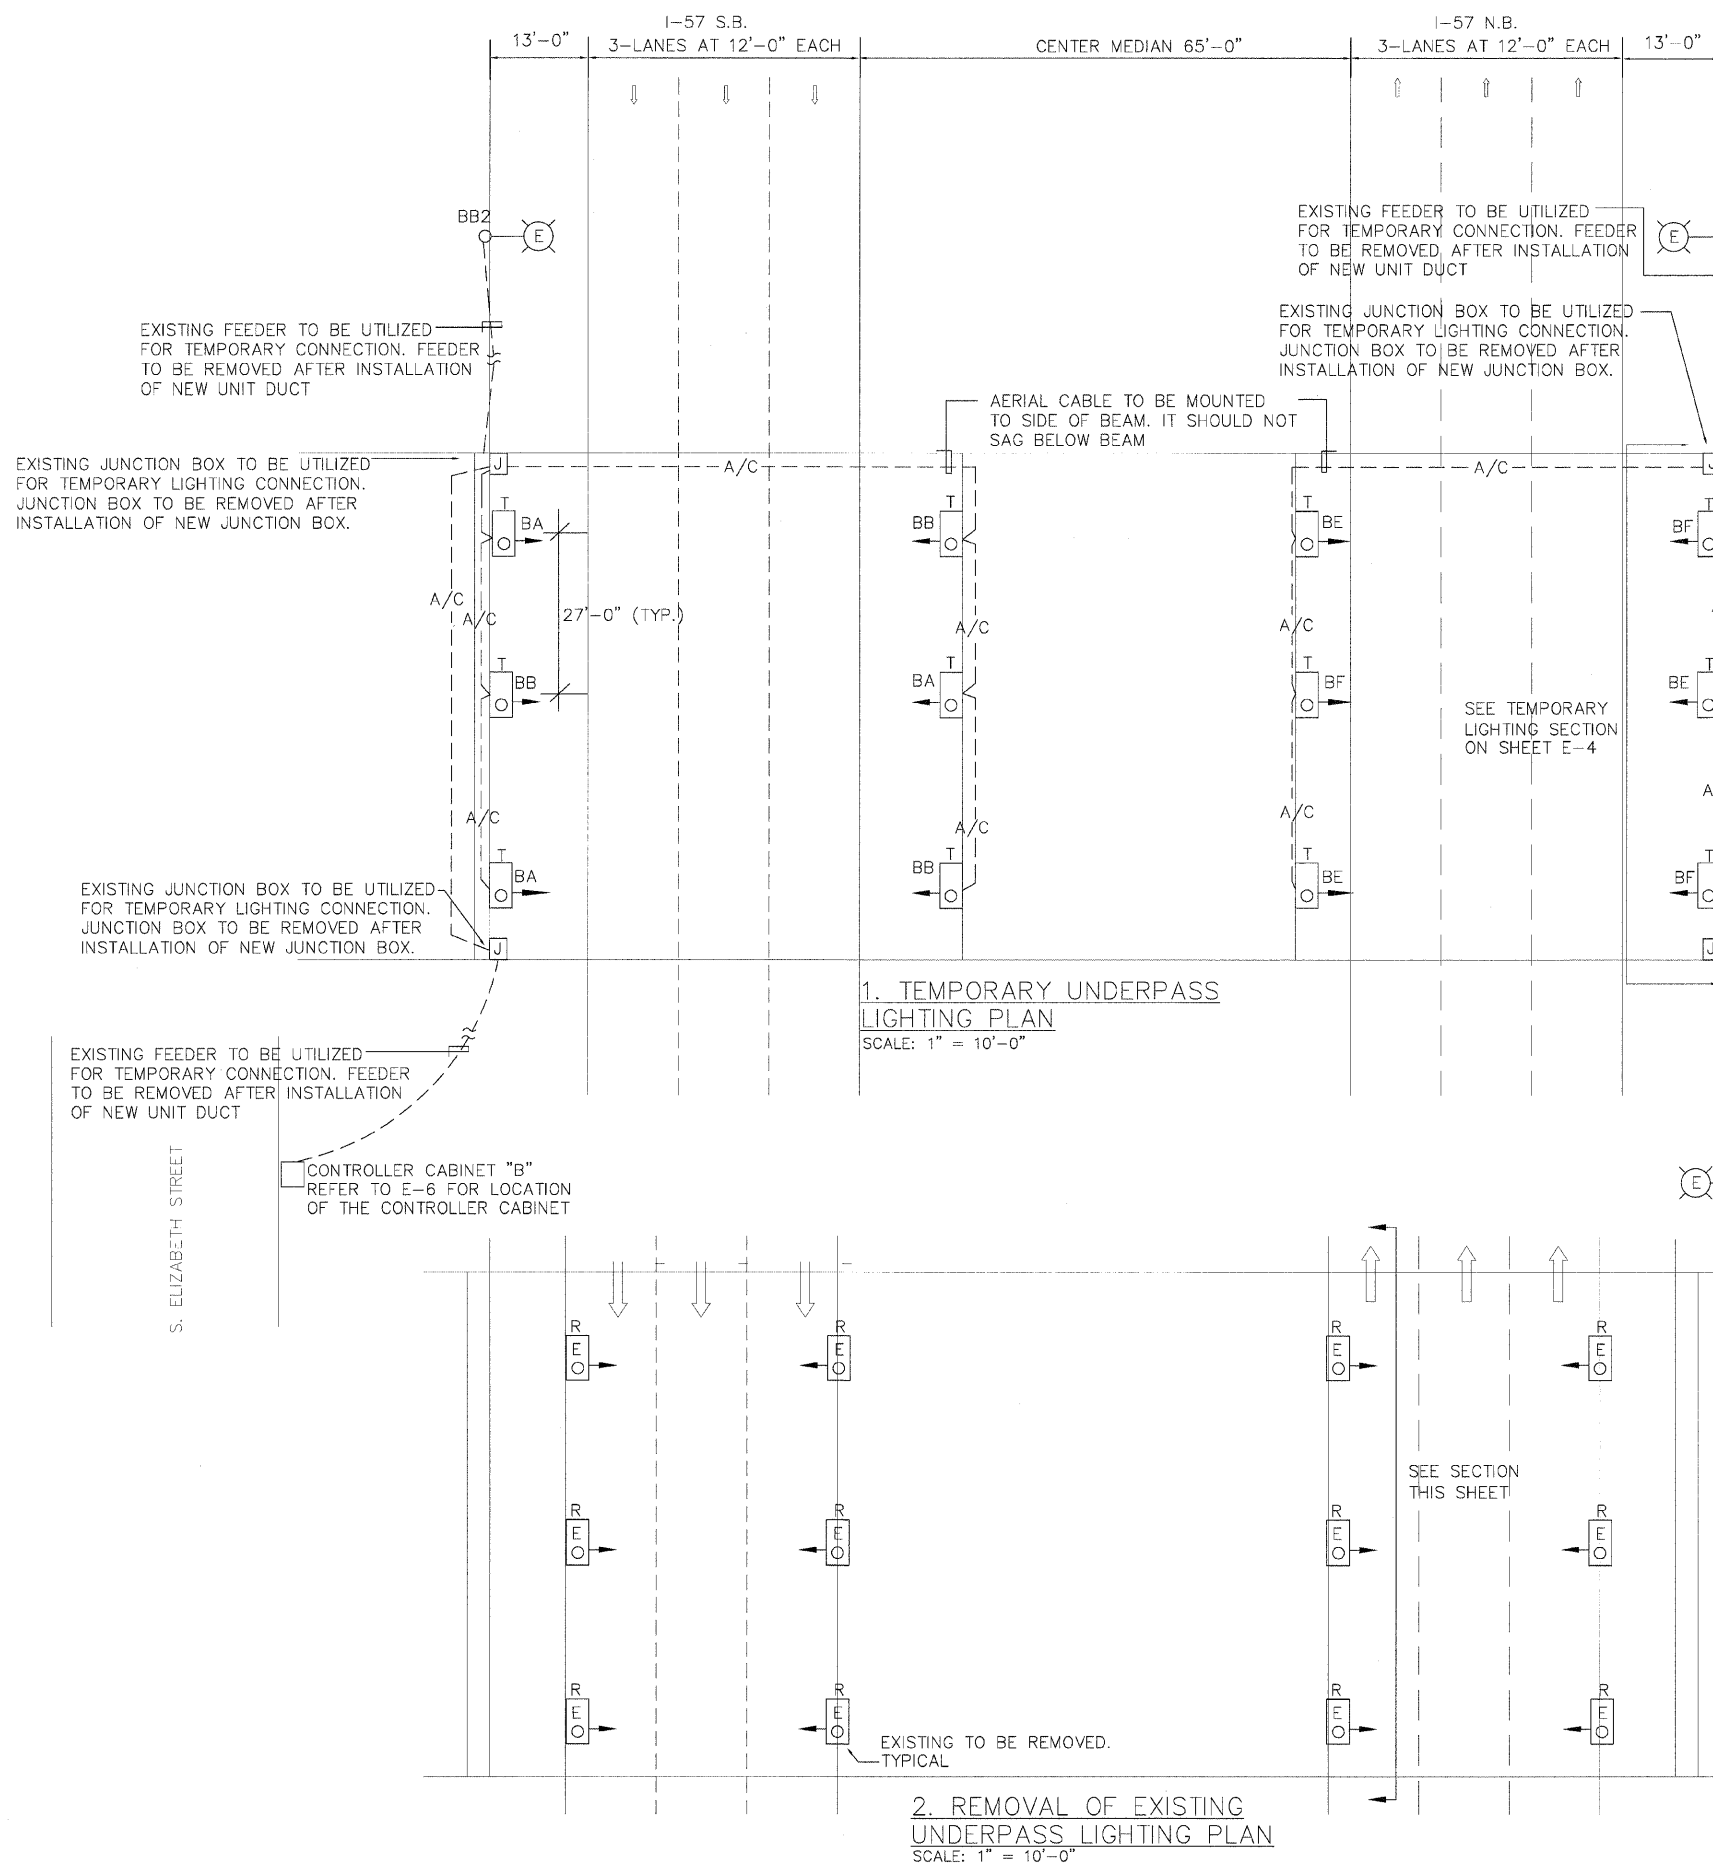

 
- SEQUENCE OF INSTALLATION NOTES:**
1. INSTALL TEMPORARY LIGHTING LUMINAIRES WITH ALL ASSOCIATED AERIAL CABLES AND SUPPORT AS REQUIRED FOR OPERATION. OBTAIN TEMPORARY LIGHTING LUMINAIRES FROM THE STATE STOCK. TEMPORARY UNDERPASS LIGHTING PICKUP SHALL BE COORDINATED WITH NEIL THAKKAR, ELECTRICAL MAINTENANCE SECTION OF IDOT AT TELEPHONE NUMBER (847) 221-3078 (48 HOURS ADVANCE NOTICE REQUIRED). ENSURE FULL FUNCTIONAL OPERATION. REFER TO THIS SHEET (1. TEMPORARY UNDERPASS LIGHTING PLAN) FOR LOCATION OF TEMPORARY LIGHTING.
 2. REMOVE EXISTING UNDERPASS LIGHTING UNITS INCLUDING ALL ASSOCIATED CONDUITS, WIRING, JUNCTION BOXES AND ALL ASSOCIATED EQUIPMENT PART OF REMOVAL WORK. REFER TO THIS SHEET (2. REMOVAL OF EXISTING UNDERPASS LIGHTING PLAN) FOR REMOVAL OF EXISTING LIGHTING.
 3. INSTALL NEW UNDERPASS LIGHTING AS INDICATED ON SHEET E-3 (1. PROPOSED UNDERPASS LIGHTING PLAN)
 4. REMOVE TEMPORARY UNDERPASS LIGHTING AND ALL ASSOCIATED WIRING, JUNCTION BOXES, ETC. PART OF THE TEMPORARY LIGHTING WORK. REFER TO E-4 (2. REMOVAL OF TEMPORARY UNDERPASS LIGHTING PLAN) FOR REMOVAL OF TEMPORARY LIGHTING.
 5. COMPONENTS OTHER THAN 70W HPS TEMPORARY UNDERPASS LUMINAIRES COMPRISING THE TEMPORARY LIGHTING SHALL BECOME THE PROPERTY OF THE CONTRACTOR AND SHALL BE REMOVED FROM THE LIMITS OF THE PROJECT. THE CONTRACTOR SHALL PACK THE TEMPORARY 70W HPS UNDERPASS LUMINAIRES INTO ORIGINAL BOXES AND RETURN THEM TO THE STATE STOCK. COORDINATE WITH NEIL THAKKAR, ELECTRICAL MAINTENANCE SECTION OF IDOT AT TELEPHONE NUMBER (847) 221-3078 (48 HOURS ADVANCE NOTICE REQUIRED).

1. TEMPORARY UNDERPASS LIGHTING PLAN
SCALE: 1" = 10'-0"

2. REMOVAL OF EXISTING UNDERPASS LIGHTING PLAN
SCALE: 1" = 10'-0"

Advance
Consulting Group International

303 W. ADAMS ST.
SUITE 322
CHICAGO, IL 60606
TEL: 312-357-1540
FAX: 312-357-1845
EMAIL: advance@cgint.com



REVISIONS	
NAME	DATE

ILLINOIS DEPARTMENT OF TRANSPORTATION

**GENOA AVE UNDERPASS
TEMPORARY AND REMOVAL LIGHTING PLAN**

DATE 8-4-09

DRAWN BY EHE
CHECKED BY EE