

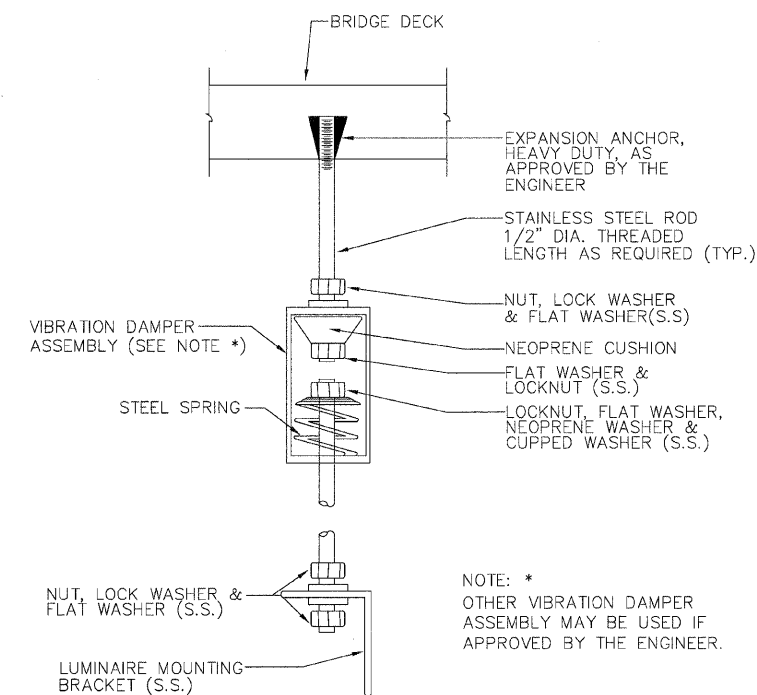



F.A.I. RTE.	SECTION	COUNTY	TOTAL SHEETS	SHEET NO.
57	068-2222-3B	COOK	77	25
STA.		TO STA.		
FED. ROAD DIST. NO.	ILLINOIS	FED. AID PROJECT		

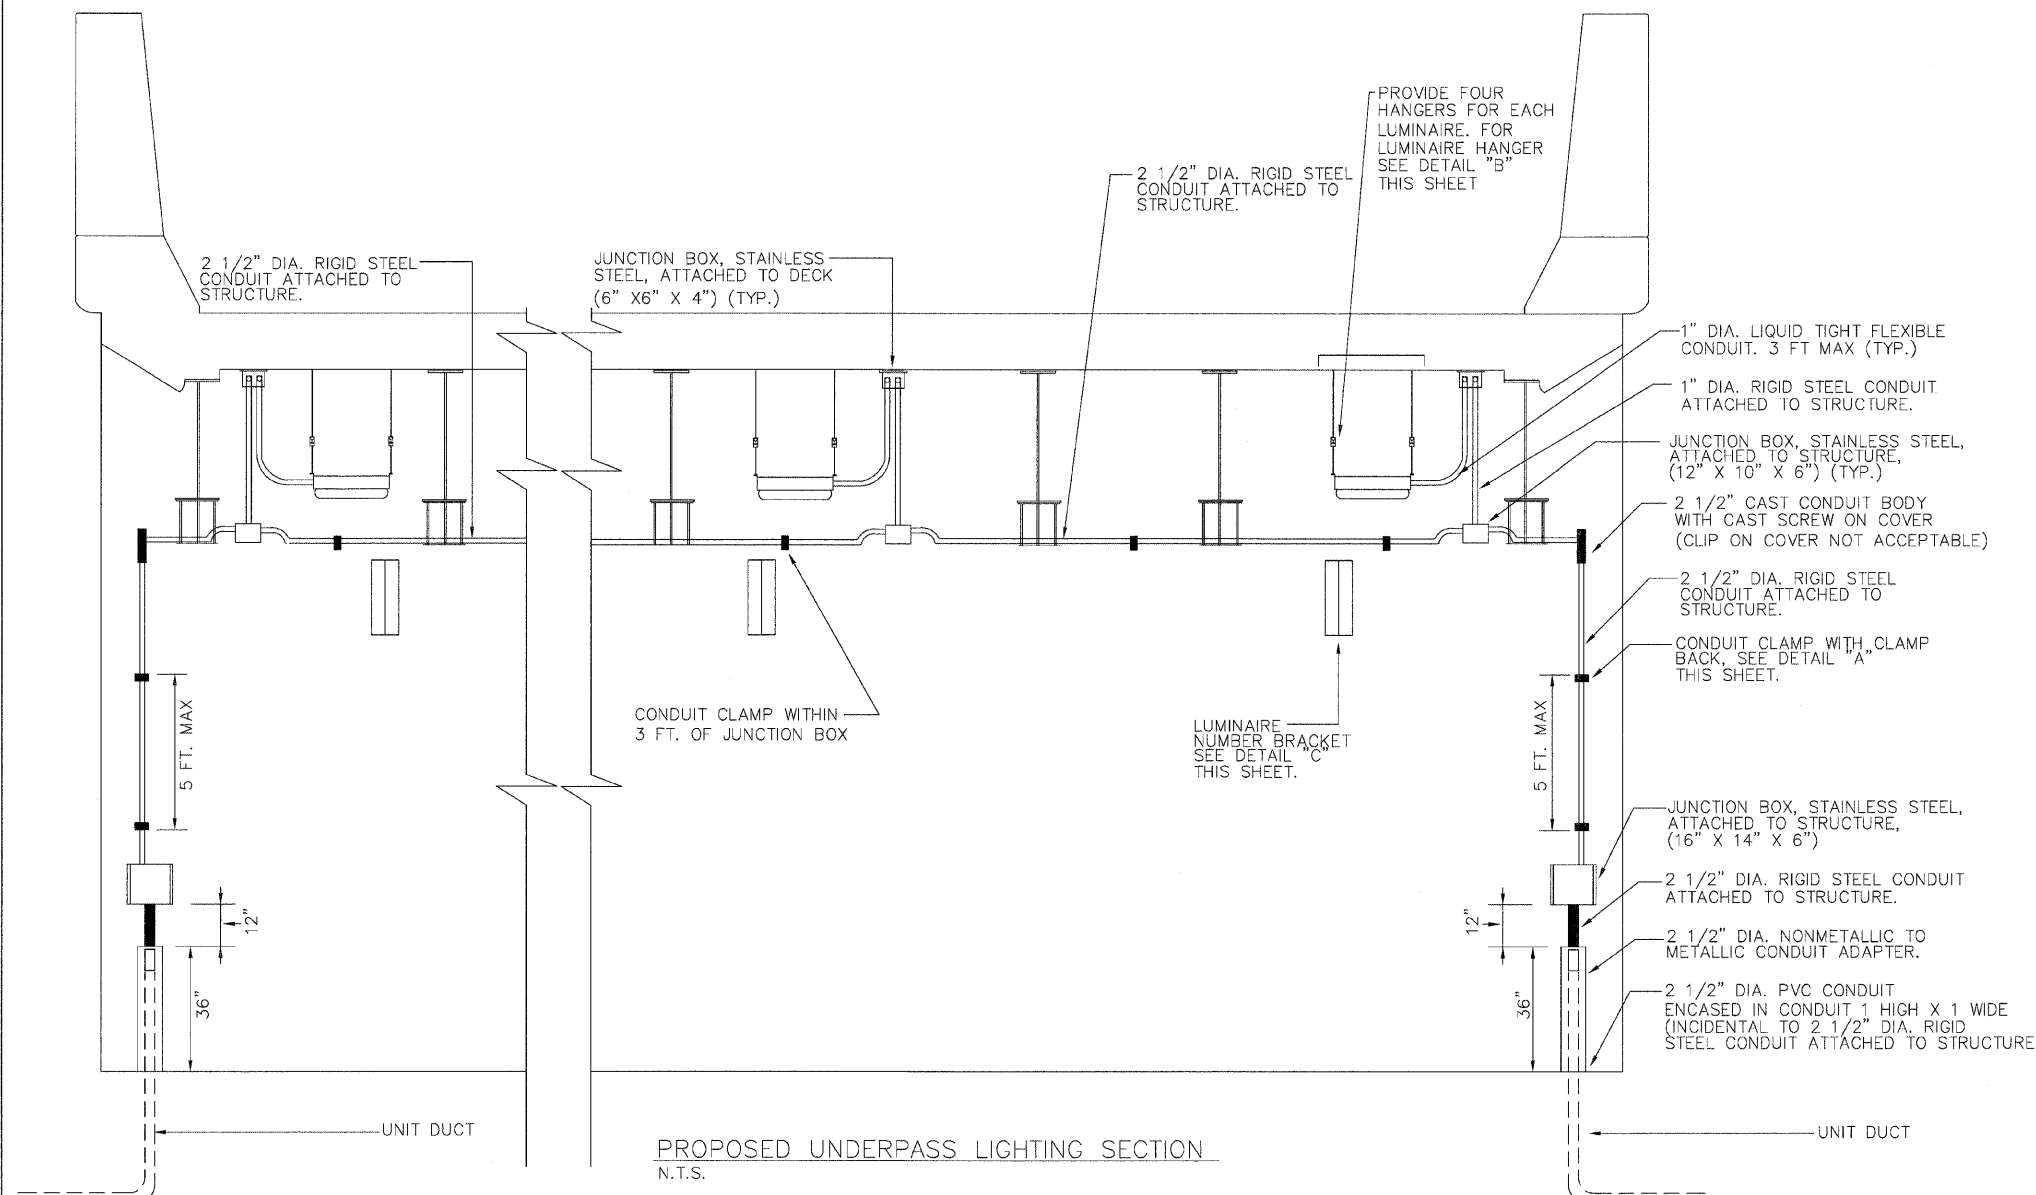

DETAIL B - LUMINAIRE HANGER ASSEMBLY

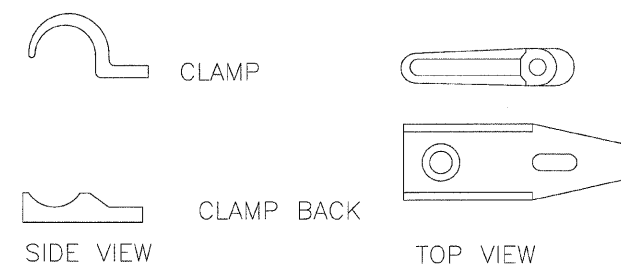

DETAIL A - CONDUIT CLAMP

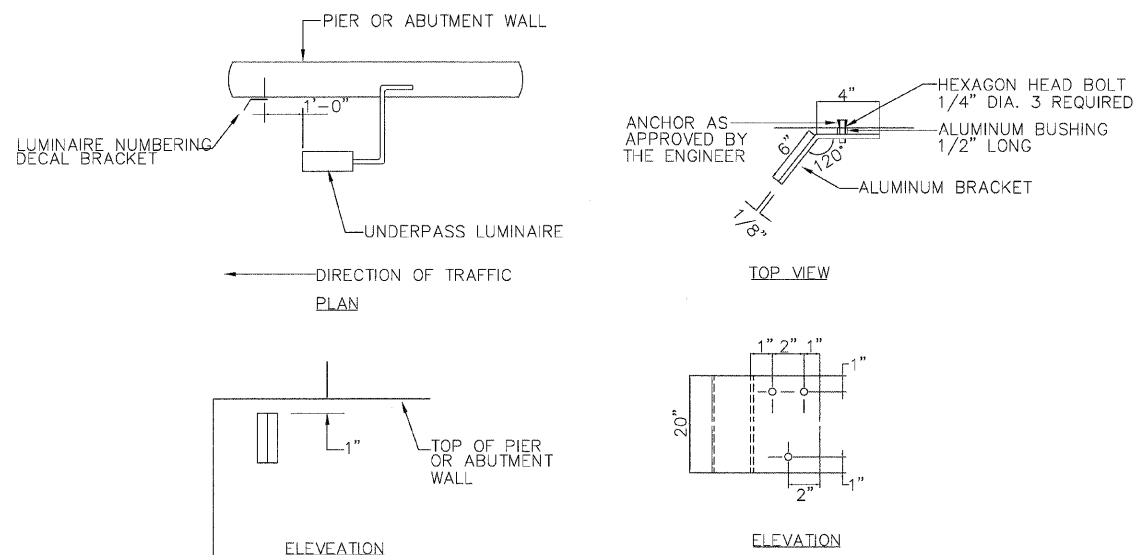

DETAIL C - LUMINAIRE NUMBERING DECAL BRACKET

Advance
Consulting Group International

300 W. ADAMS ST.
SUITE 320
CHICAGO, IL 60606
TEL: 312-351-1840
FAX: 312-351-1845
EMAIL: advance@cgint.com

REVISIONS	
NAME	DATE

ILLINOIS DEPARTMENT OF TRANSPORTATION

GENOA AVE
ELECTRICAL DETAILS

DATE 8-4-09

DRAWN BY EHE
CHECKED BY EE