


SURVEYED
 PLOTTED
 CHECKED
 NO. OF DAYS
 CAD FILE NAME



FILE NAME = s:\proj\66001-66993\6628\004\macro\Drainage P & P\DrainageCenter P&P-01.dgn
 SURVEYED
 PLOTTED
 CHECKED
 NO. OF DAYS
 CAD FILE NAME

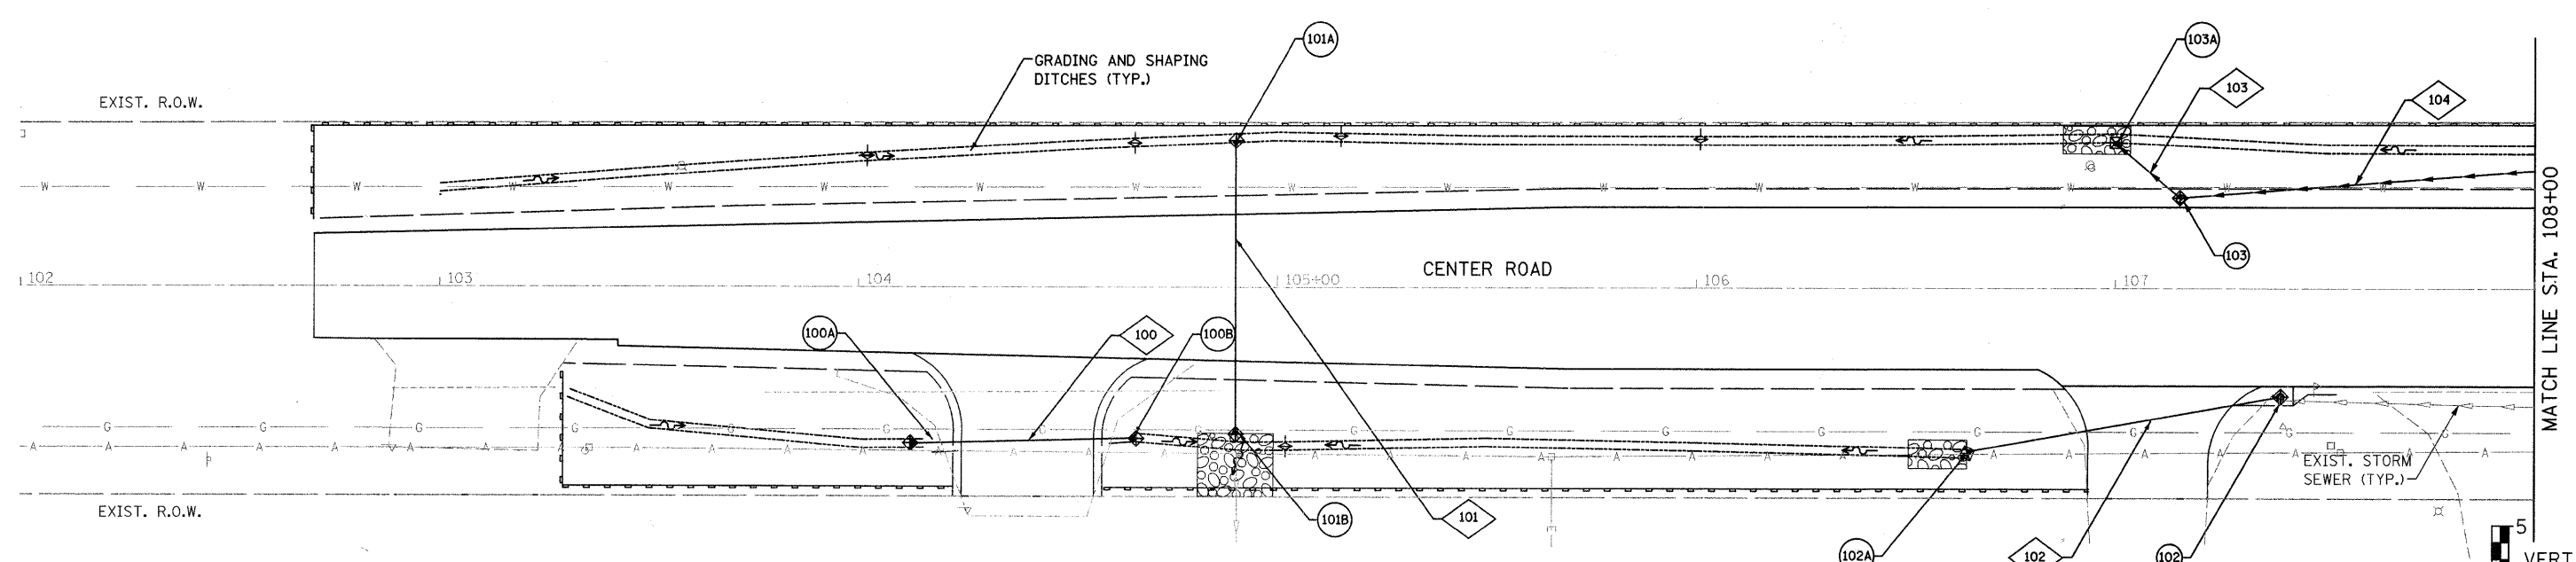

- ◇ PIPE NUMBER
- STRUCTURE NUMBER

SEWER PIPE SCHEDULE							DRAINAGE STRUCTURE SCHEDULE						
STR NO.	PIPE MATERIAL	PIPE SIZE (IN)	PIPE LENGTH (FT)	INVERT ELEVATION (PIPE ONLY)		Slope (%)	STR NO.	STR TY	STATION	OFFSET	RIM EL.	CASTING TYPE	TYPE OF WORK TO BE COMPLETED
				UP	DOWN								
100	CULV, CL A, TY I	12	41.0	765.46	765.02	1.07%	100A	FES	104+13	37.3 RT	765.53	-	PRECAST REINF. CONC, FES, 12"
101	CULV, CL A, TY I	24	60.0	765.09	764.68	0.68%	100B	FES	104+65	36.2 RT	764.95	-	PRECAST REINF. CONC, FES, 12"
102	SS, CL A, TY I	15	70.0	767.80	766.24	2.23%	101A	FES	104+90	35.0 LT	765.13	-	PRECAST REINF. CONC, FES, 24"
103	SS, CL A, TY II	18	13.0	767.83	767.80	0.23%	101B	FES	104+90	34.4 RT	764.63	-	PRECAST REINF. CONC, FES, 24"
104	SS, CL A, TY II	18	147.0	768.34	767.93	0.28%	102	CB	107+40	28.8 RT	771.55	TYPE 1	CB, TY A, 4' DIA
							102A	FES	106+65	39.1 RT	766.11	-	PRECAST REINF. CONC, FES, 15"
							103	MH	107+15	21.8 LT	771.74	TYPE 1	MH, TY A, 4' DIA
							103A	FES	107+00	34.6 LT	767.78	-	PRECAST REINF. CONC, FES, 18"

NOTE:
RIM ELEVATION AND OFFSET FOR STRUCTURES LOCATED IN CURB LINE ARE MEASURED TO THE BACK AND TOP OF CURB.

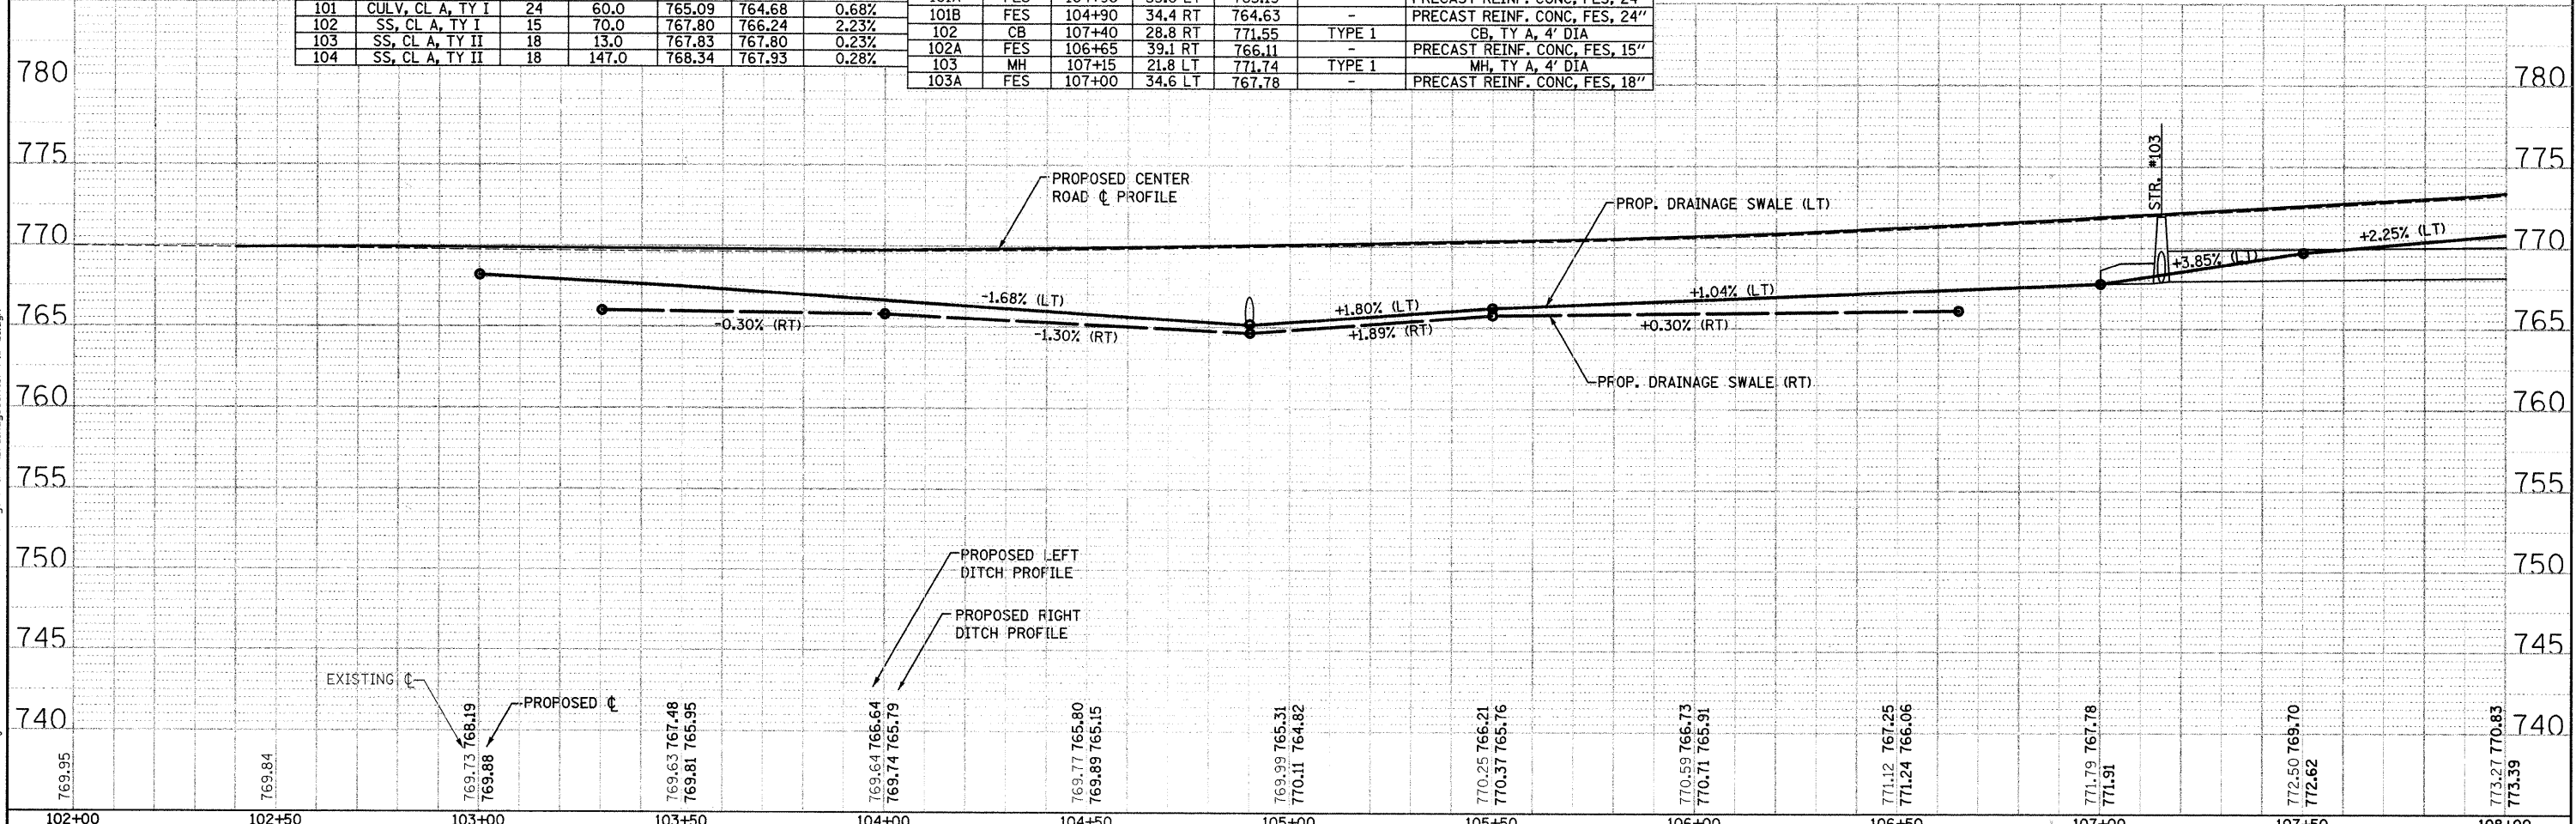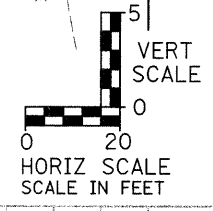

102+00	102+50	103+00	103+50	104+00	104+50	105+00	105+50	106+00	106+50	107+00	107+50	108+00
769.95	769.84	769.73 768.19 769.88	769.63 767.48 769.81 765.95	769.64 766.64 769.74 765.79	769.77 765.80 769.89 765.15	769.99 765.31 770.11 764.82	770.25 766.21 770.37 765.76	770.59 766.73 770.71 765.91	771.12 767.25 771.24 766.06	771.79 767.78 771.91	772.50 769.70 772.62	773.27 770.83 773.39

1170 SOUTH HOBOLT ROAD
JOLIET, ILLINOIS 60431
(815) 744-4200

USER NAME = edamm	DESIGNED -	REVISED -
PLOT SCALE = 20.0000' / IN.	CHECKED -	REVISED -
PLOT DATE = 3/21/2017	DRAWN -	REVISED -
	CHECKED -	REVISED -

STATE OF ILLINOIS
DEPARTMENT OF TRANSPORTATION

CENTER ROAD DRAINAGE AND UTILITY PLAN AND PROFILE

SCALE: AS SHOWN SHEET NO. OF SHEETS STA. TO STA.

F.A.U. RTE.	SECTION	COUNTY	TOTAL SHEETS	SHEET NO.
3759	04-00038-00-WR	WILL	165	45
CONTRACT NO. 63248				