


NOTES:  
1. SAG POINT AT 115+07, SEE UNDERDRAIN DETAIL

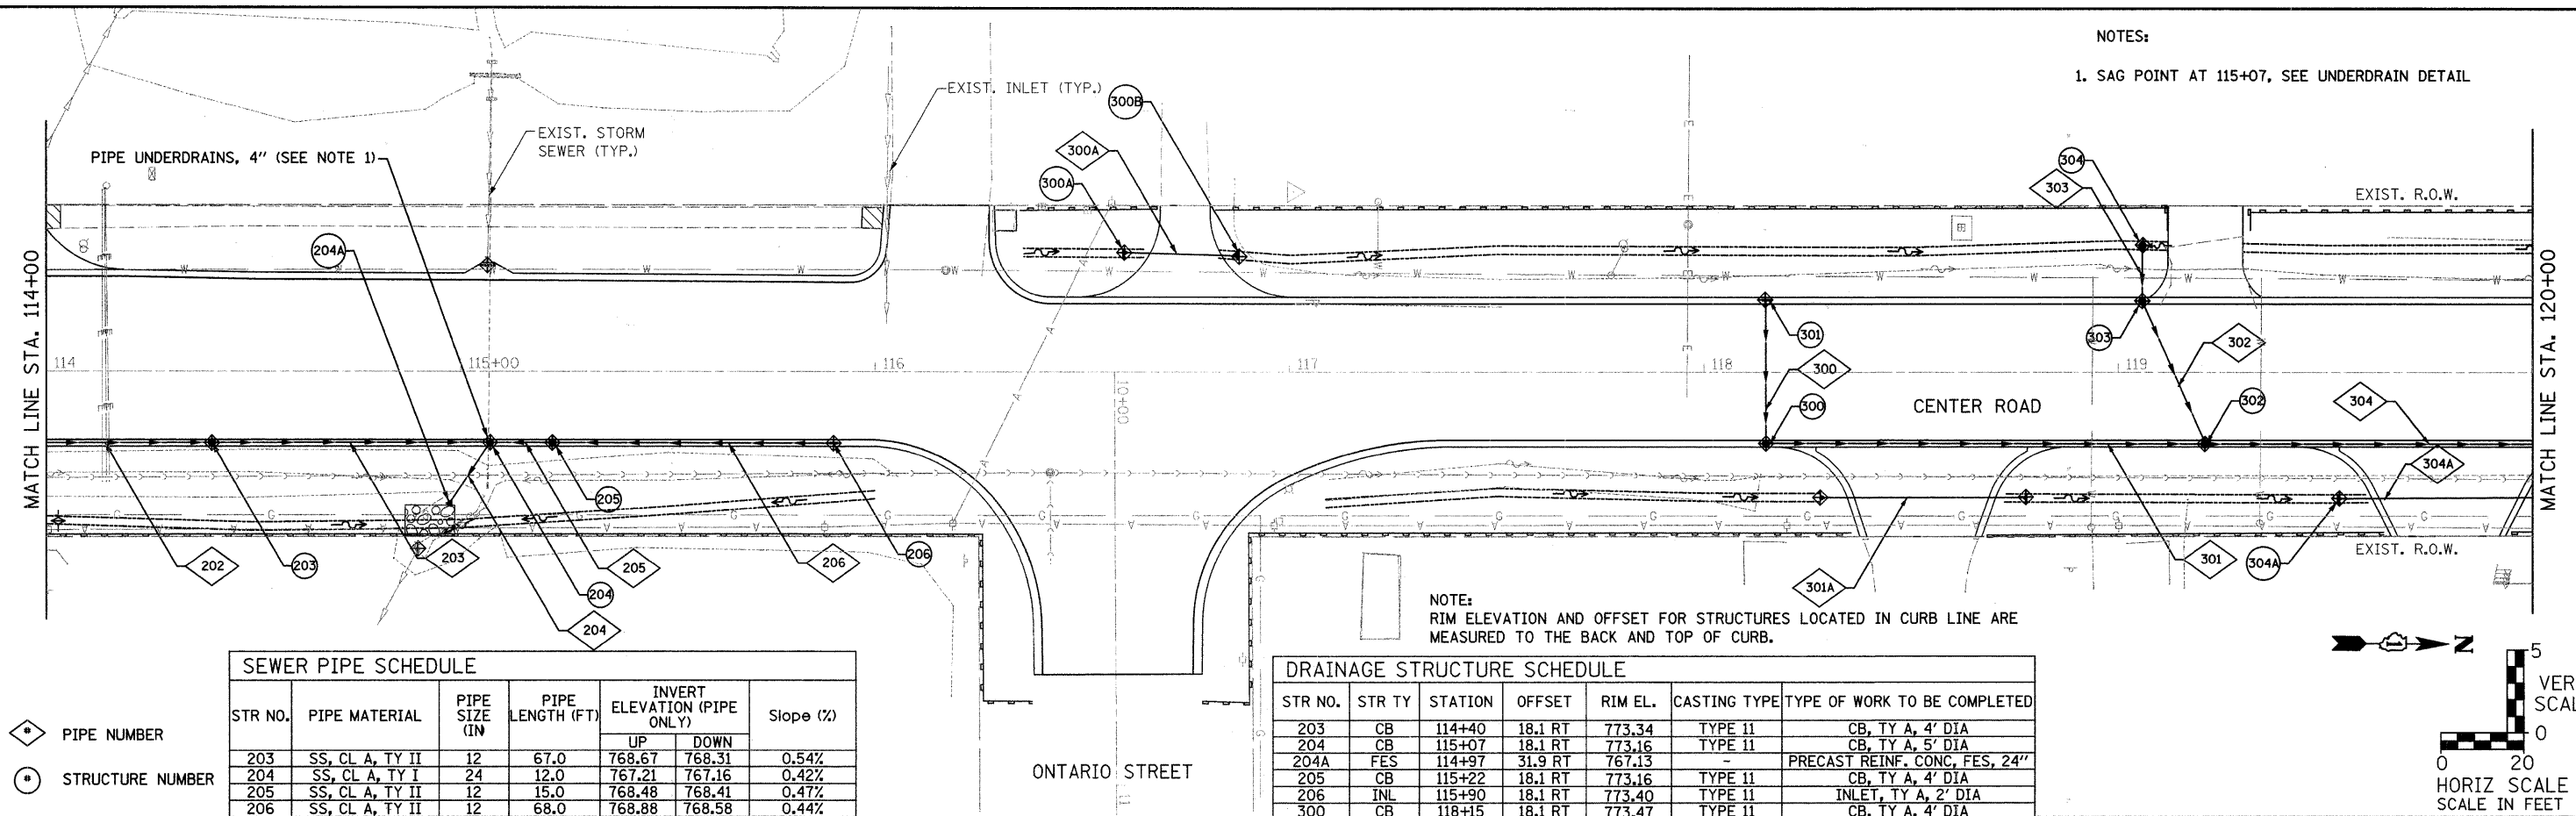



**SEWER PIPE SCHEDULE**

STR NO.	PIPE MATERIAL	PIPE SIZE (IN)	PIPE LENGTH (FT)	INVERT ELEVATION (PIPE ONLY)		Slope (%)
				UP	DOWN	
203	SS, CL A, TY II	12	67.0	768.67	768.31	0.54%
204	SS, CL A, TY I	24	12.0	767.21	767.16	0.42%
205	SS, CL A, TY II	12	15.0	768.48	768.41	0.47%
206	SS, CL A, TY II	12	68.0	768.88	768.58	0.44%
300	SS, CL A, TY II	12	35.0	769.00	768.86	0.40%
300A	CULV, CL A, TY I	12	16.0	771.70	771.65	0.31%
301	SS, CL A, TY II	12	106.0	767.87	767.18	0.65%
301A	CULV, CL A, TY I	12	38.0	770.78	770.61	0.45%
302	SS, CL A, TY II	15	39.0	767.16	767.03	0.33%
303	SS, CL A, TY II	15	12.0	767.32	767.26	0.50%
304	SS, CL A, TY II	15	96.0	767.08	766.56	0.54%
304A	CULV, CL A, TY I	12	43.0	770.15	769.96	0.45%

\*SEE PREVIOUS SHEET FOR PIPE 202.

**DRAINAGE STRUCTURE SCHEDULE**

STR NO.	STR TY	STATION	OFFSET	RIM EL.	CASTING TYPE	TYPE OF WORK TO BE COMPLETED
203	CB	114+40	18.1 RT	773.34	TYPE 11	CB, TY A, 4' DIA
204	CB	115+07	18.1 RT	773.16	TYPE 11	CB, TY A, 5' DIA
204A	FES	114+97	31.9 RT	767.13	-	PRECAST REINF. CONC, FES, 24"
205	CB	115+22	18.1 RT	773.16	TYPE 11	CB, TY A, 4' DIA
206	INL	115+90	18.1 RT	773.40	TYPE 11	INLET, TY A, 2' DIA
300	CB	118+15	18.1 RT	773.47	TYPE 11	CB, TY A, 4' DIA
300A	FES	116+60	28.7 LT	771.72	-	PRECAST REINF. CONC, FES, 12"
300B	FES	116+87	28.0 LT	771.63	-	PRECAST REINF. CONC, FES, 12"
301	INL	118+15	18.1 LT	773.47	TYPE 11	INLET, TY A, 2' DIA
301A	FES	118+29	30.5 RT	770.18	-	PRECAST REINF. CONC, FES, 12"
301B	FES	118+78	30.5 RT	769.93	-	PRECAST REINF. CONC, FES, 12"
302	CB	119+21	18.1 RT	773.02	TYPE 11	CB, TY A, 5' DIA
303	CB	119+05	18.1 LT	773.08	TYPE 11	CB, TY A, 4' DIA
304	CB	119+05	30.9 LT	770.69	TYPE 8	CB, TY A, 4' DIA
304A	FES	119+53	30.8 RT	770.18	-	PRECAST REINF. CONC, FES, 12"

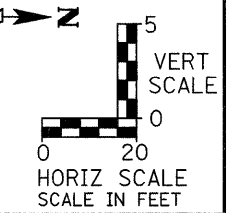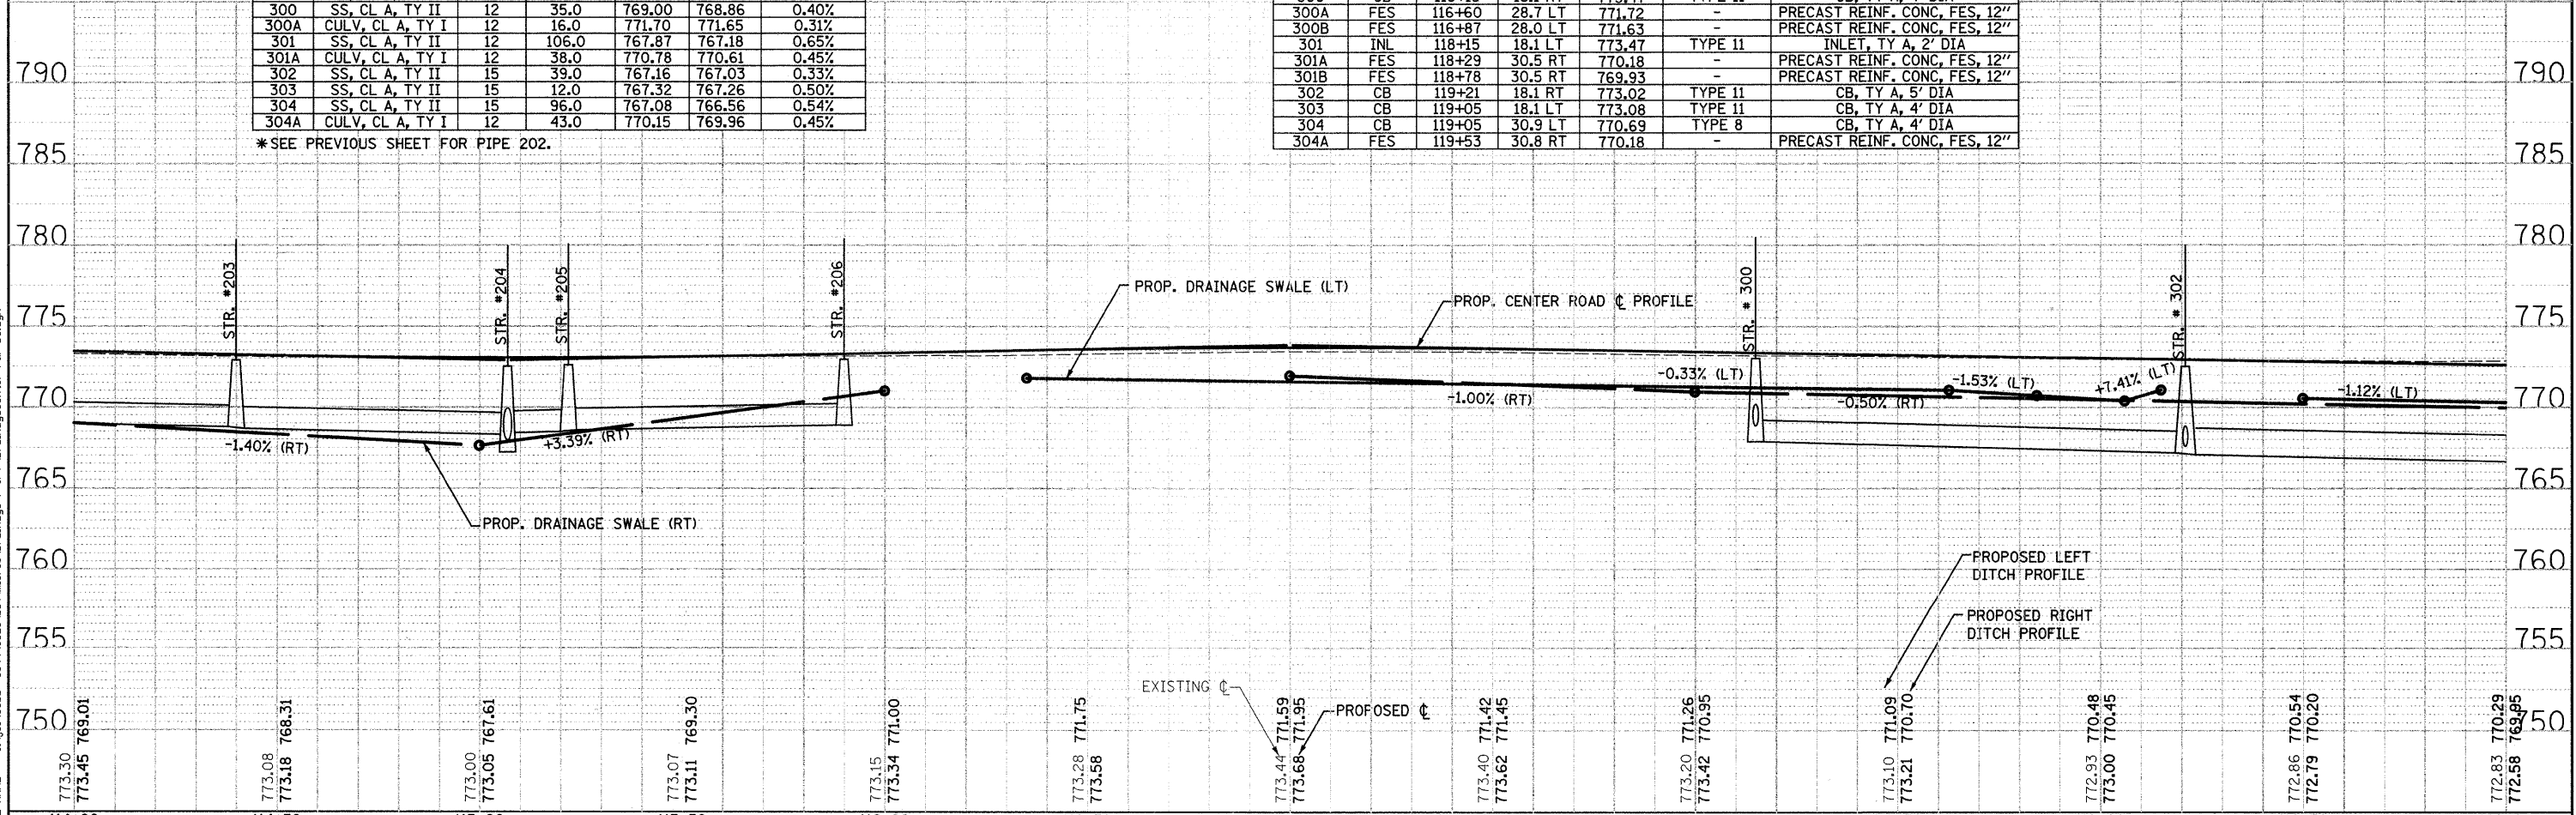

UNREVIEWED  
 PLOTTED  
 CHECKED  
 DATE OF WAY CHECKED  
 NO. \_\_\_\_\_  
 FILE NAME

SURVEY ILL  
 PLOTTED  
 CHECKED  
 DATE NOTED  
 STRUCTURE NOTATION CHRD  
 NO. \_\_\_\_\_  
 FILE NAME = s:\proj\6600-6899\6628\00A\macros\Drainage P & U\DrainageCenter P&U.dgn

 1170 SOUTH HOBULT ROAD JOLIET, ILLINOIS 60431 (815) 744-4200	USER NAME = odamm DESIGNED - CHECKED - DRAWN - CHECKED -	REVISED - REVISED - REVISED - REVISED -	<b>STATE OF ILLINOIS DEPARTMENT OF TRANSPORTATION</b>		<b>CENTER ROAD DRAINAGE AND UTILITY PLAN AND PROFILE</b>		F.A.U. RTE. 3759 SECTION 04-00038-00-WR COUNTY WILL TOTAL SHEETS 165 SHEET NO. 47	CONTRACT NO. 63248
	PLOT SCALE = 20.0000' / IN. PLOT DATE = 3/31/2018			SCALE: AS SHOWN	SHEET NO. _____ OF _____ SHEETS	STA. _____ TO STA. _____	FED. ROAD DIST. NO. _____ ILLINOIS FED. AID PROJECT	