


LEGEND	
■	PROPOSED LIGHTING CONTROLLER
□	PROPOSED JUNCTION BOX
⊠	PROPOSED UNDERPASS LUMINAIRE
—E—	PROPOSED CONDUIT ATTACHED TO STRUCTURE, GALVANIZED STEEL, PVC COATED

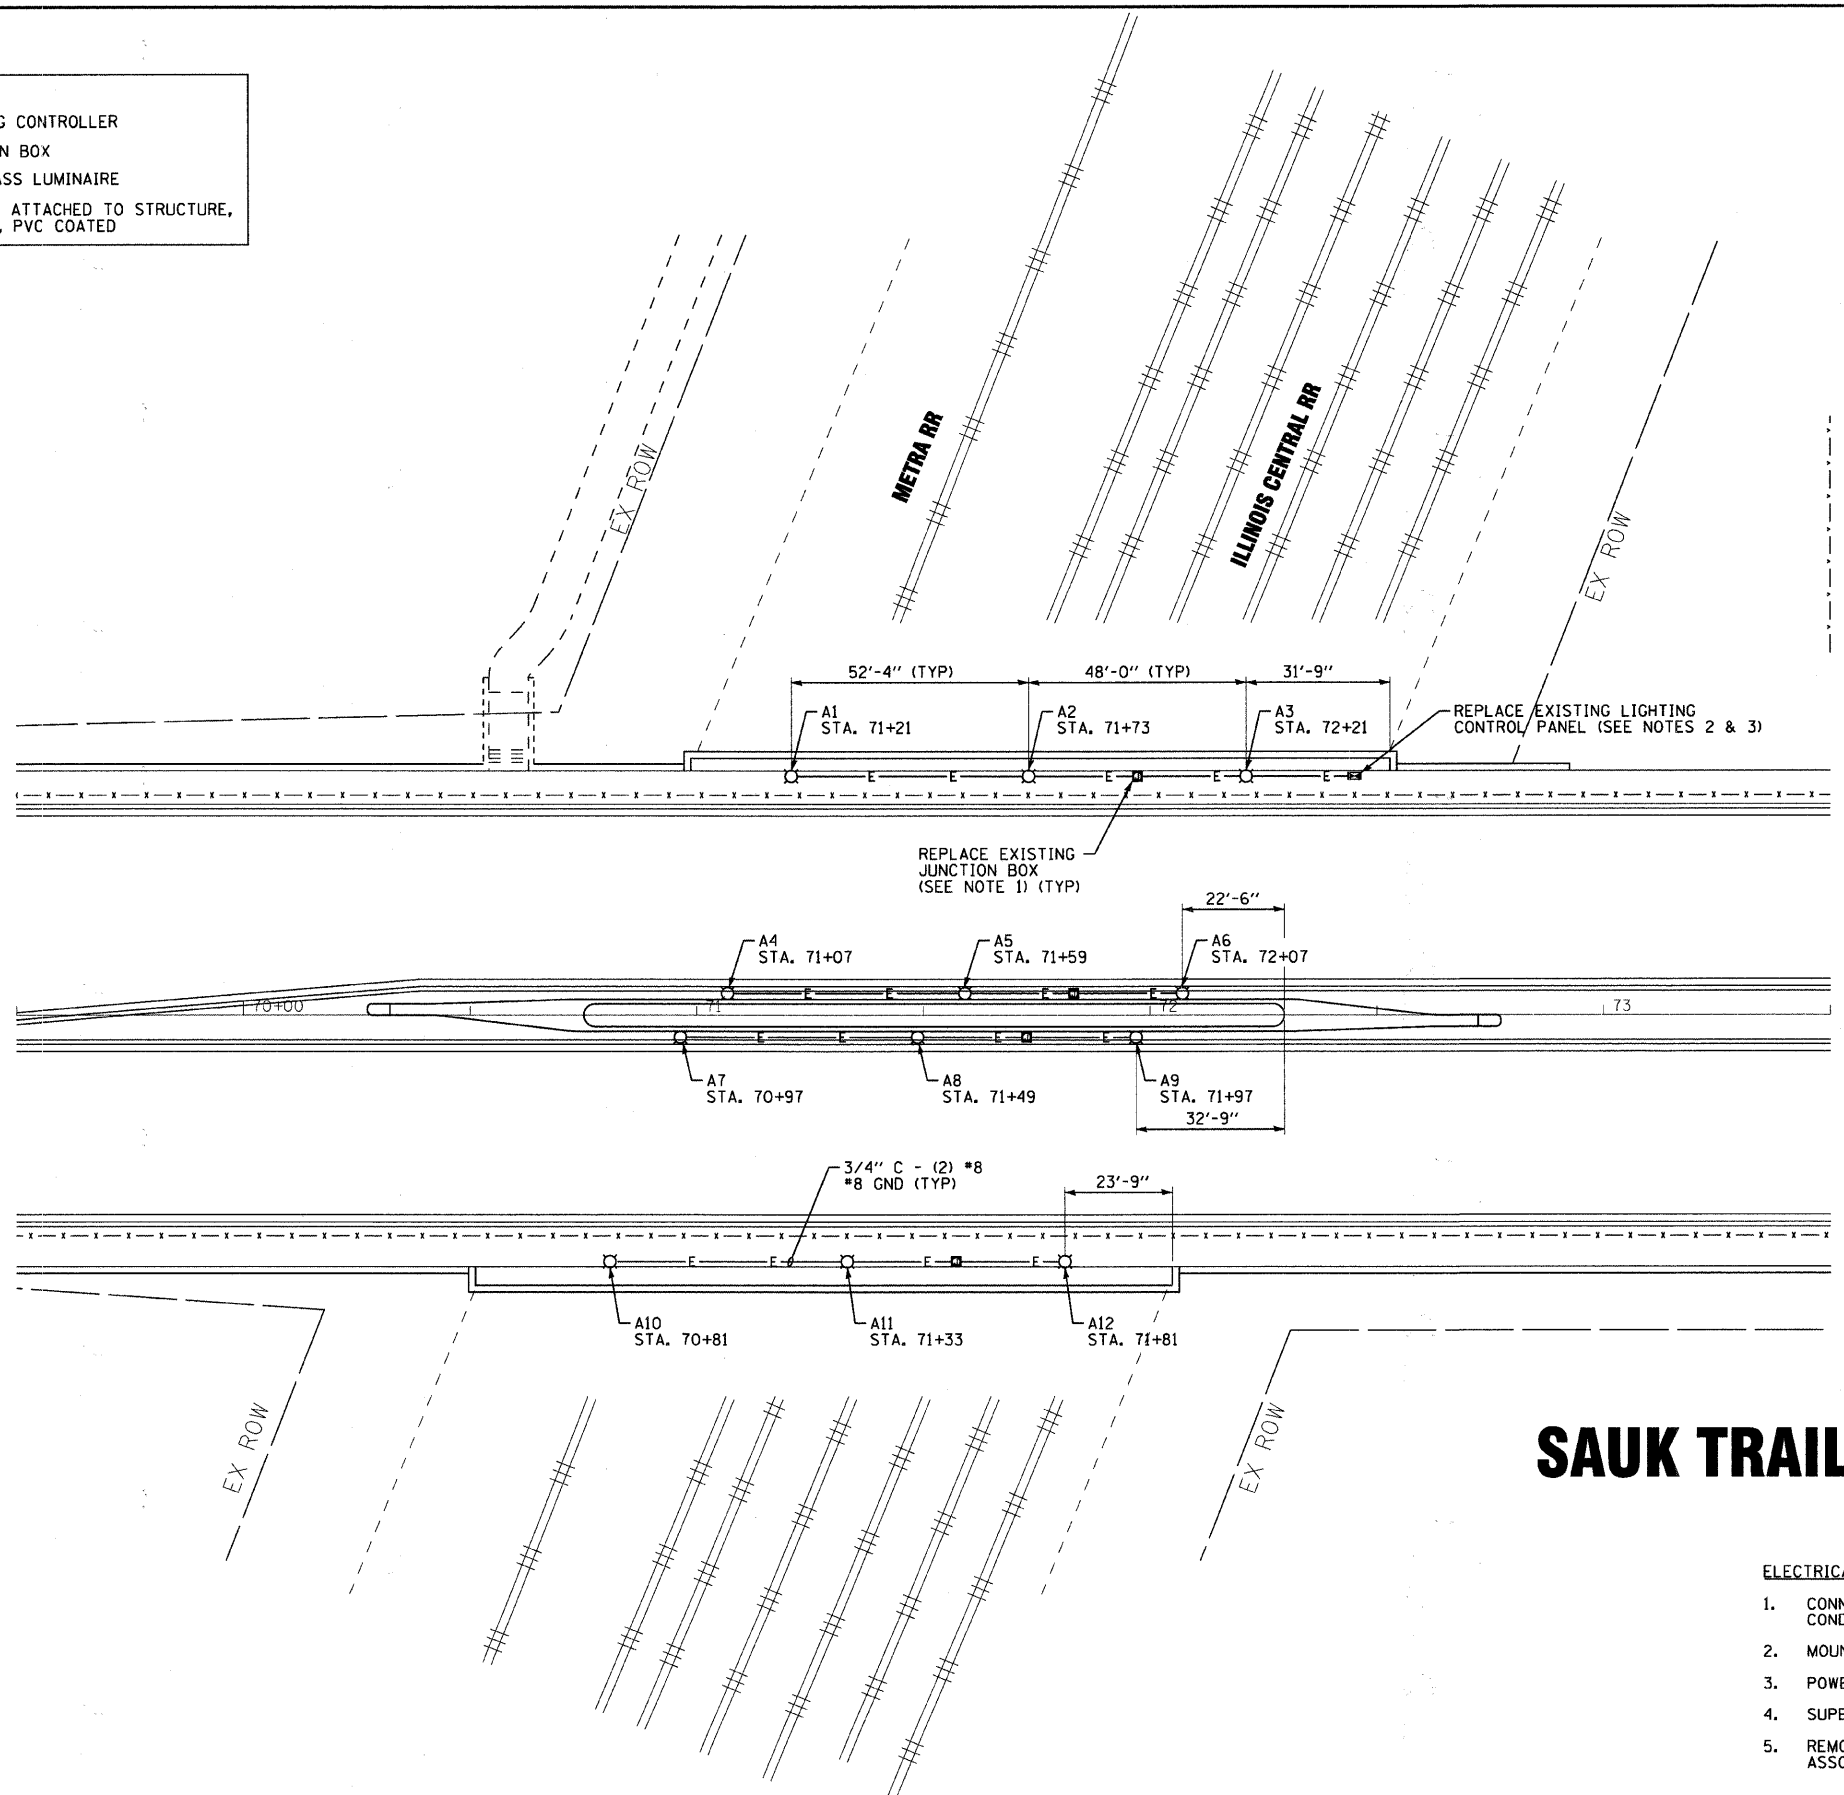

SAUK TRAIL

- ELECTRICAL GENERAL NOTES:**
1. CONNECT JUNCTION BOX TO EXISTING OVERHEAD LIGHTING CONDUIT (SEE DETAIL, SHEET 10).
 2. MOUNT ON NEW FACADE.
 3. POWER SUPPLIED FROM POWER PANEL IN PUMP STATION.
 4. SUPERSTRUCTURE REMOVED FOR CLARITY.
 5. REMOVE EXISTING UNDERPASS LIGHTING UNITS AND ASSOCIATED CONDUITS, ETC. ATTACHED TO PIER/ABUTMENT.

COPYRIGHT © 2008 BY BAXTER & WOODMAN, INC.
 ALL RIGHTS RESERVED. NO PART OF THIS DOCUMENT MAY BE REPRODUCED OR TRANSMITTED IN ANY FORM OR BY ANY MEANS, ELECTRONIC OR MECHANICAL, WITHOUT PERMISSION IN WRITING FROM BAXTER & WOODMAN, INC.
 LICENSE NO. 06-00041-00-LS - EXPIRES 4/30/2009
 928448 AM 1/22/2008
 S:\RCPK\070190\CADD-SURVEY\070190-0000-lighting-plan.dwg



DESIGNED - AS	REVISED -
DRAWN - KAR	REVISED -
CHECKED - TMS	REVISED -
DATE - 12-08-08	REVISED -

VILLAGE OF RICHTON PARK, ILLINOIS
FAU ROUTE 1632 (SAUK TRAIL)
STREETSCAPE

LIGHTING PLAN: SAUK TRAIL

SCALE: 1" = 20'
 STA. 69+50 TO STA. 73+50

F.A.U. RTE.	SECTION	COUNTY	TOTAL SHEETS	SHEET NO.
1632	06-00041-00-LS	COOK	11	7
CONTRACT NO. 63447				
FED. ROAD DIST. NO.		ILLINOIS FED. AID PROJECT		