
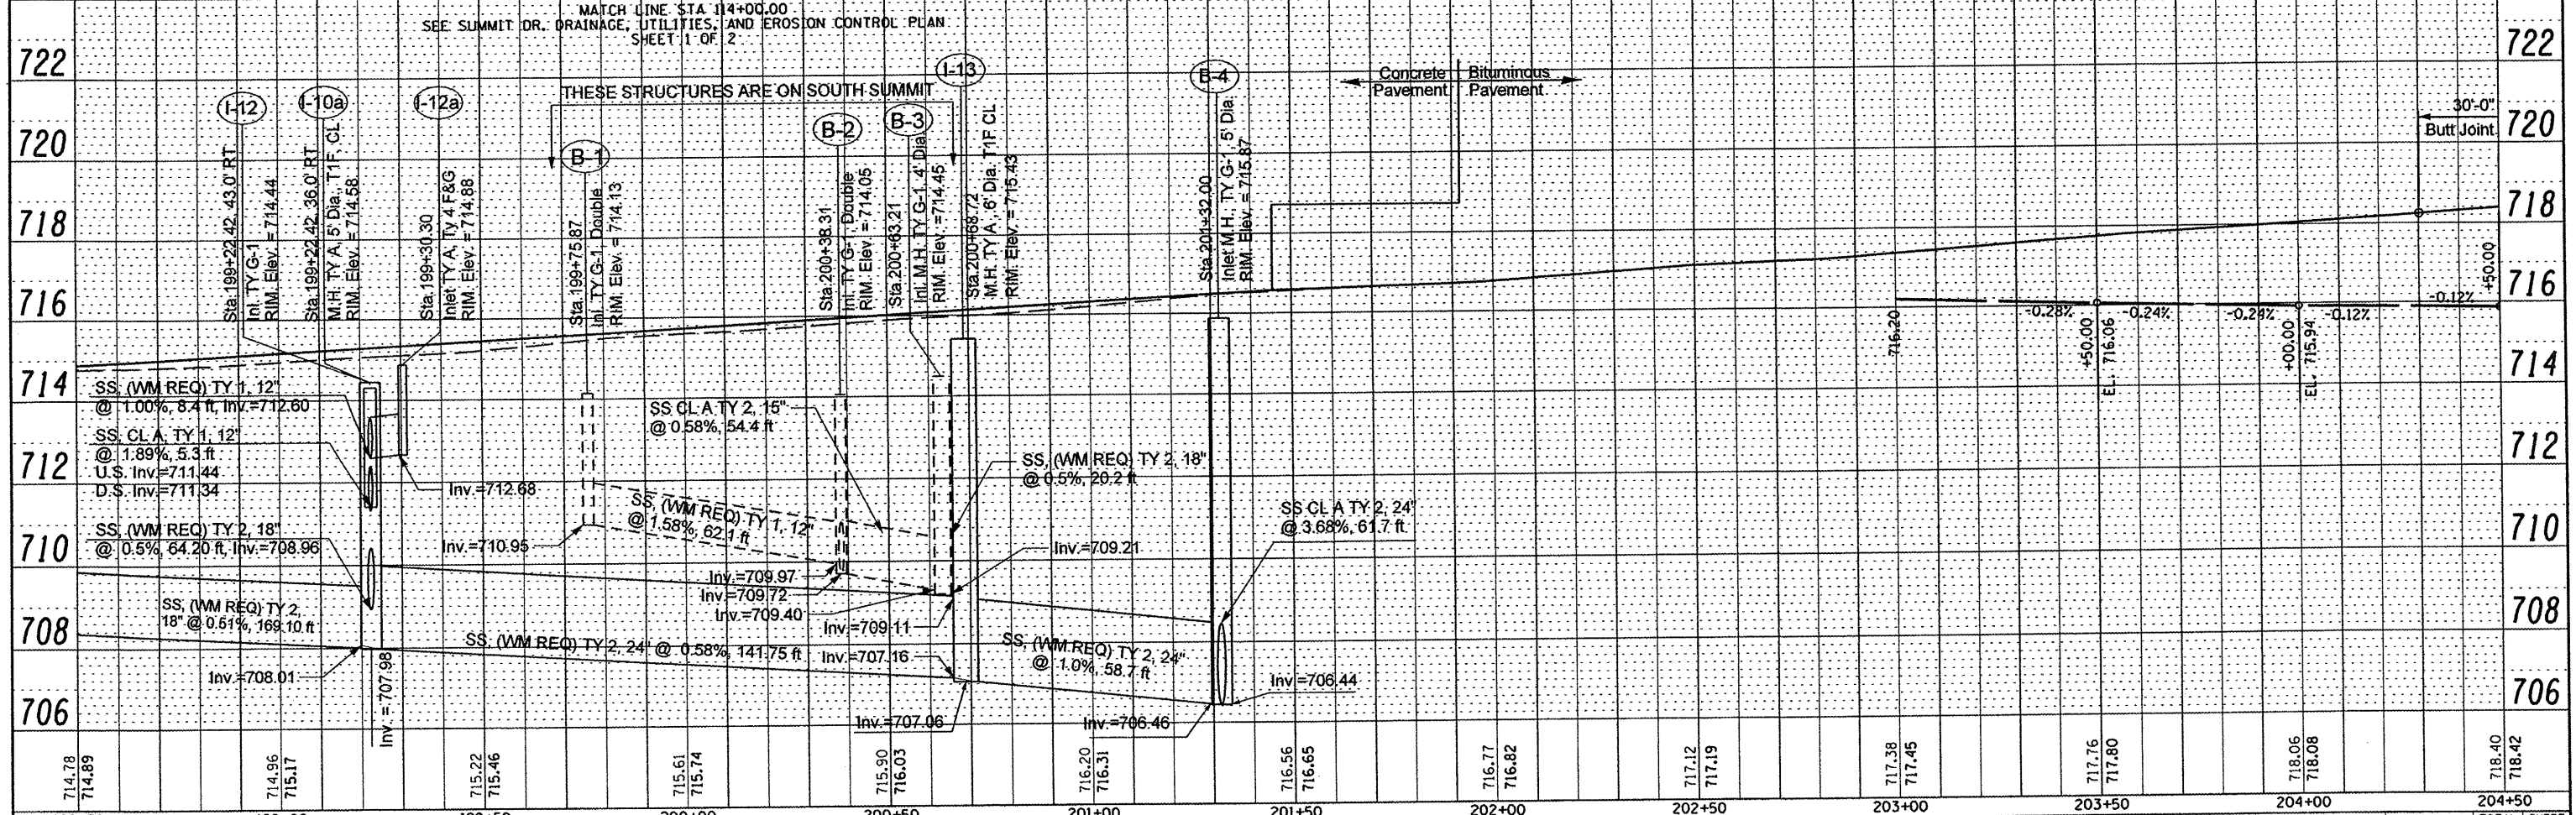


PLAN	DATE
SURVEYED	BY
ALIGNED	BY
CHECKED	BY
RT. OF WAY CHECKED	BY
NO. FILE NAME	

PROFILE	DATE
PLOTTED	BY
CHECKED	BY
NO. NOTED	
STRUCTURE NOTATIONS	
NO.	

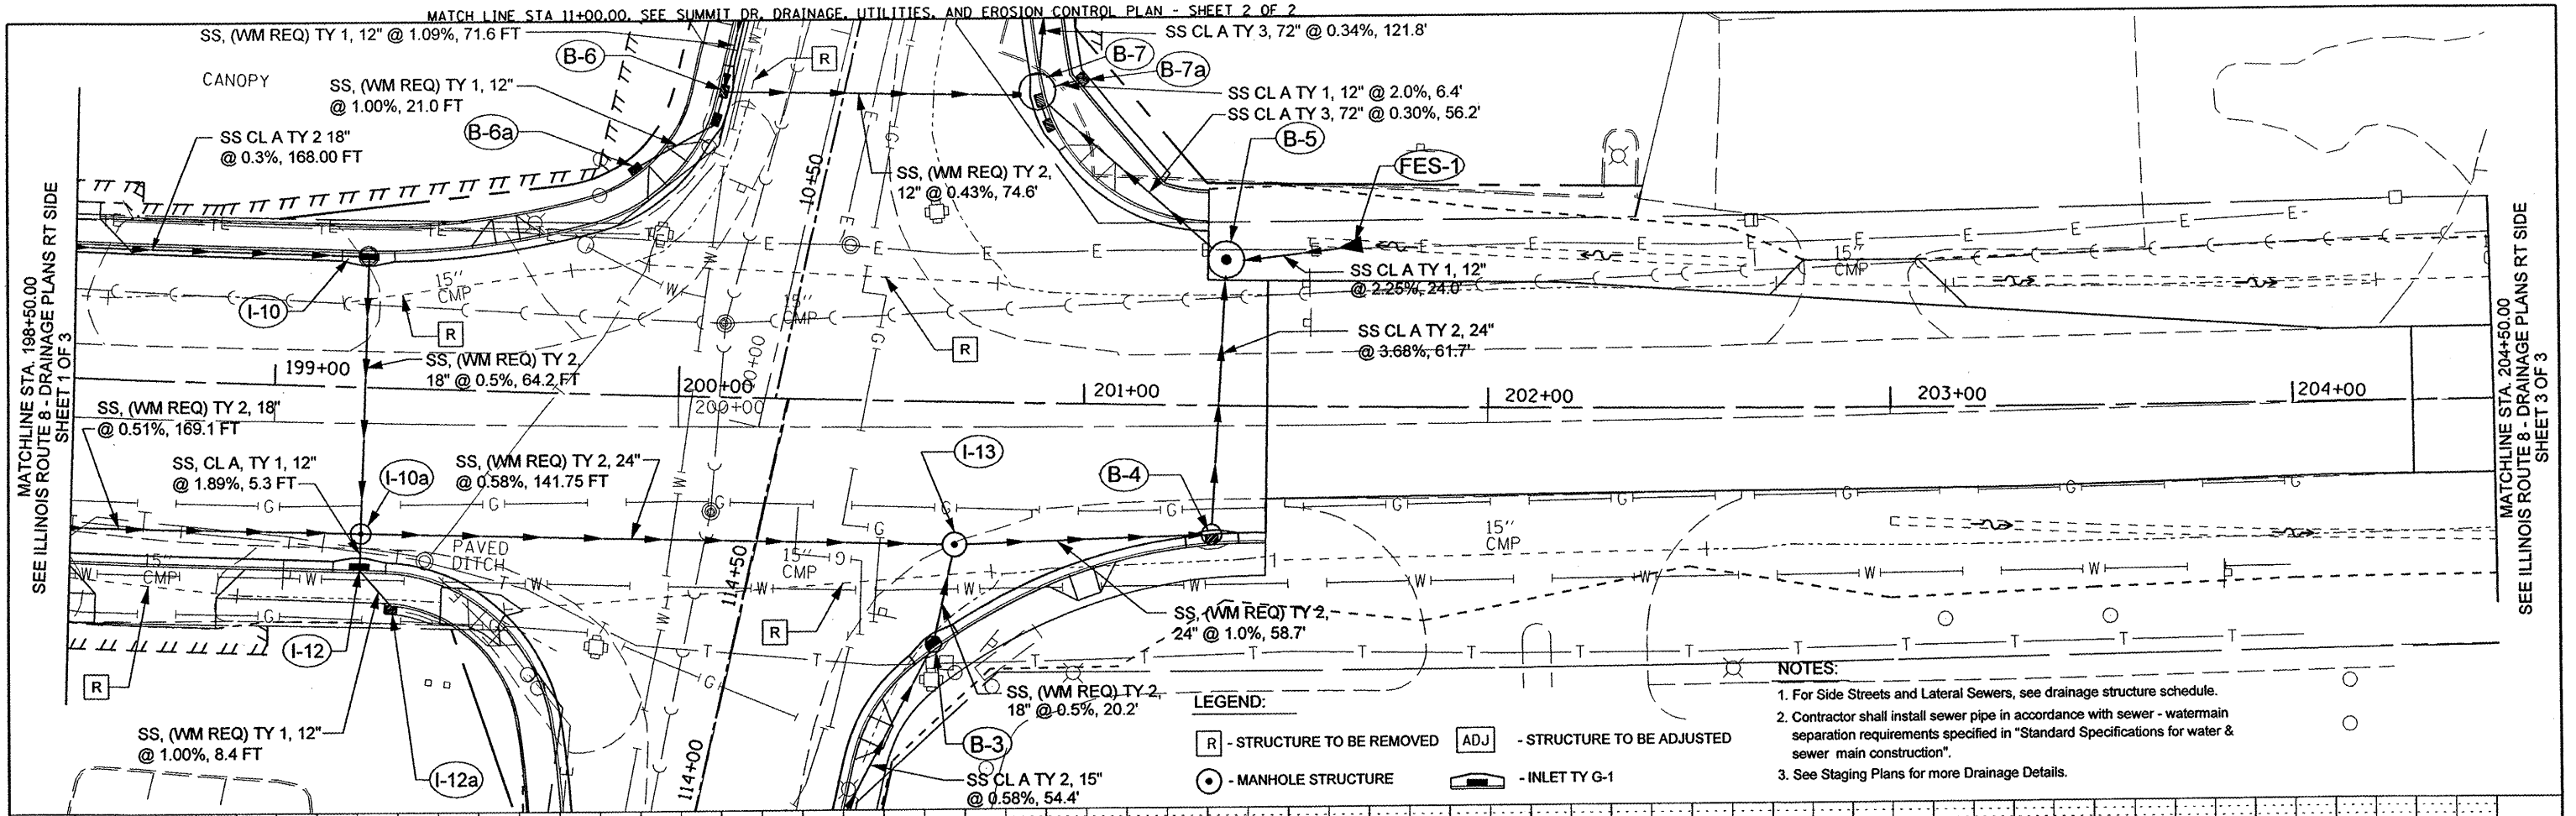

- NOTES:**
1. For Side Streets and Lateral Sewers, see drainage structure schedule.
  2. Contractor shall install sewer pipe in accordance with sewer - watermain separation requirements specified in "Standard Specifications for water & sewer main construction".
  3. See Staging Plans for more Drainage Details.

**STATE OF ILLINOIS  
DEPARTMENT OF TRANSPORTATION**

**ILLINOIS ROUTE 8  
DRAINAGE PLANS RT SIDE**

FILE NAME =	USER NAME = *USER*	DESIGNED -	REVISED -	SCALE: 1" = 20'-0" SHEET NO. 2 OF 3 SHEETS STA. 198+50.00 TO STA. 204+50.00	F.A.U. RTE. 6775 SECTION 04-00141-00-FP COUNTY TAZEWELL TOTAL SHEETS 187 SHEET NO. 77 CONTRACT NO. 89352 ILLINOIS FED. AID PROJECT
#FILE#		DRAWN -	REVISED -		
PLOT SCALE = \$SCALE#		CHECKED -	REVISED -		
PLOT DATE = \$DATE#		DATE -	REVISED -		