
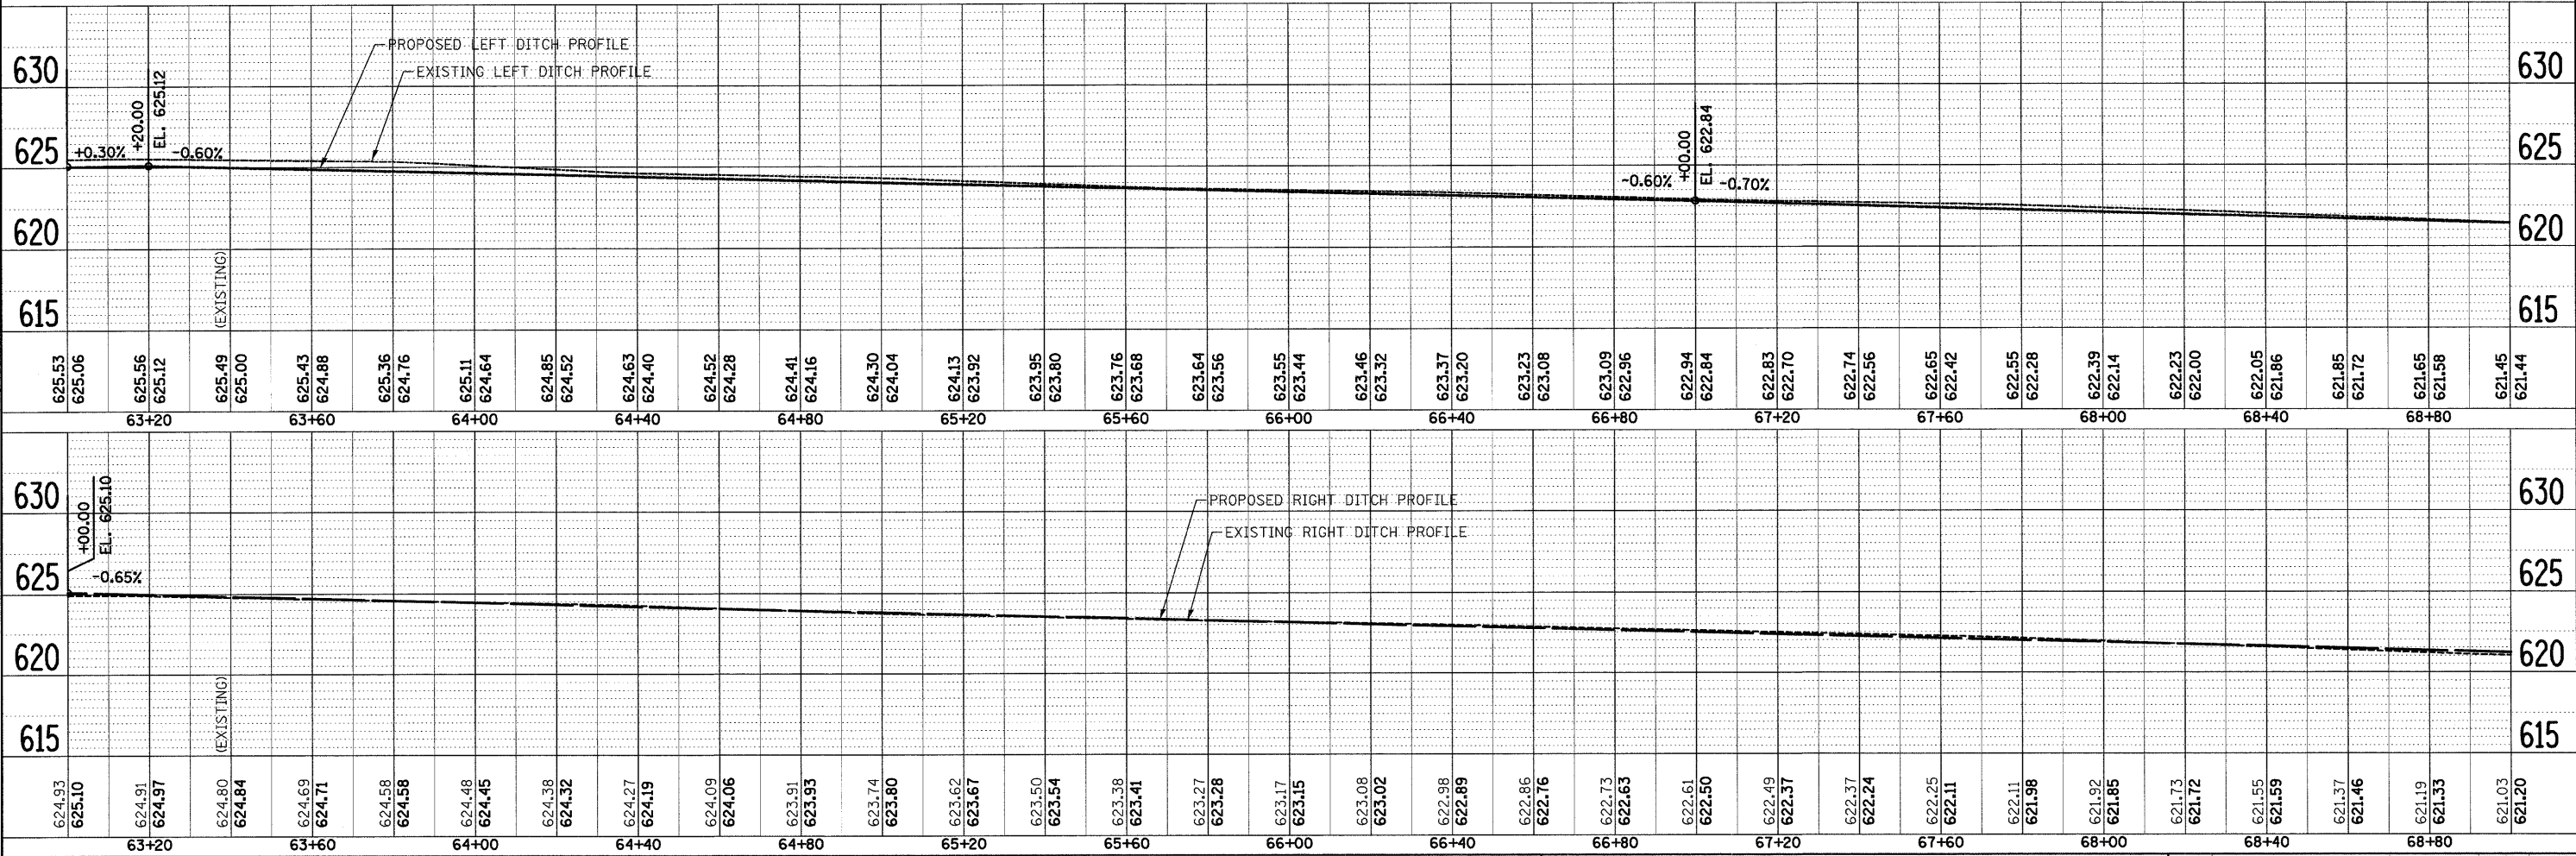


PLAN	SURVEYED	BY	DATE
	PLOTTED		
	REVISIONS		
	NOTE BOOK		
	NO. OF SHEETS		
	CADD FILE NAME		

PROFILE	DESIGNED	BY	DATE
	CHECKED		
	PLOTTED		
	STRUCTURE		
	NOTATIONS		
	CHD		

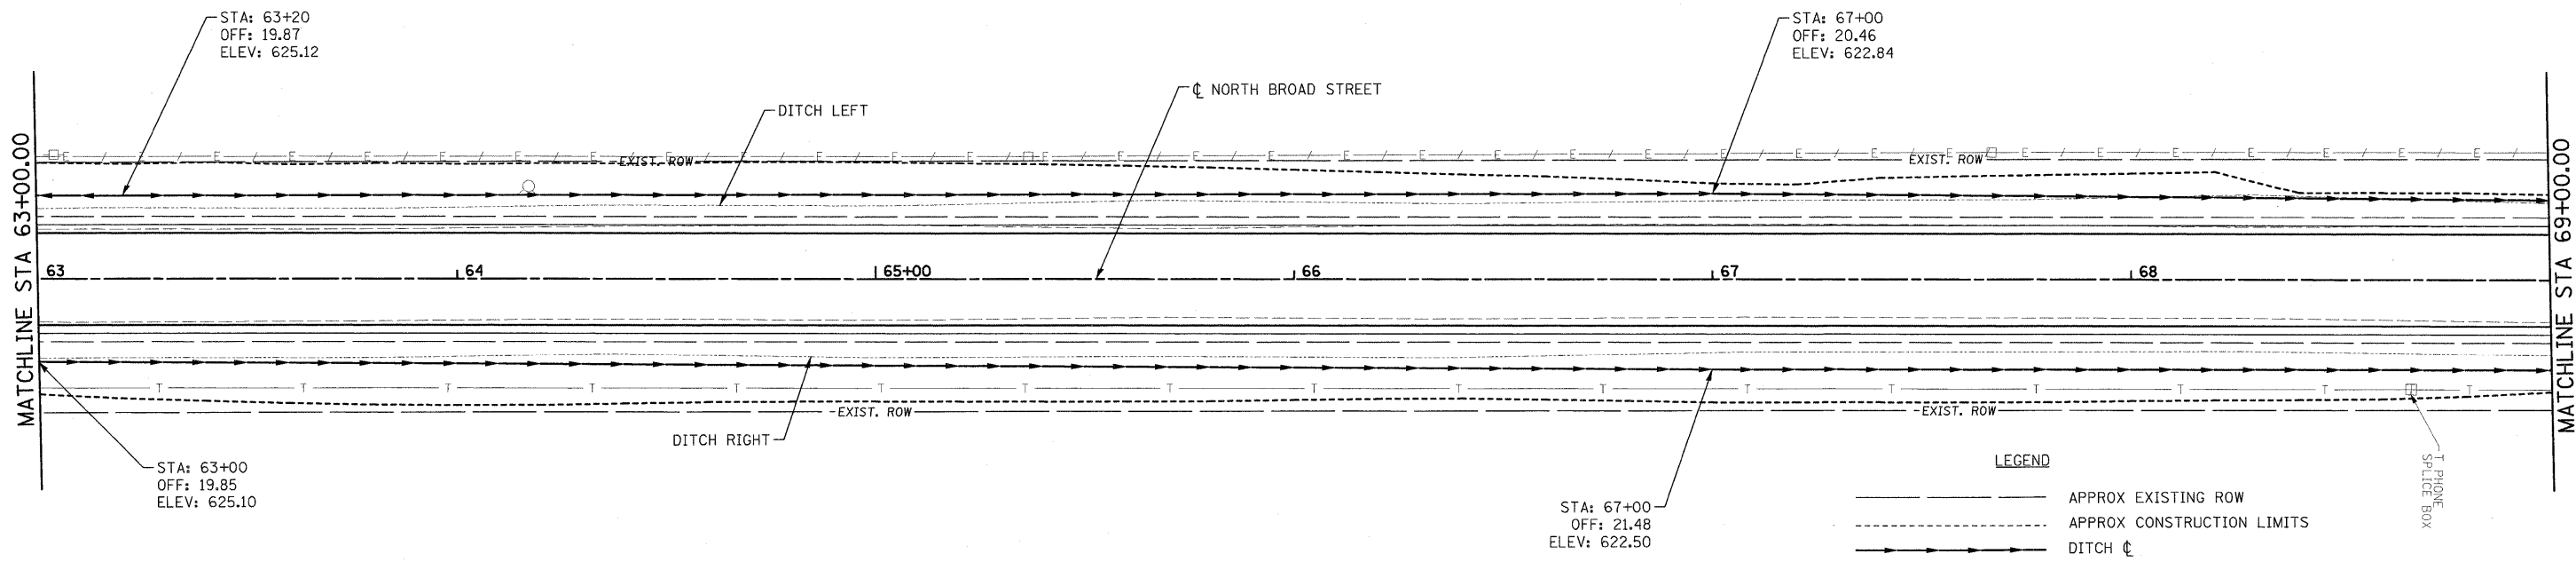

FILE NAME = H:\6373_Carlinville_Broad_Street_DT_PP_6373.dgn	USER NAME = _USERDESCR.	DESIGNED - DLD	REVISED -	STATE OF ILLINOIS DEPARTMENT OF TRANSPORTATION	DRAINAGE PLAN & PROFILE NORTH BROAD STREET				F.A.U. 8277	SECTION 09-00036-00-RS	COUNTY MACOUPIN	TOTAL SHEETS 38	SHEET NO. 18
PLOT SCALE = 20.0000' / IN.	PLOT DATE = 2/11/2010	CHECKED - KOJ	REVISED -		SCALE:	SHEET NO.	OF	SHEETS	STA.	TO STA.	CONTRACT NO. 9 3 5 2 8		
		DRAWN -	REVISED -		ILLINOIS FED. AID PROJECT								
		CHECKED -	REVISED -										