


EXISTING

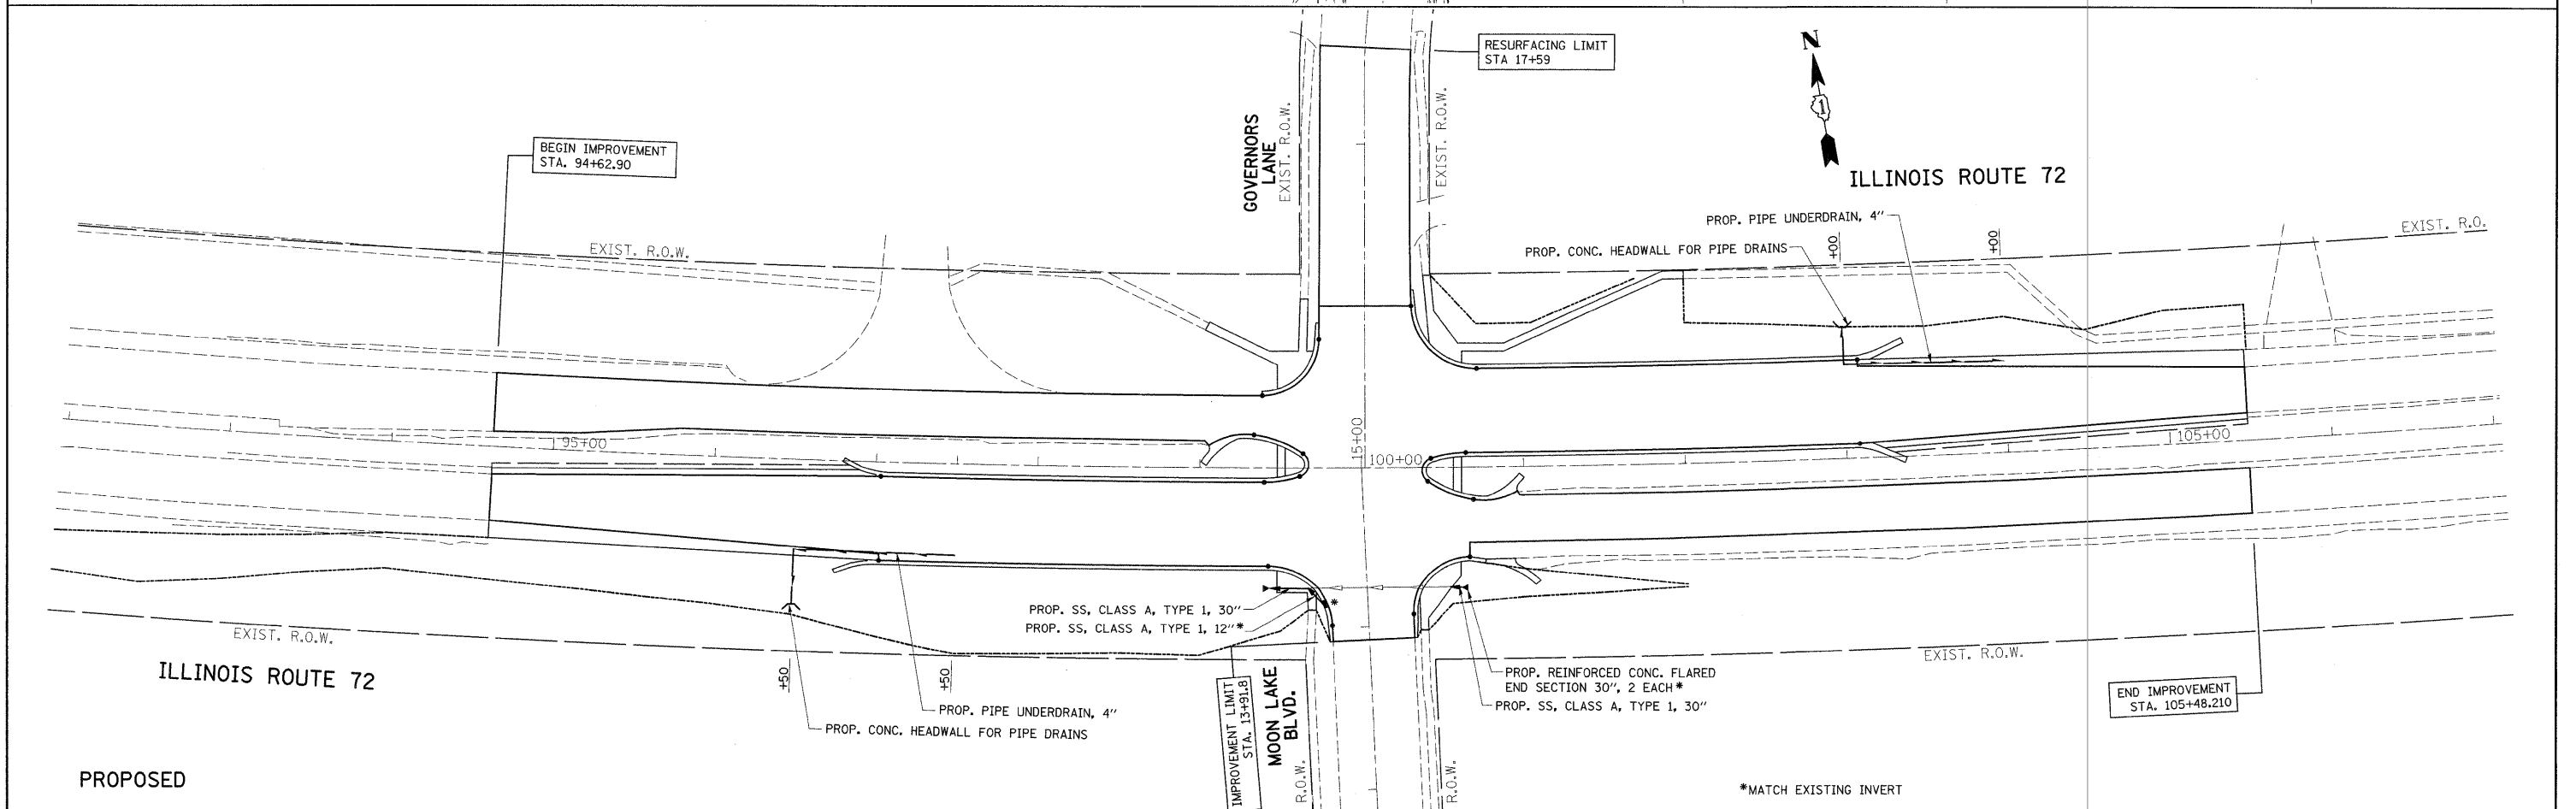

PROPOSED

FILE NAME =	USER NAME = bauerdl
c:\pwork\pwork\baue\dl\0103868\01498	08-shd-drain.dgn
PLOT SCALE = 50.0000' / IN.	
PLOT DATE = 3/20/2009	

DESIGNED -	REVISED -
DRAWN -	REVISED -
CHECKED -	REVISED -
DATE -	REVISED -

STATE OF ILLINOIS
DEPARTMENT OF TRANSPORTATION

EXISTING & PROPOSED DRAINAGE & UTILITY PLAN
IL. RTE. 72 (HIGGINS RD) @ MOONLAKE BLVD/GOVERNOR'S LANE

SCALE: 1"=50' SHEET NO. OF SHEETS STA. TO STA.

F.A.P. RTE. 341	SECTION 32-2-R-N	COUNTY COOK	TOTAL SHEETS 53	SHEET NO. 13
			CONTRACT NO. 60E64	
ILLINOIS FED. AID PROJECT				