




- DRAINAGE LEGEND**
- XXX PROPOSED DRAINAGE PIPE
  - XXX PROPOSED DRAINAGE STRUCTURE


- NOTES:**
1. EXISTING DRAINAGE TO BE MAINTAINED AT ANY TIME DURING THE CONSTRUCTION.
  2. ALL DIMENSIONS ARE IN FEET UNLESS OTHERWISE NOTED.
  3. ALL STATIONS AND OFFSETS ARE OFF OF RAMP D BASE LINE UNLESS OTHERWISE NOTED.
  4. CONNECTION OF EXISTING SEWER TO PROPOSED DRAINAGE STRUCTURE IS INCLUDED IN THE COST OF PROPOSED DRAINAGE STRUCTURE.
  5. FOR DRAINAGE STRUCTURE AND PIPE INFORMATIONS, SEE SHEET DU-11
  6. FOR RAMP D DRAINAGE, SEE SHEETS PD-1 TO PD4 FOR FLOW LINE HIGH POINT & LOW POINT LOCATIONS.
  7. ALL CONCRETE AND CORRUGATED METAL END SECTIONS AND FLARED END SECTIONS REMOVAL SHALL BE CONSIDERED AS PART OF ITEM 20200100. NO ADDITIONAL PAYMENT SHALL BE MADE FOR THIS WORK.
  8. FOR STORM SEWER PROFILE, SEE DRAWING DU-12
  9. SEE DRAWING PD-4 FOR DRIVEWAY PAVEMENT REMOVAL DETAILS.

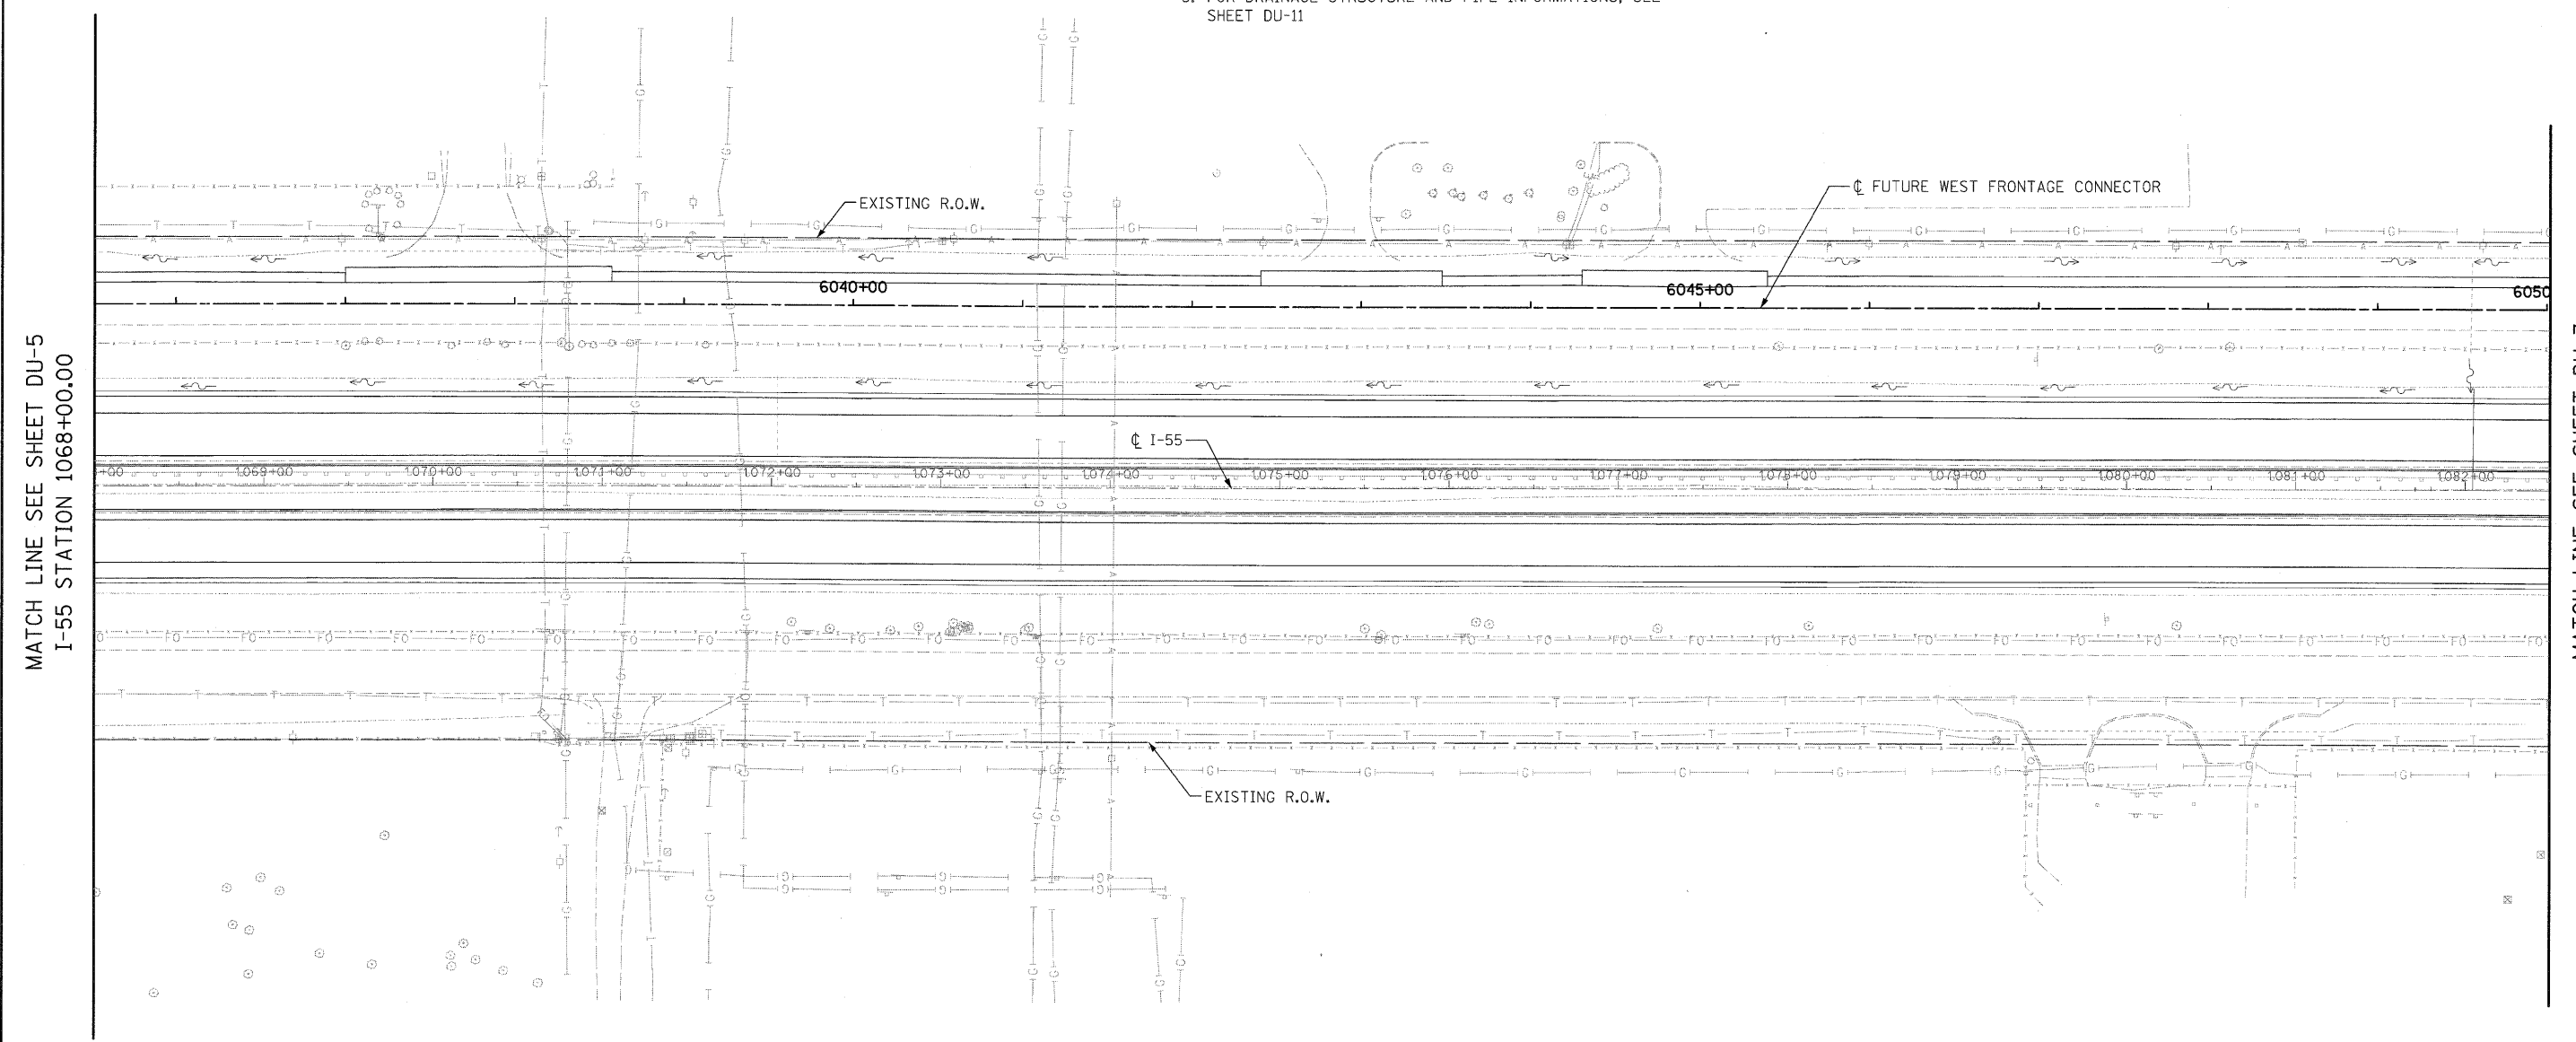

MATCH LINE SEE SHEET DU-5  
I-55 STATION 1068+00.00

MATCH LINE SEE SHEET DU-7  
I-55 STATION 1082+50.00

**SINGH**  
300 W. ADAMS ST.  
CHICAGO, IL 60606  
SINGH & ASSOCIATES, INC.  
CONSULTING ENGINEERS  
TEL: (312) 629-0240  
FAX: (312) 629-8449

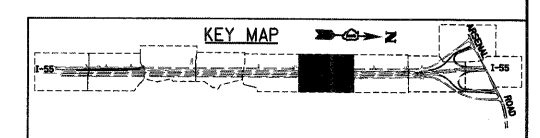

FILE NAME = 0158071-SHT-DRA1N06.dgn	USER NAME = TKLegal	DESIGNED - VP	REVISED -	<b>STATE OF ILLINOIS DEPARTMENT OF TRANSPORTATION</b>	<b>PROPOSED DRAINAGE AND UTILITY PLAN</b>			F.A.I RTE. 55	SECTION 99-2HB-2-R	COUNTY WILL	TOTAL SHEETS 171	SHEET NO. 77
	PLOT SCALE = 1:50	DRAWN - VP	REVISED -		SCALE: 1"=50'	SHEET NO. 6 OF 10 SHEETS	STA. 1068+00.00 TO STA. 1082+50.00	CONTRACT NO. 60F71				
	PLOT DATE = 3/28/2009	CHECKED - PKT	REVISED -		FED. ROAD DIST. NO. 1 ILLINOIS FED. AID PROJECT							
		DATE - 03/20/09	REVISED -		<b>FINAL</b>							