


DRAINAGE LEGEND

- XXX PROPOSED DRAINAGE PIPE
- XXX PROPOSED DRAINAGE STRUCTURE

 
NOTES:

1. EXISTING DRAINAGE TO BE MAINTAINED AT ANY TIME DURING THE CONSTRUCTION.
2. ALL DIMENSIONS ARE IN FEET UNLESS OTHERWISE NOTED.
3. ALL STATIONS AND OFFSETS ARE OFF OF RAMP D BASE LINE UNLESS OTHERWISE NOTED.
4. CONNECTION OF EXISTING SEWER TO PROPOSED DRAINAGE STRUCTURE IS INCLUDED IN THE COST OF PROPOSED DRAINAGE STRUCTURE.
5. FOR DRAINAGE STRUCTURE AND PIPE INFORMATIONS, SEE SHEET DU-11
6. FOR RAMP D DRAINAGE, SEE SHEETS PD-1 TO PD4 FOR FLOW LINE HIGH POINT & LOW POINT LOCATIONS.
7. ALL CONCRETE AND CORRUGATED METAL END SECTIONS AND FLARED END SECTIONS REMOVAL SHALL BE CONSIDERED AS PART OF ITEM 20200100. NO ADDITIONAL PAYMENT SHALL BE MADE FOR THIS WORK.
8. FOR STORM SEWER PROFILE, SEE DRAWING DU-12
9. SEE DRAWING PD-4 FOR DRIVEWAY PAVEMENT REMOVAL DETAILS.

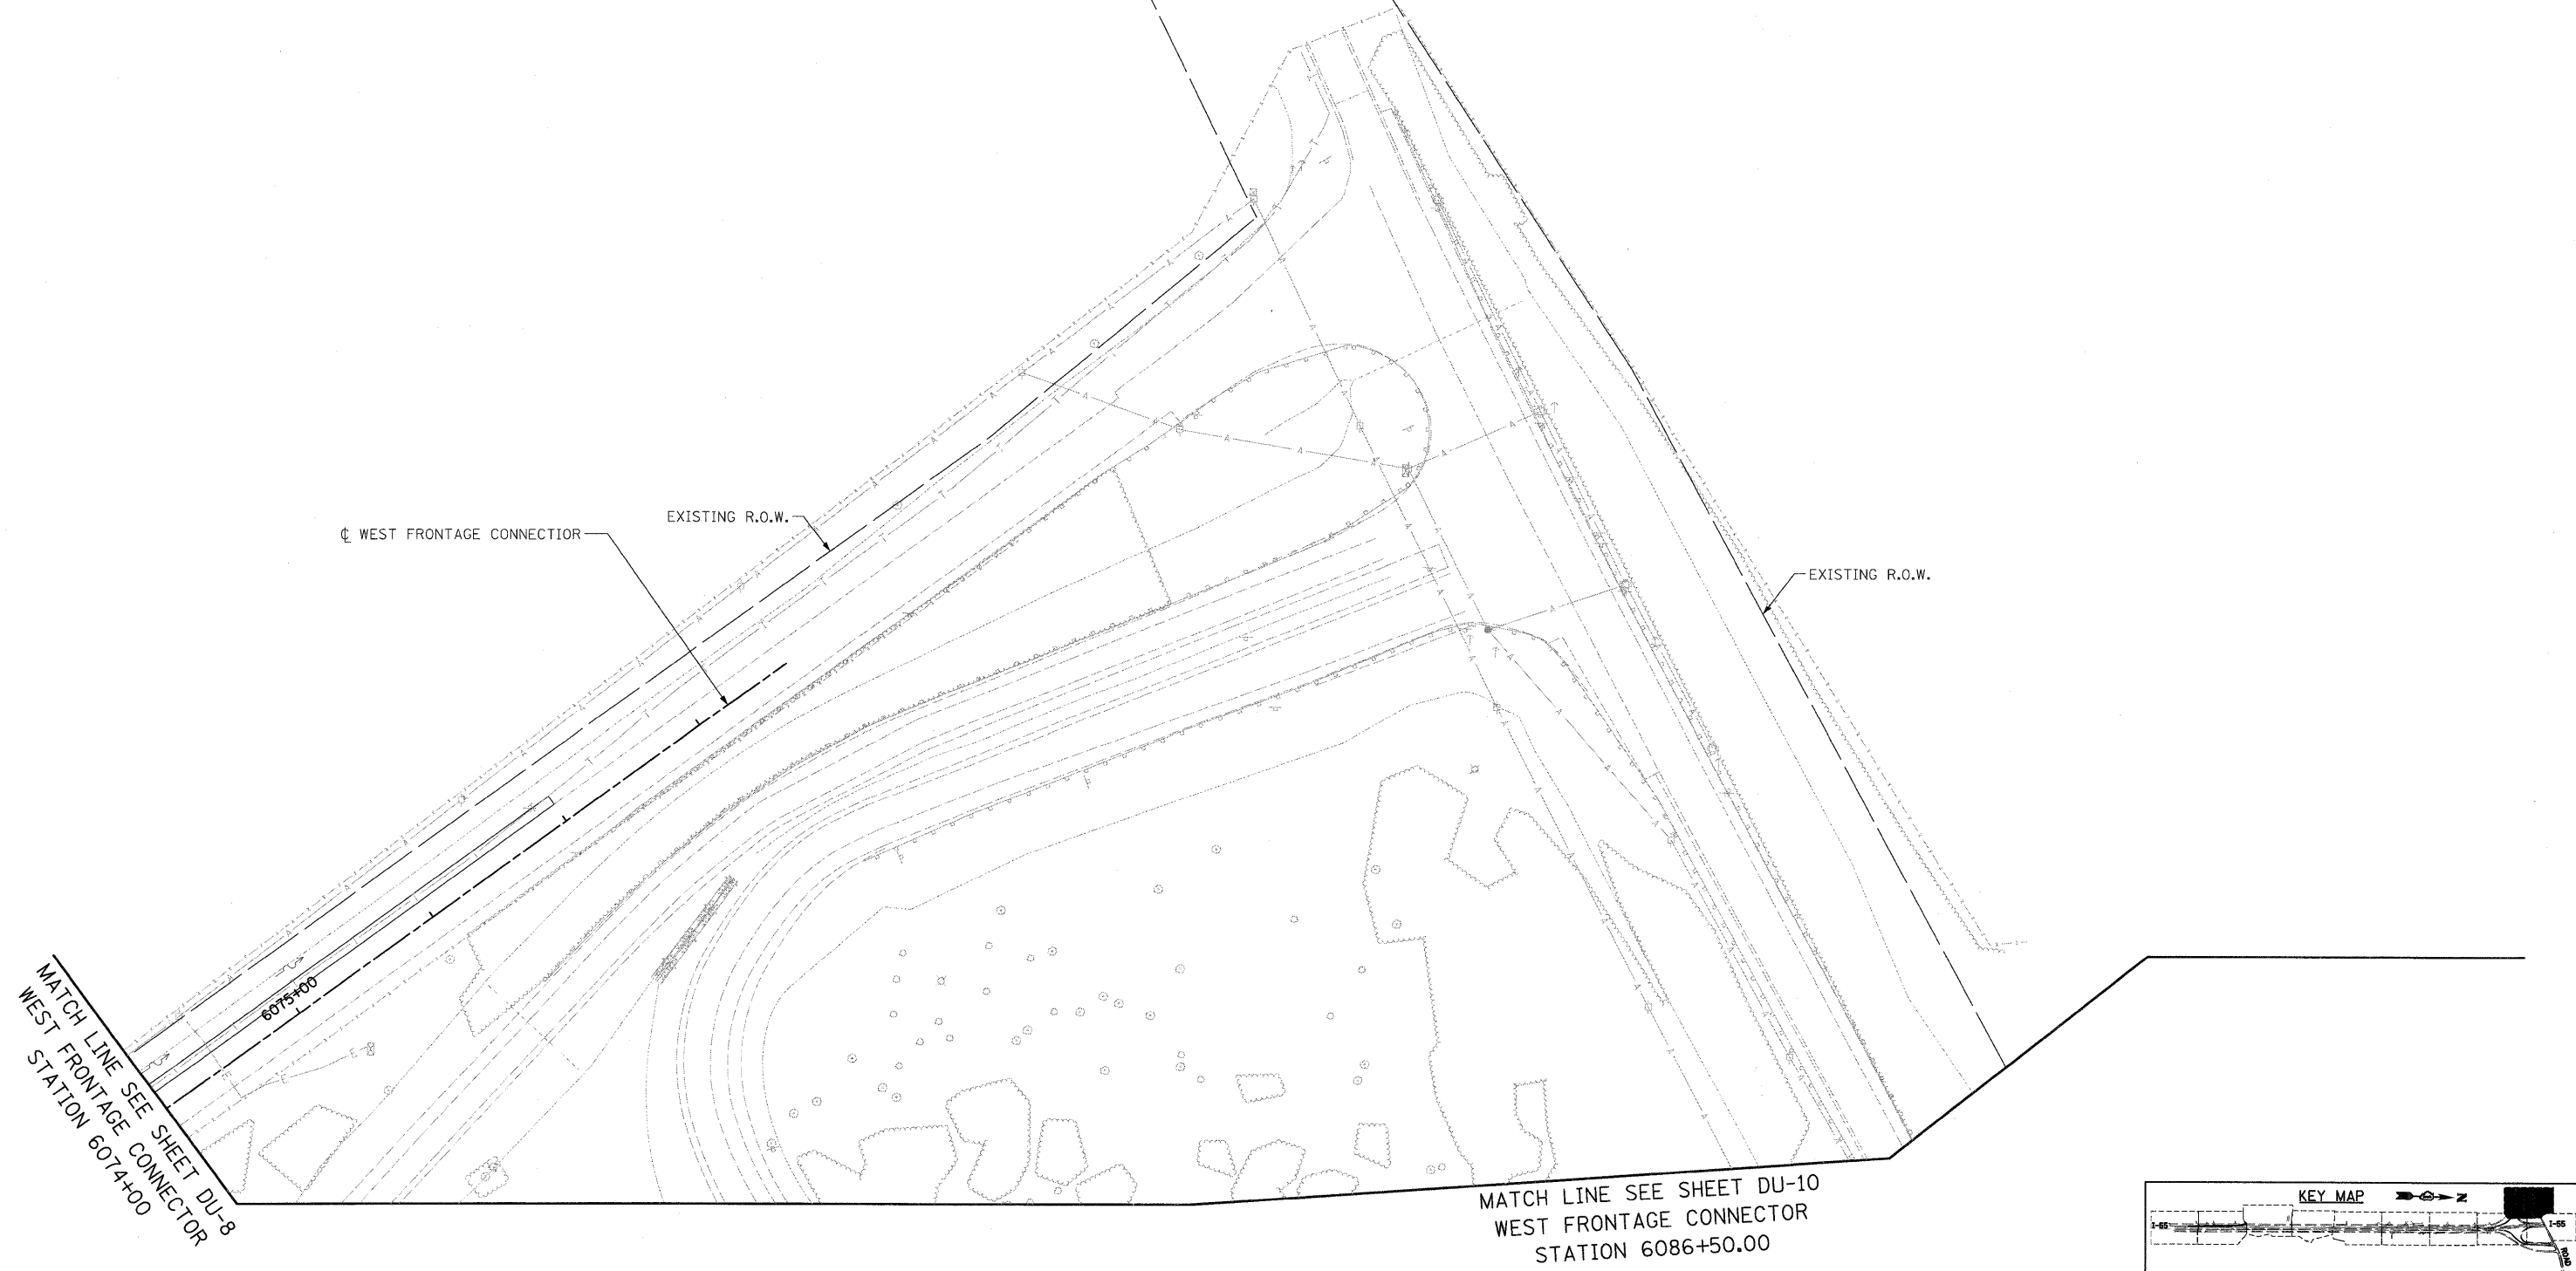

MATCH LINE SEE SHEET DU-8
WEST FRONTAGE CONNECTOR
STATION 6074+00

MATCH LINE SEE SHEET DU-10
WEST FRONTAGE CONNECTOR
STATION 6086+50.00



SINGH
 300 W. ADAMS ST.
 CHICAGO, IL 60606
 SINGH & ASSOCIATES, INC.
 CONSULTING ENGINEERS
 TEL: (312) 629-0240
 FAX: (312) 629-8449

FILE NAME =	USER NAME = TKLuegel
D160F71-SHT-DRAIN09.dgn	

PLOT SCALE = 1:50	DESIGNED - VP	REVISED -
PLOT DATE = 3/20/2009	DRAWN - VP	REVISED -
	CHECKED - PKT	REVISED -
	DATE - 03/20/09	REVISED -

DESIGNED - VP	REVISED -
DRAWN - VP	REVISED -
CHECKED - PKT	REVISED -
DATE - 03/20/09	REVISED -

**STATE OF ILLINOIS
DEPARTMENT OF TRANSPORTATION**

PROPOSED DRAINAGE AND UTILITY PLAN

SCALE: 1"=50' SHEET NO. 9 OF 10 SHEETS STA. 6074+00.00 TO STA. 6086+50.00

F.A.I. RTE.	SECTION	COUNTY	TOTAL SHEETS	SHEET NO.
55	99-2HB-2-R	WILL	171	80
FED. ROAD DIST. NO. 1 ILLINOIS FED. AID PROJECT			CONTRACT NO. 60F71	

FINAL