

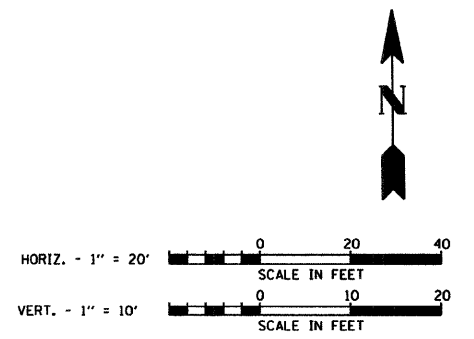


F.A.U. ROUTE NO.	SECTION	COUNTY	TOTAL SHEETS	SHEET NO.
4011	07-00072-00-PV	McHENRY	80	33
ILLINOIS PROJECT				
CONTRACT NO. 63137				

- NOTES:
1. ALL CURB LINE STRUCTURE LOCATIONS & ELEVATIONS ARE INDICATED AT THE EDGE OF PAVEMENT. ALL OTHER STRUCTURES ARE INDICATED AT THEIR CENTER.
 2. ALL PIPE LENGTHS ARE INDICATED TO INSIDE WALL OF STRUCTURE.

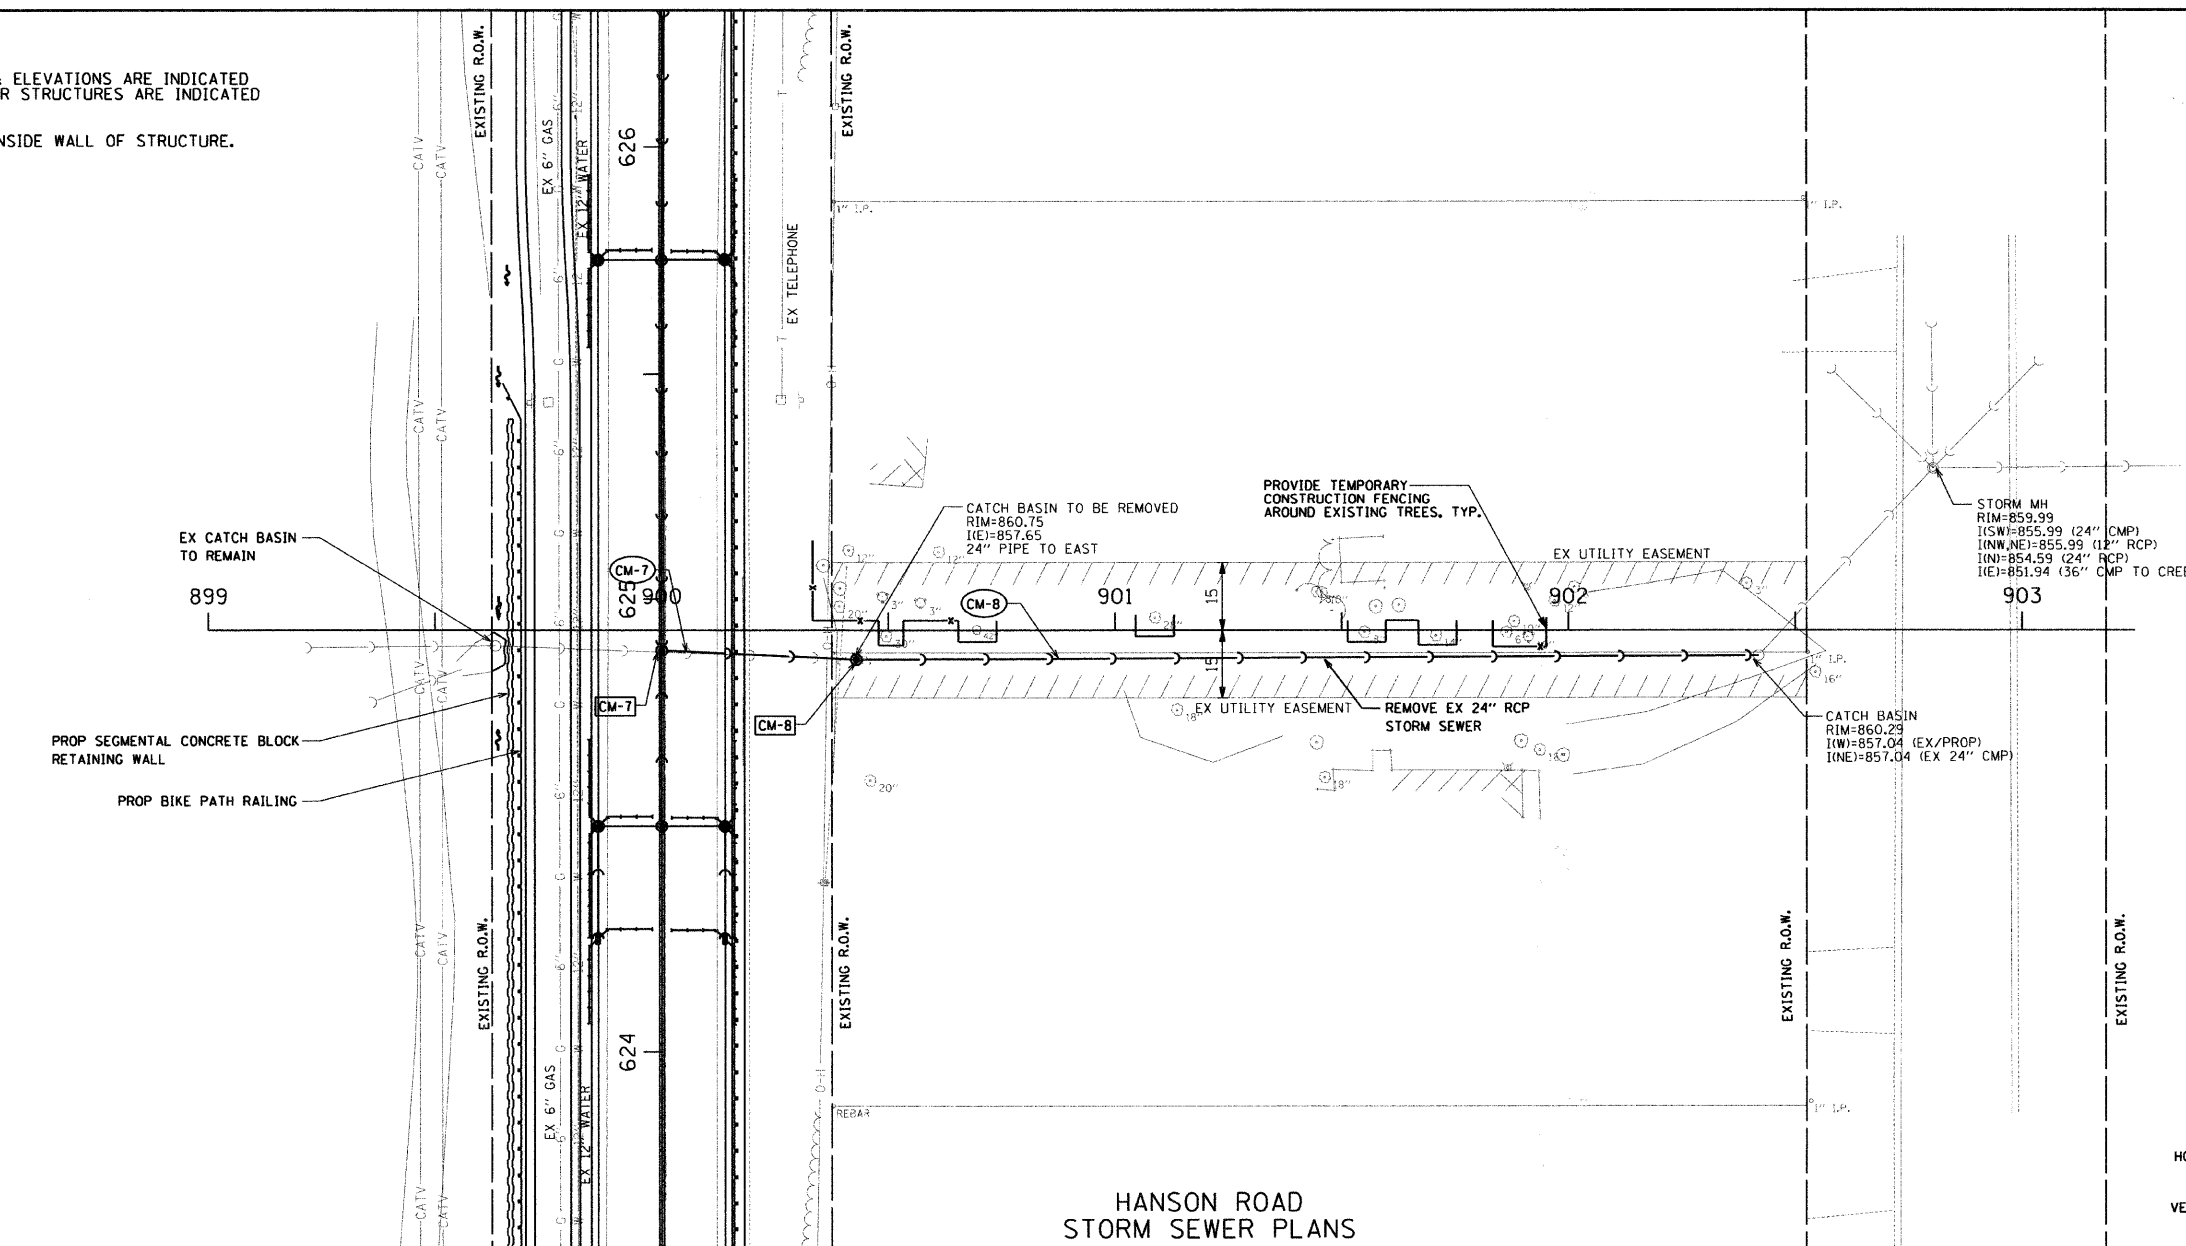

HANSON ROAD
STORM SEWER PLANS

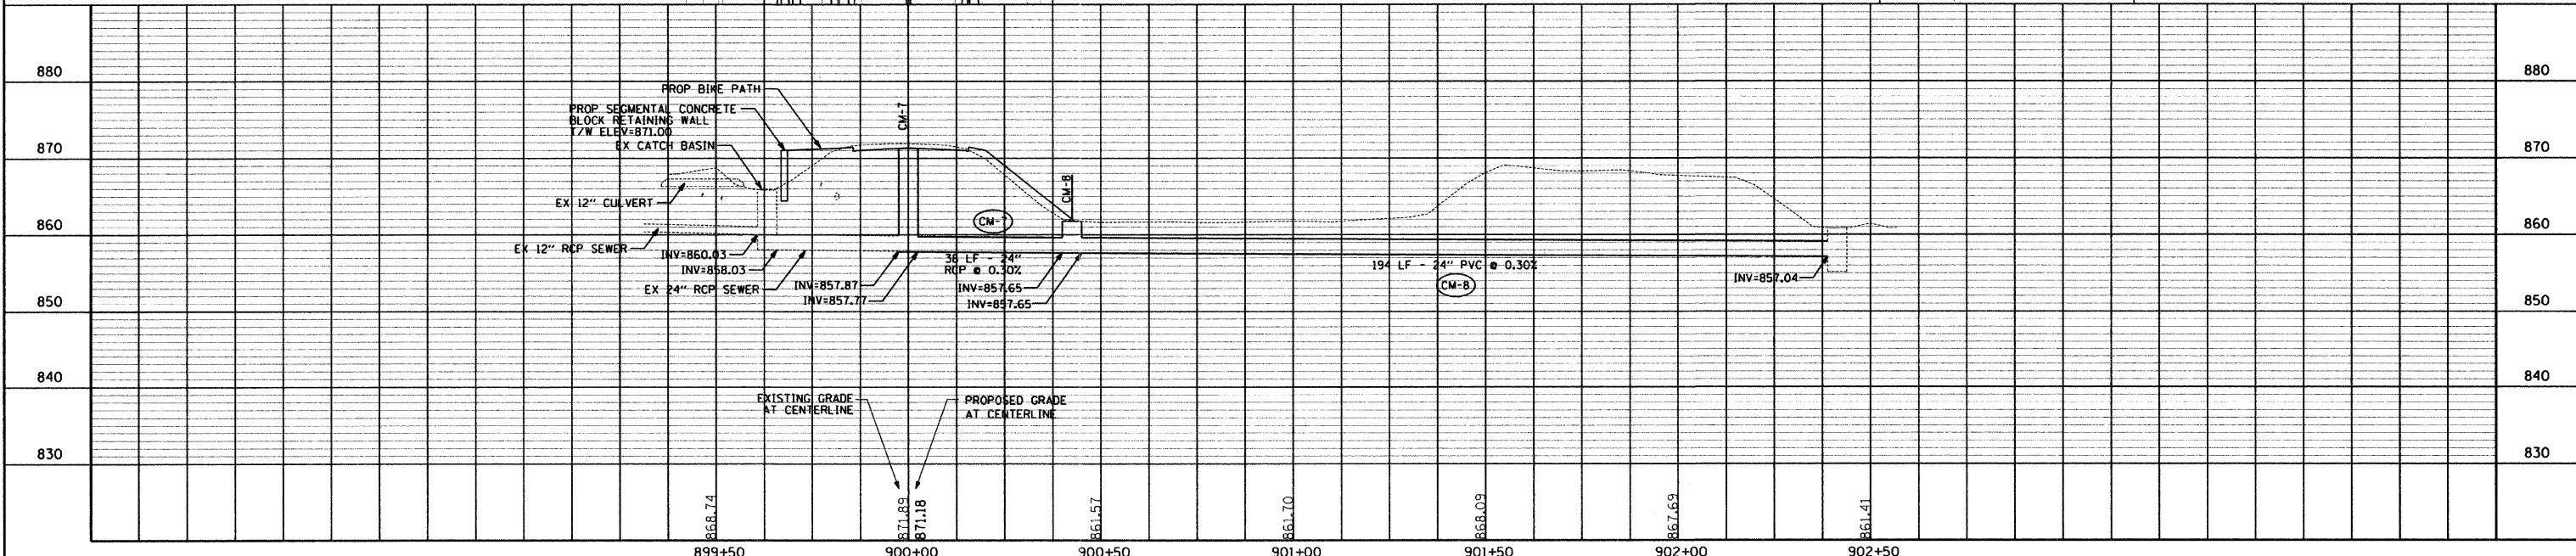

PLAN AND PROFILE HANSON ROAD STA. 899+00 TO STA. 903+00