
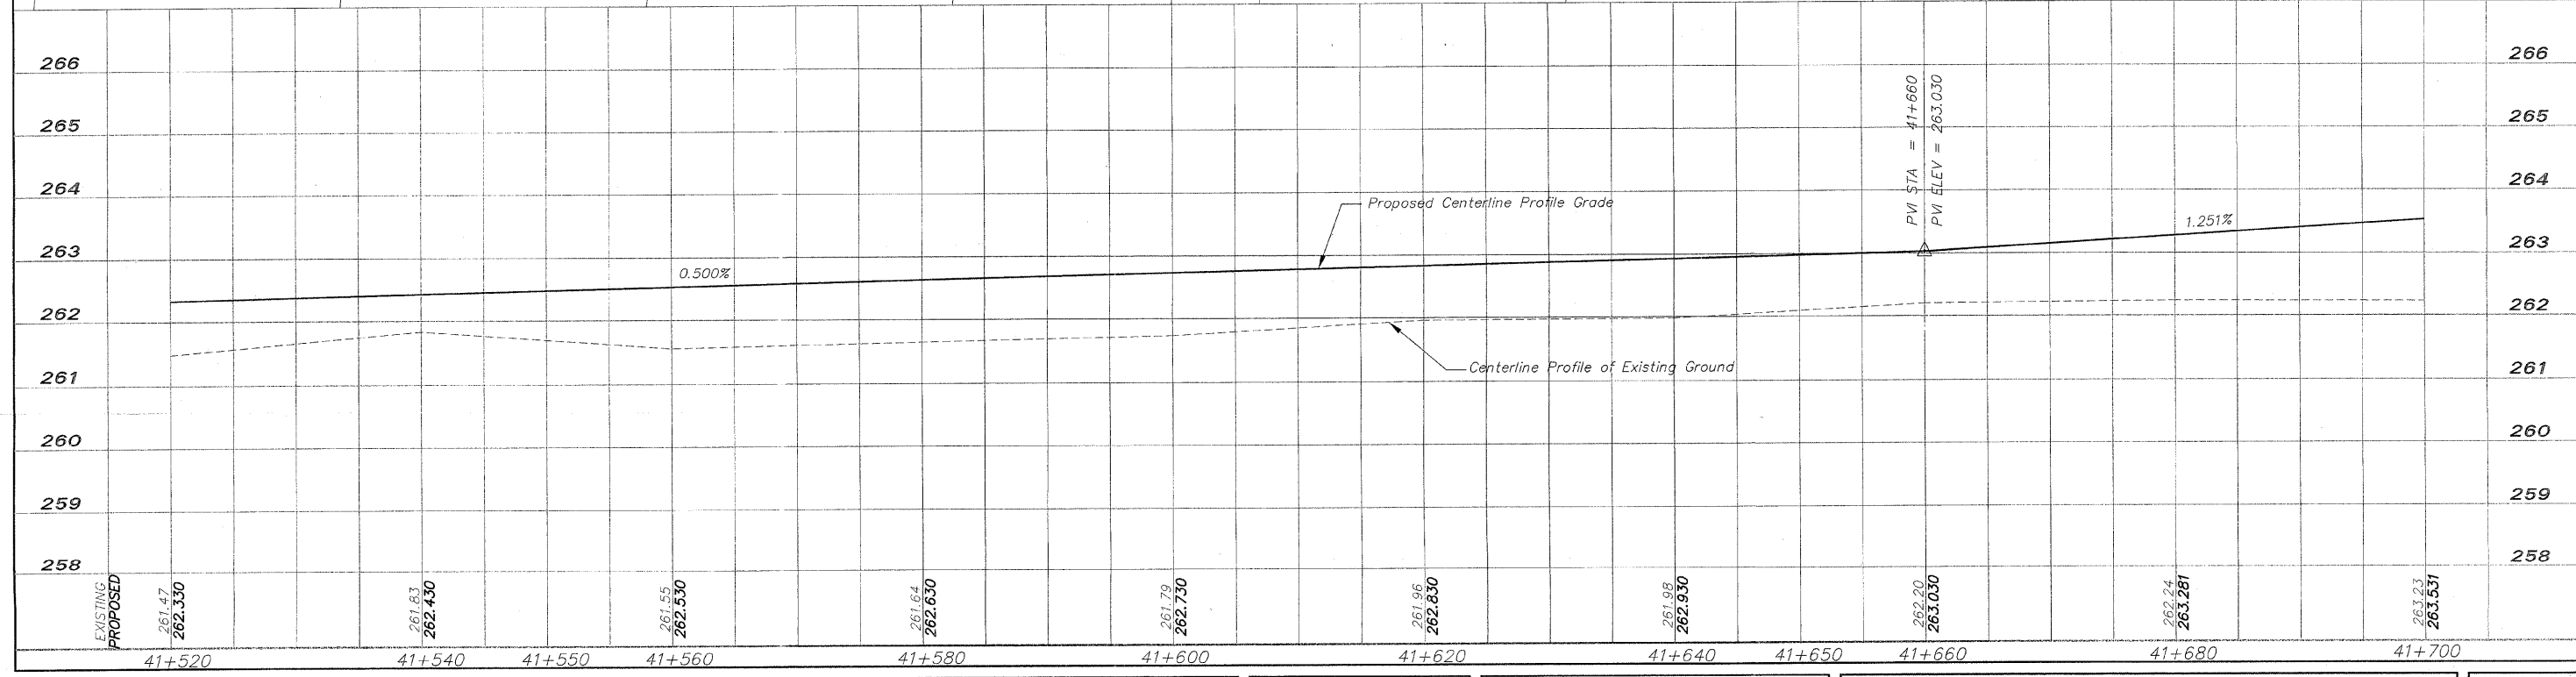


G:\surveys\PECPATH\1ST RELEASE\98-037 pp41-500-41+700.dwg, Layout1, 3/4/2009 11:05:57 AM, 1:1, REK

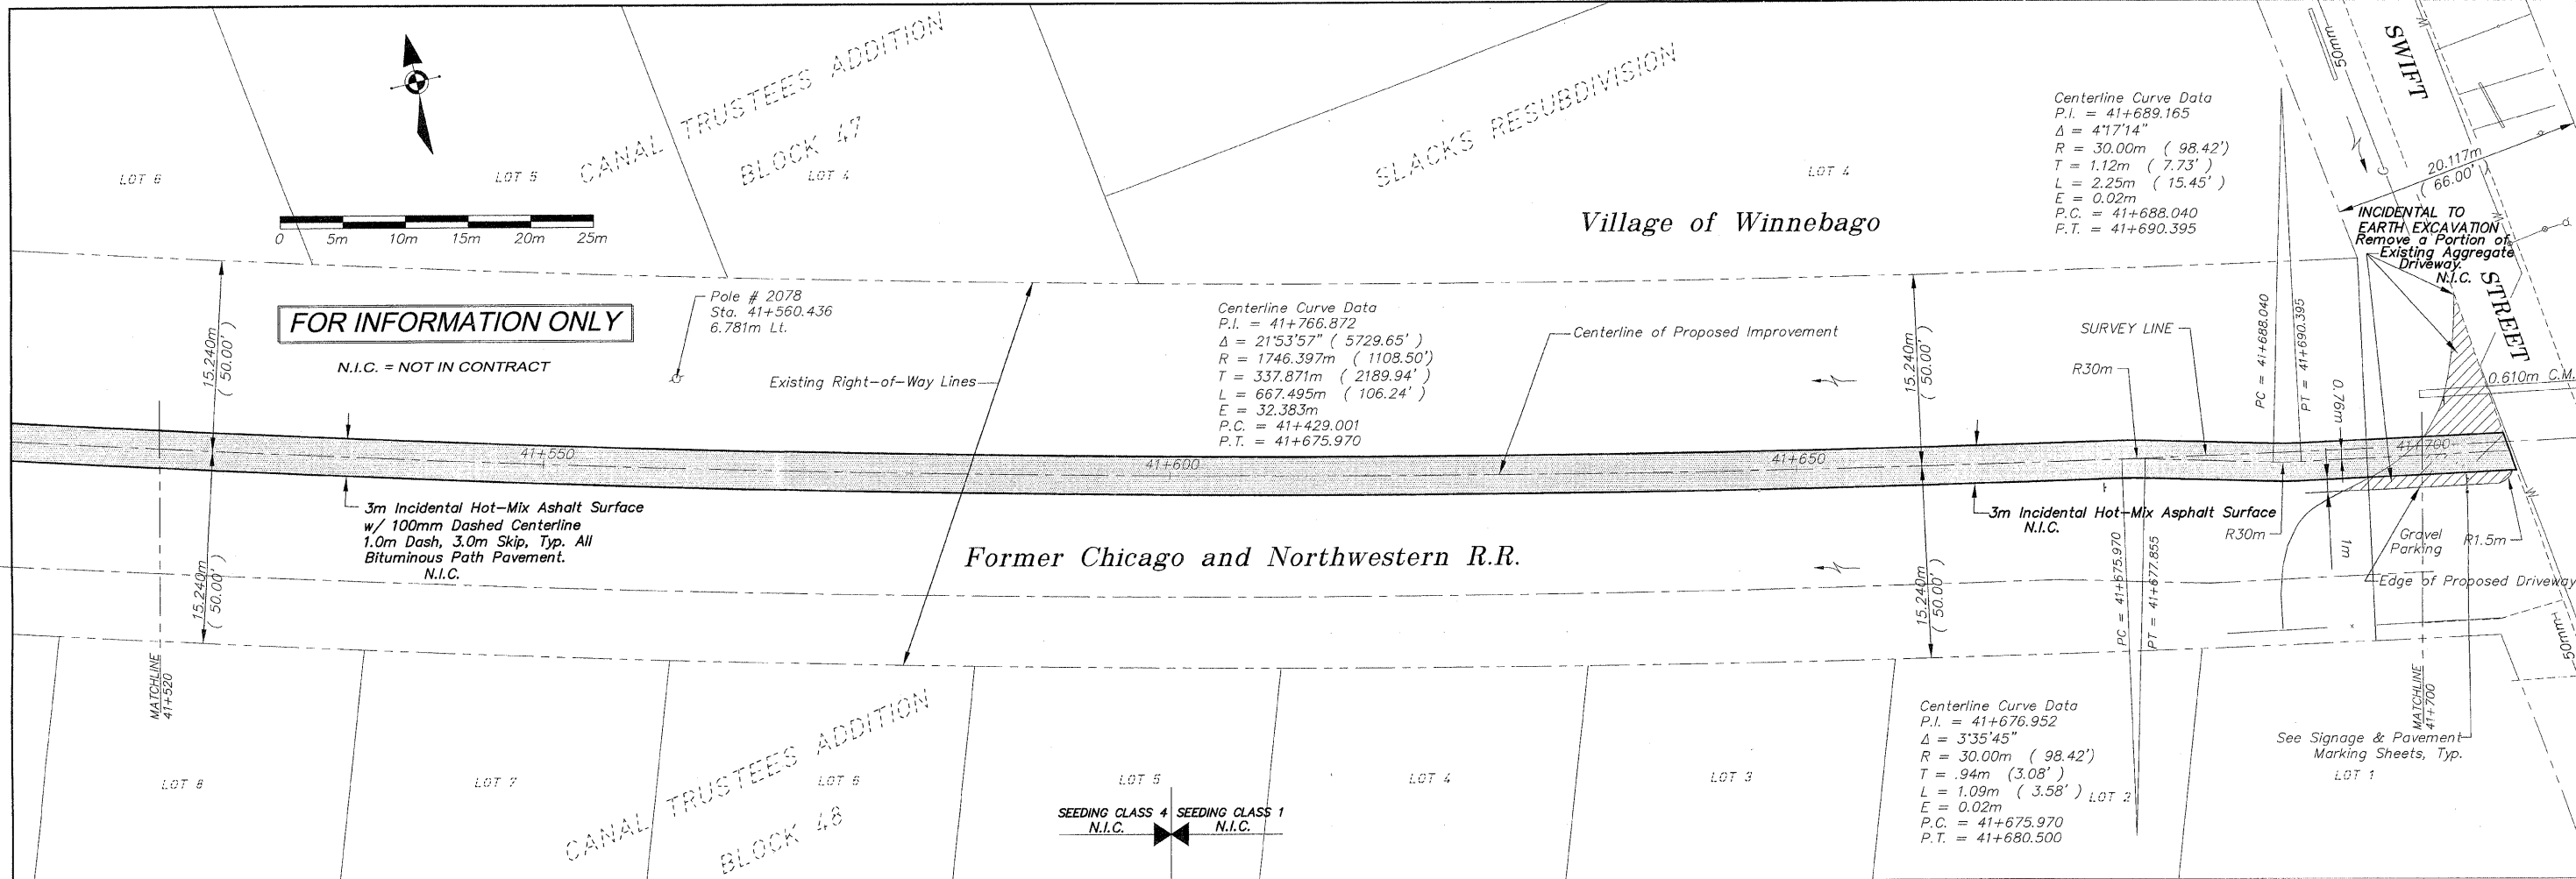

NO.	ITEM	DATE
2	REVIEW COMMENTS	1/22/09

REVISIONS		
NO.	ITEM	DATE
2	REVIEW COMMENTS	1/22/09

PLOTTING SCALE: 1 : 1  
 DRAWN BY: REK  
 CHECKED BY:  
 DATE: DECEMBER, 2008

**McClure**  
 Engineering Associates, Inc.  
 7282 Argus Drive Rockford, Illinois 61107-5837  
 (815) 398-2332 FAX (815) 398-2496  
 Design Firm License: Illinois 184-000816  
 Copyright 2006 By McClure Engineering Associates, Inc.

**PLAN AND PROFILE 41+520/41+700**  
**PECATONICA PRAIRIE PATH** Contract 95443  
 WINNEBAGO COUNTY HIGHWAY DEPARTMENT SECTION 94-00267-00-BT  
 FILE NAME: G:\surveys\PECPATH\1ST RELEASE\98-037 pp41+500-41+700.dwg JOB NUMBER: 04-28-98-037

SHEET NO.  
**18**  
**OF**  
**98**