

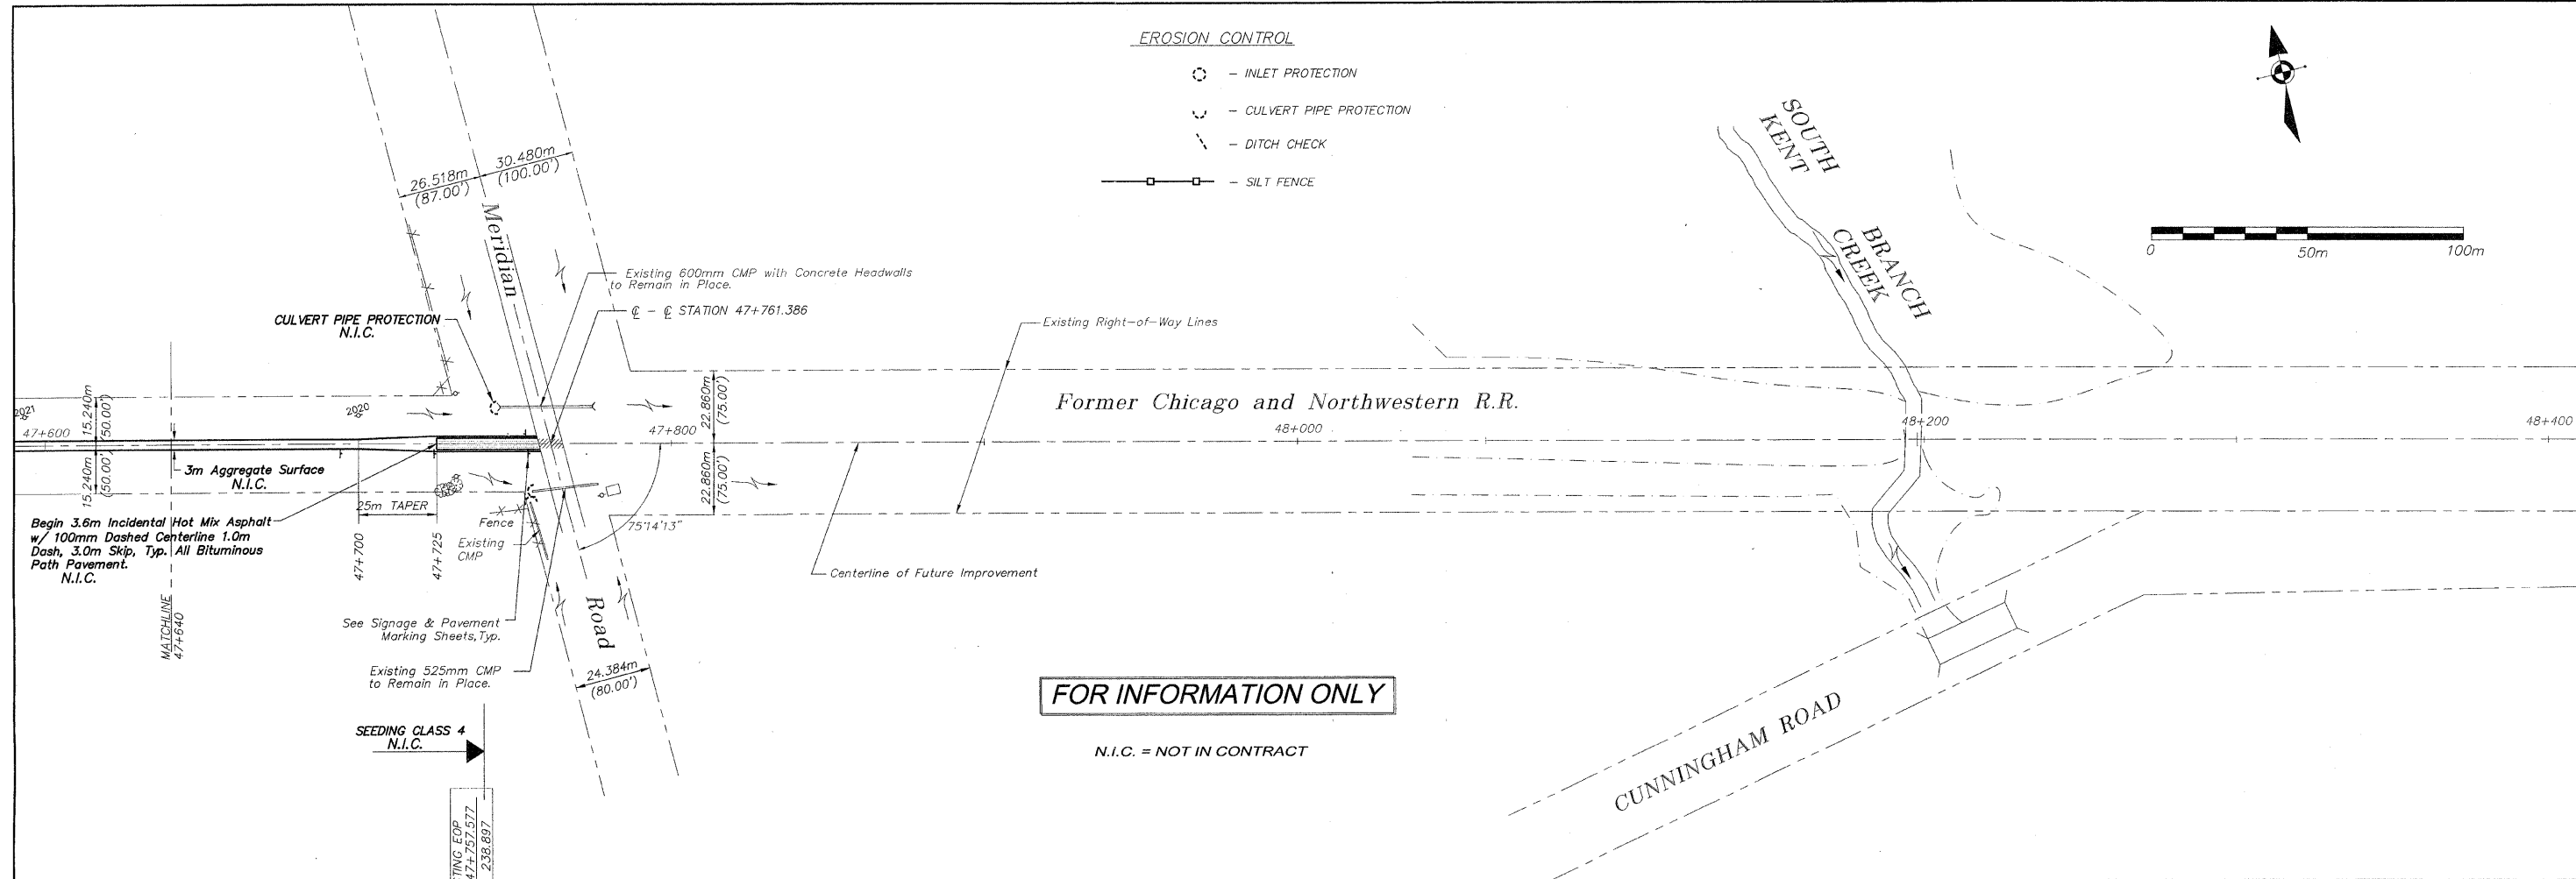


- EROSION CONTROL**
- - INLET PROTECTION
 - ⊂ - CULVERT PIPE PROTECTION
 - - - DITCH CHECK
 - SILT FENCE

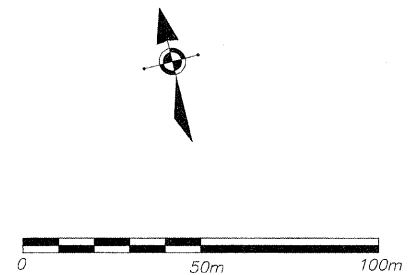

FOR INFORMATION ONLY
 N.I.C. = NOT IN CONTRACT

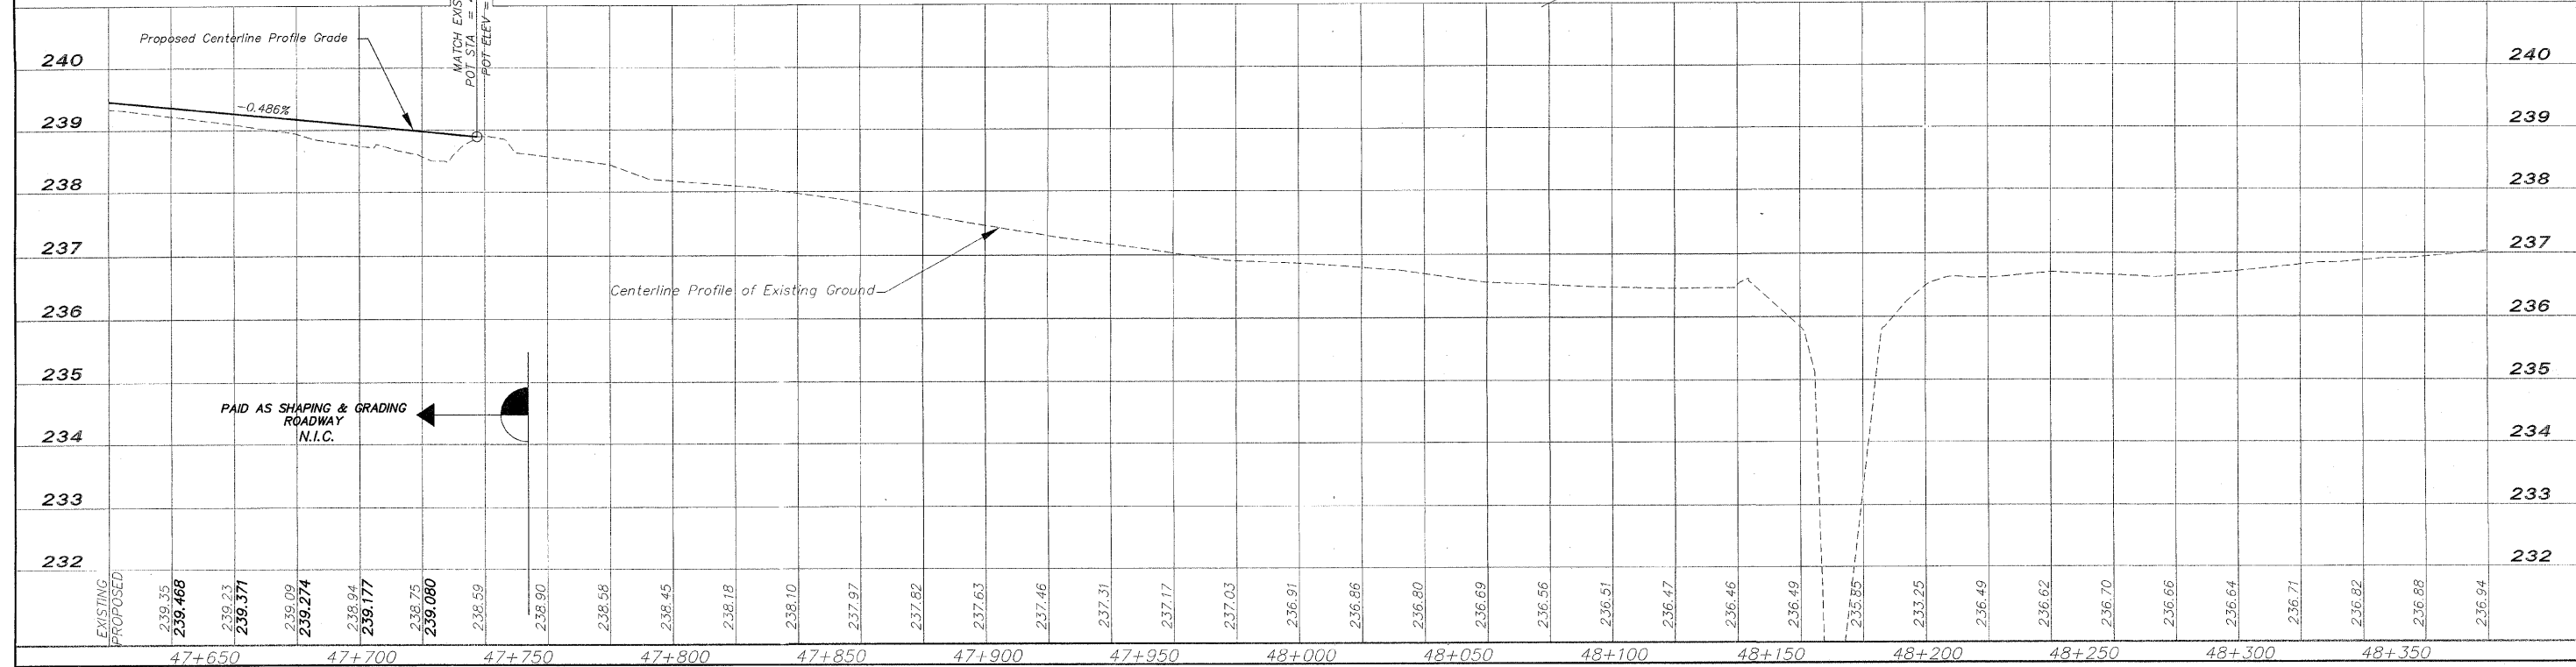

NO.	ITEM	DATE
2	REVIEW COMMENTS	1/22/09

NO.	ITEM	DATE
2	REVIEW COMMENTS	1/22/09

PLOTTING SCALE: 1 : 1
 DRAWN BY: REK
 CHECKED BY:
 DATE: DECEMBER, 2008

McClure
 Engineering Associates, Inc.
 7282 Argus Drive Rockford, Illinois 61107-5837
 (815) 398-2332 FAX (815) 398-2496
 Design Firm License: Illinois 184-000816
 Copyright 2006 By McClure Engineering Associates, Inc.

PLAN AND PROFILE 47+640/47+757
 PECAONICA PRAIRIE PATH Contract 85443
 WINNEBAGO COUNTY HIGHWAY DEPARTMENT SECTION 94-00267-00-BT
 FILE NAME: G:\surveys\PECPATH\1ST RELEASE\98-037 pp47+640-47+757.dwg JOB NUMBER: 04-28-98-037

SHEET NO.
31
 OF
98